




New Food Truck

El Roy's Express Mex

505-509-515-517-523 Santa Rosa Ave.
& 518 Sebastopol Rd.
Santa Rosa CA 95404
APN #010-223-063 / 061 / 059 / 065 / 057
& 010-223-007

Owner:
El Roy's Express Mex Inc.
Roy Cabrera
2661 Santa Rosa Ave. #354
Santa Rosa CA 95407
(707) 304-1596

Sheet Index:
A1.1 Title Sheet, Vicinity Map Site Plan
A1.2 Neighborhood Context Map
A1.3 Site Photos
Rv OA Photometric Site Plan

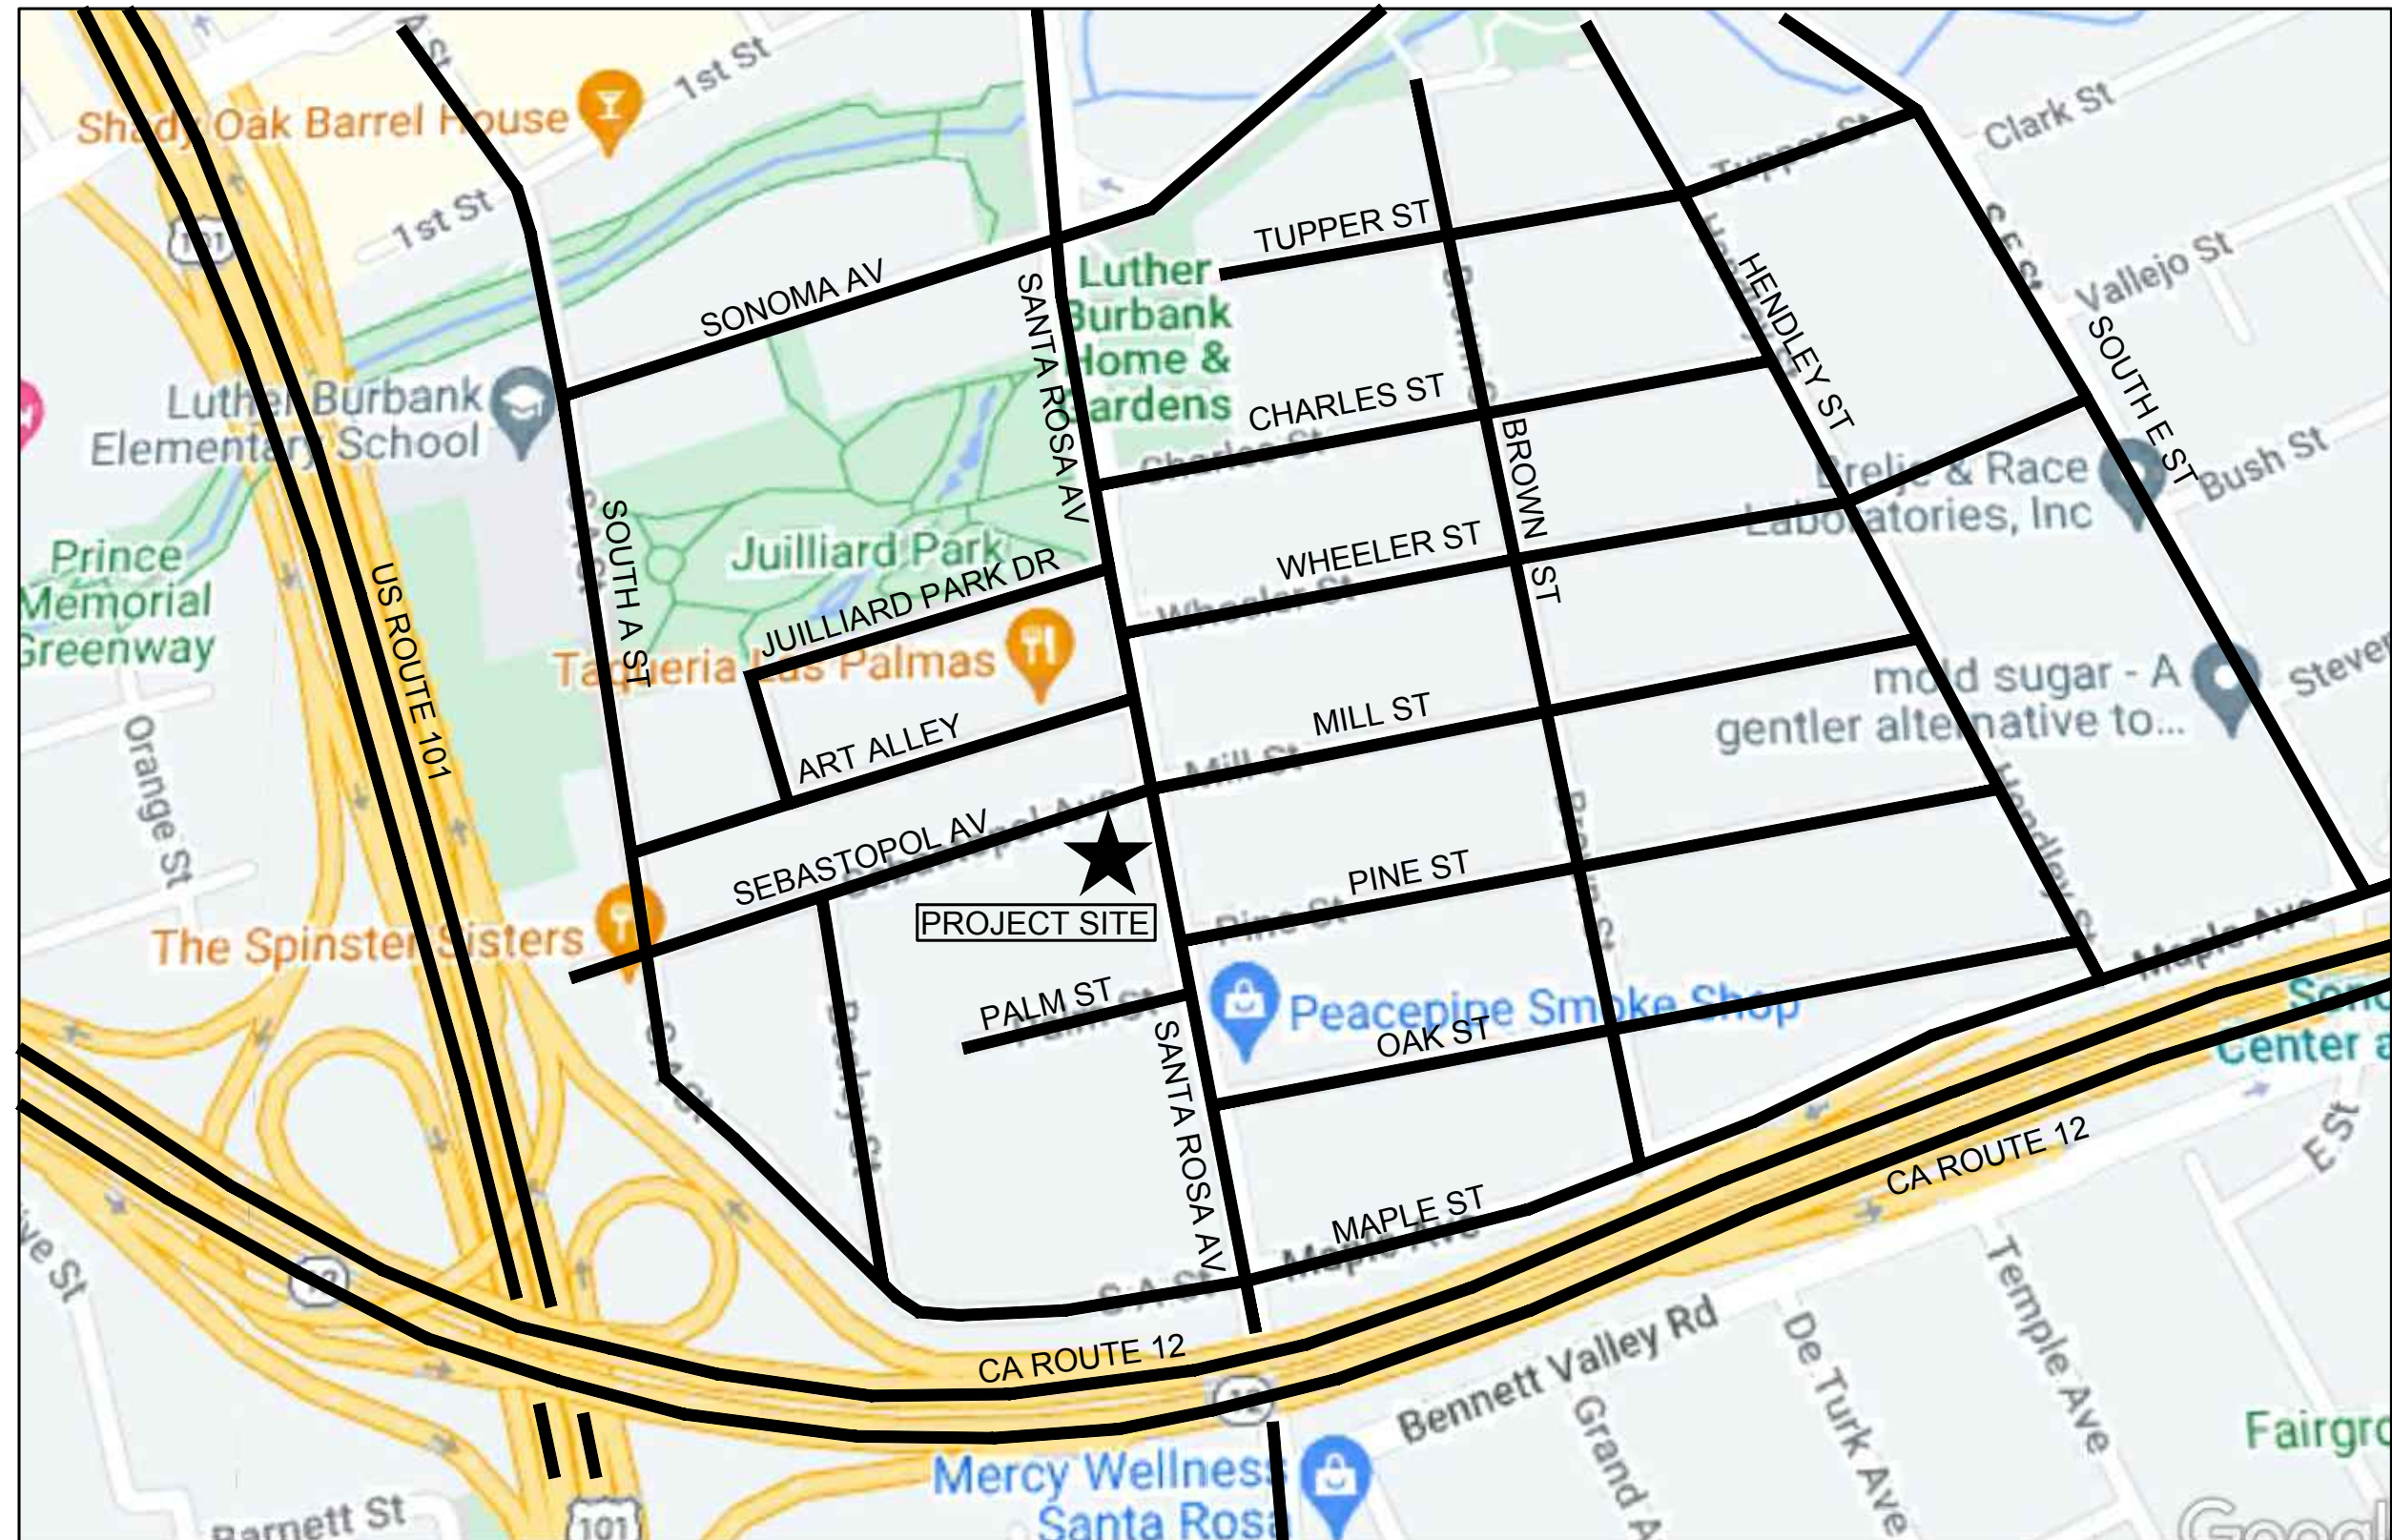

Site Plan
DRAWING SCALE 1" = 20'

Vicinity Map
No Drawing Scale



Revisions
220511 SITE PLAN
220705 PLNG RESUBMIT

Job Number
2204

Project Designer
PAUL GILGER

Drawn By
PAUL GILGER

Date
CONTRACT: MARCH 2021

Sheet
A1.2

NOT FOR CONSTRUCTION
of -



Toilet Rm door

3

View of adjacent toilet room



4

View of site from North



5

View of site from Northeast



2

View of small tree



6

View of site from East



1

View of large tree



7

View of site from Southeast

THIS LIGHTING APPLICATION REQUIRES SPECIFIC LIGHTING CONTROL DEVICES OR SYSTEMS PER CALIFORNIA TITLE 24 PART 6.

Therefore, this proposal includes:

☐ SOLUTION: This proposal includes a complete lighting and control system either as an alternative to that specified, or as a recommendation based on the information provided, subject to your review and approval.

☐ SUPPLEMENT: This proposal includes lighting as requested/specified, as well as a proposed lighting control system for your review and approval.

☒ ALERT: This proposal includes only lighting as requested/specified. However, the application hereby requires compatible lighting controls to meet the following criteria. We are happy to provide a lighting control quote/proposal at your request.

Manual Switch(es)

Automatic time switch (astronomical)

Occupancy Sensor(s)

Photosensor(s) / daylight sensor(s)

Demand response / load shedding


Controlled Receptacle(s)

Motion Sensor(s) - Outdoor

sixteen5hundred

Ceiling Height: Varies
Luminaire Mounting Height: As noted
Calculation Point Height: As noted

Luminaire illuminance values provided in this report, whether for normal, critical, or emergency applications, are for product application assistance only. These values were developed in collaboration with, and are subject to approval by, the design professional of record (architect/engineer/LC), and are NOT intended for construction. Because these values are approximate and based on limited application information provided to 16500, Inc. at the time of calculation, 16500, Inc. does not warrant the installed performance of the luminaire(s) will match that shown in this report. Please verify all data and conditions to assure the accuracy of the report. 16500 shall neither be responsible nor liable for design, approval, or results of emergency lighting under any circumstance.

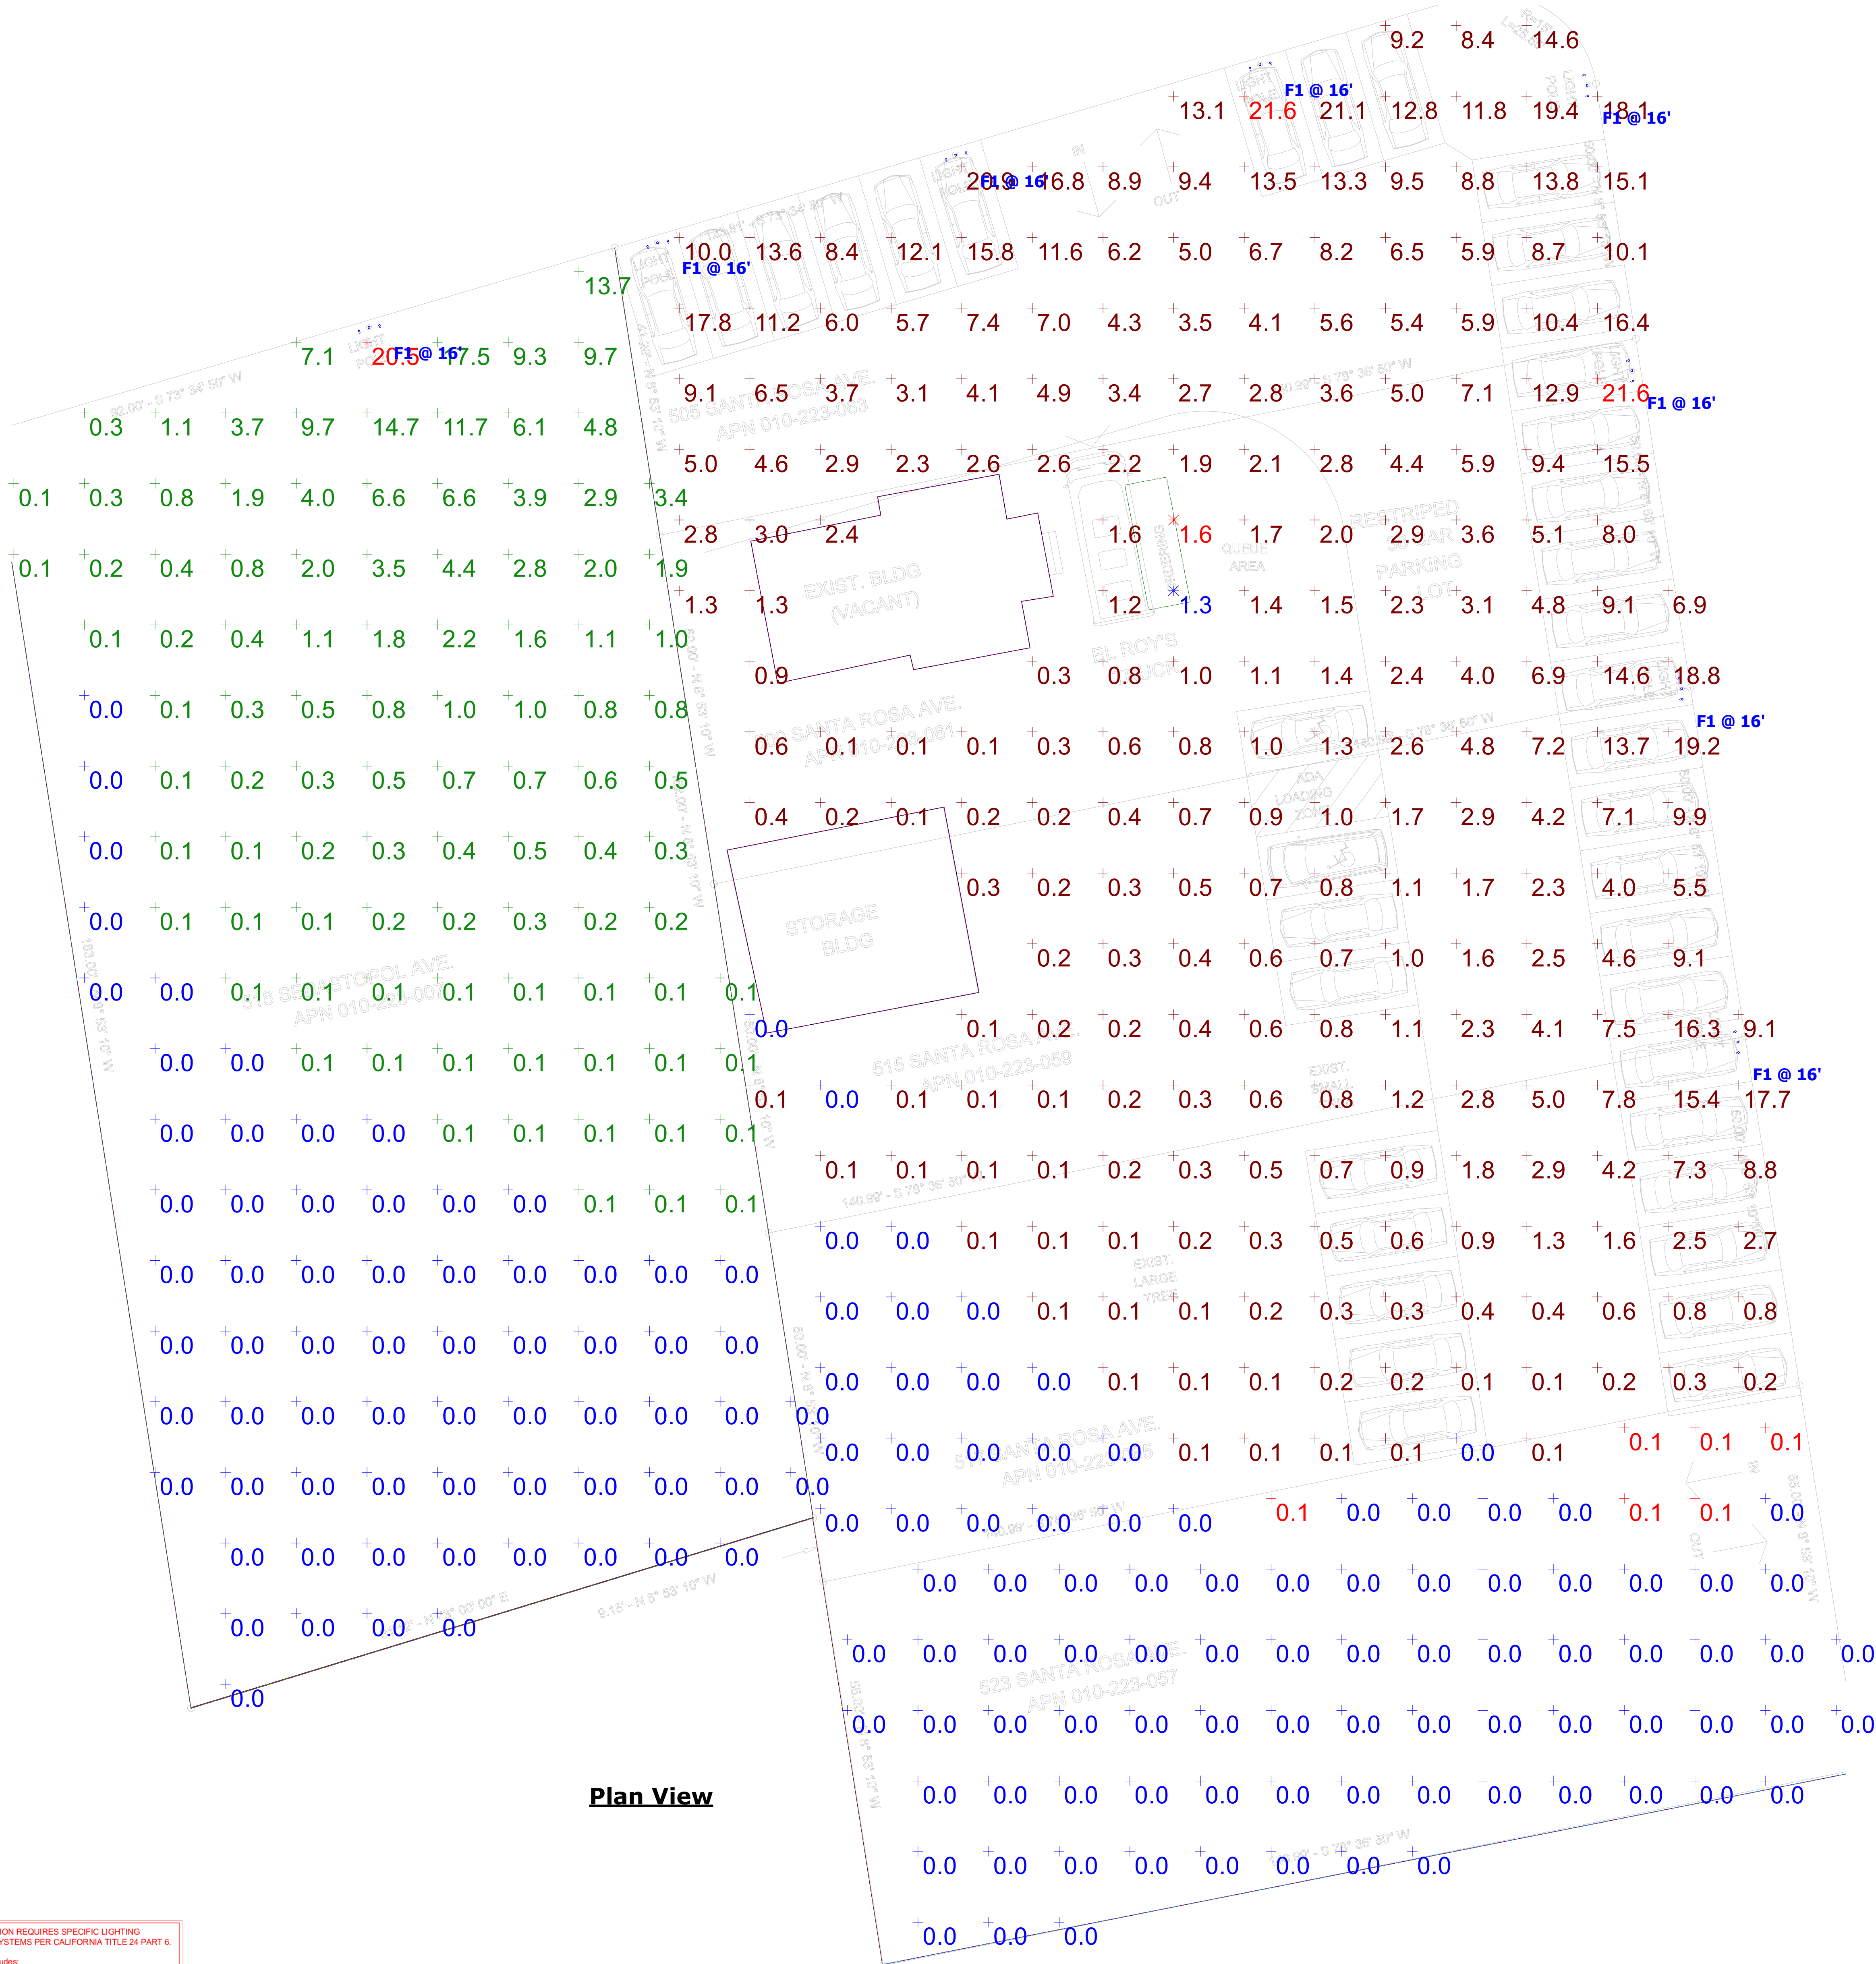

Plan View

Schedule									
Symbol	Label	Quantity	Manufacturer	Catalog Number	Description	Lamp	Lumens Per Lamp	Light Loss Factor	Wattage
⦿	F1	8	SLOANLED	LCG-SB-100W-U-40K-T4-(finish)-(mounting)-D1			13200	0.85	200

Statistics						
Description	Symbol	Avg	Max	Min	Max/Min	Avg/Min
Ordering 0'-0"	✕	1.4 fc	1.6 fc	1.3 fc	1.2:1	1.1:1
Parking Lot 0'-0"	+	4.1 fc	21.6 fc	0.0 fc	N/A	N/A
Parking Lot Exit 0'-0"	+	0.0 fc	0.1 fc	0.0 fc	N/A	N/A
Landcape Spill Light 0'-0"	+	1.2 fc	20.5 fc	0.0 fc	N/A	N/A

Finish Schedule		
Finish	Surface	Reflectance / Transmittance
Grey	Walls	50%
Grey	Ground	20%