



RECEIVED
By Susie Murray at 12:14 pm, Apr 29, 2022

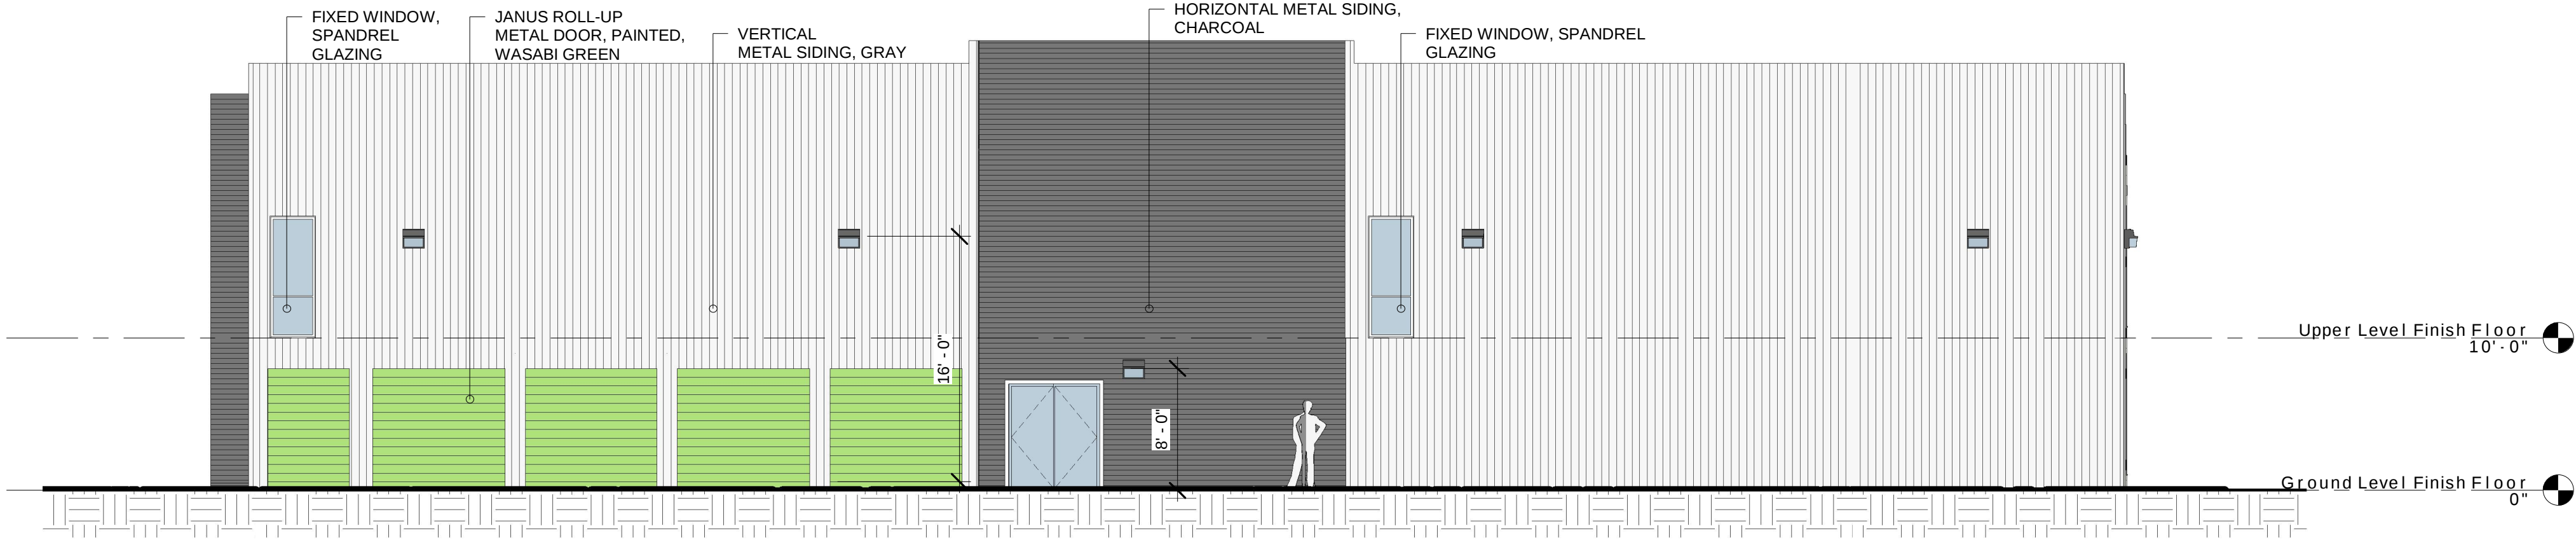


Buiding A Lot 2 North Elevation

Scale 1/8" = 1'-0"

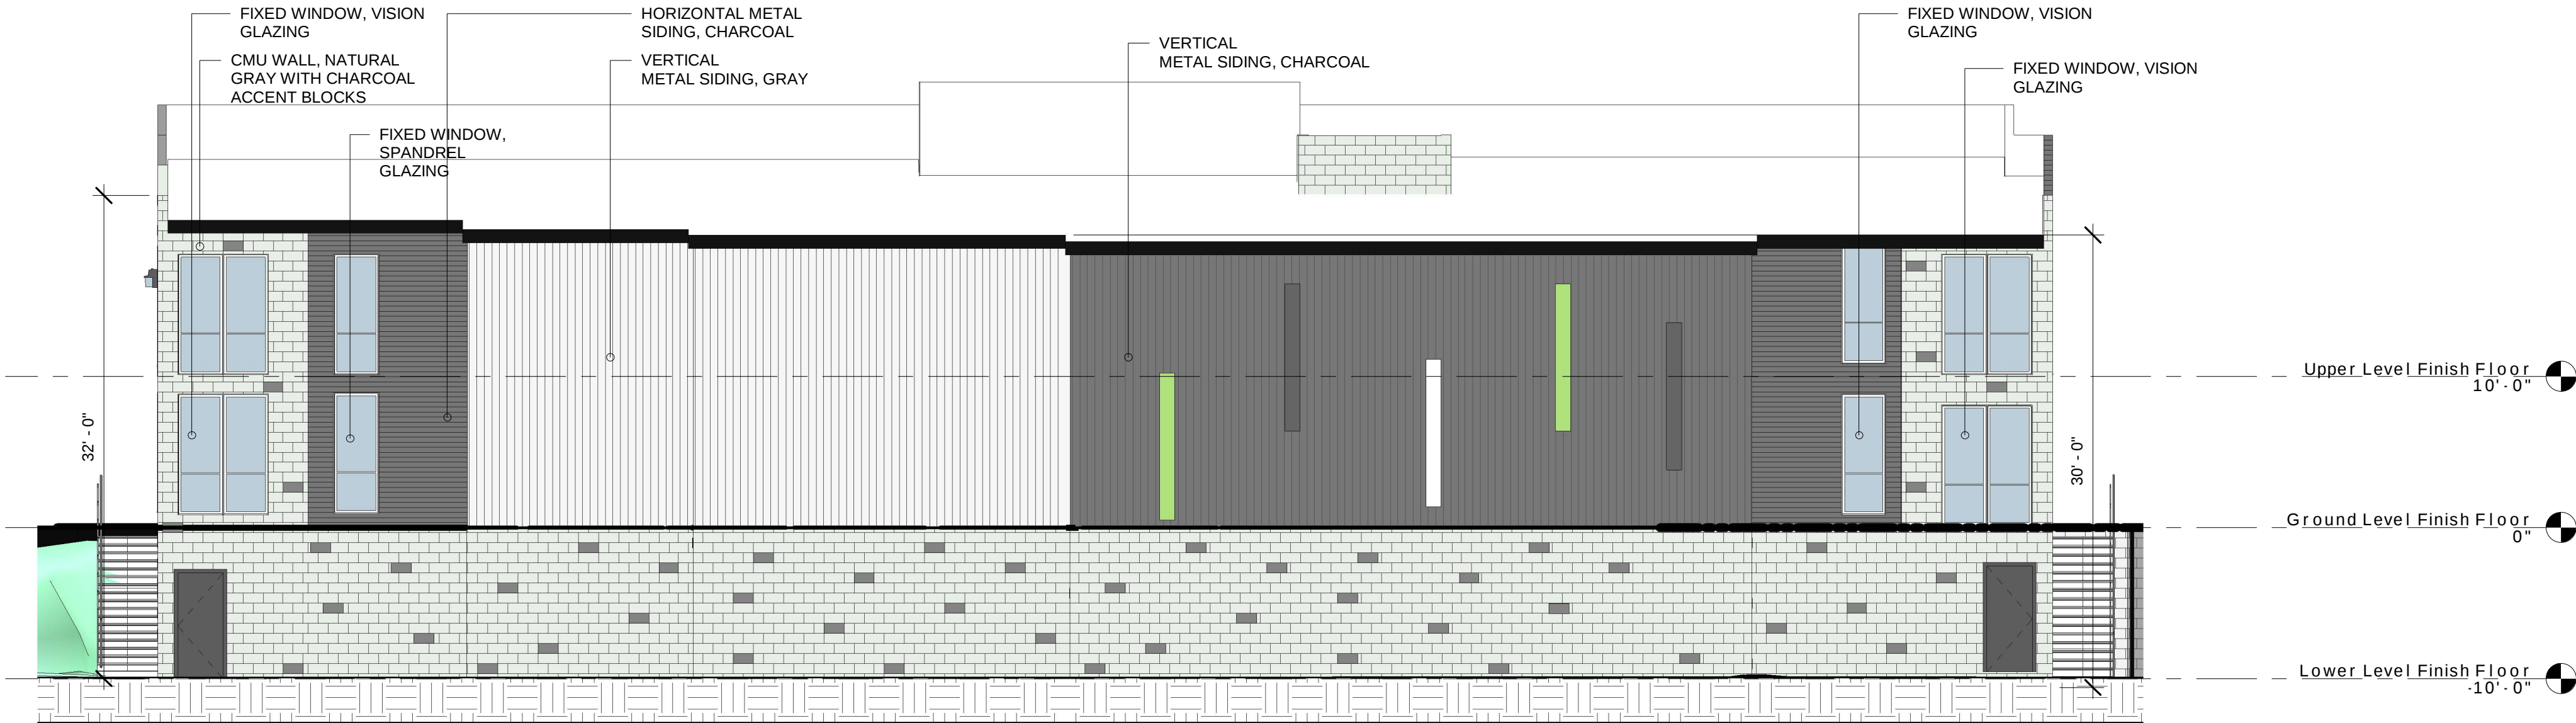


Buiding A Lot 2 South Elevation

Scale 1/8" = 1'-0"

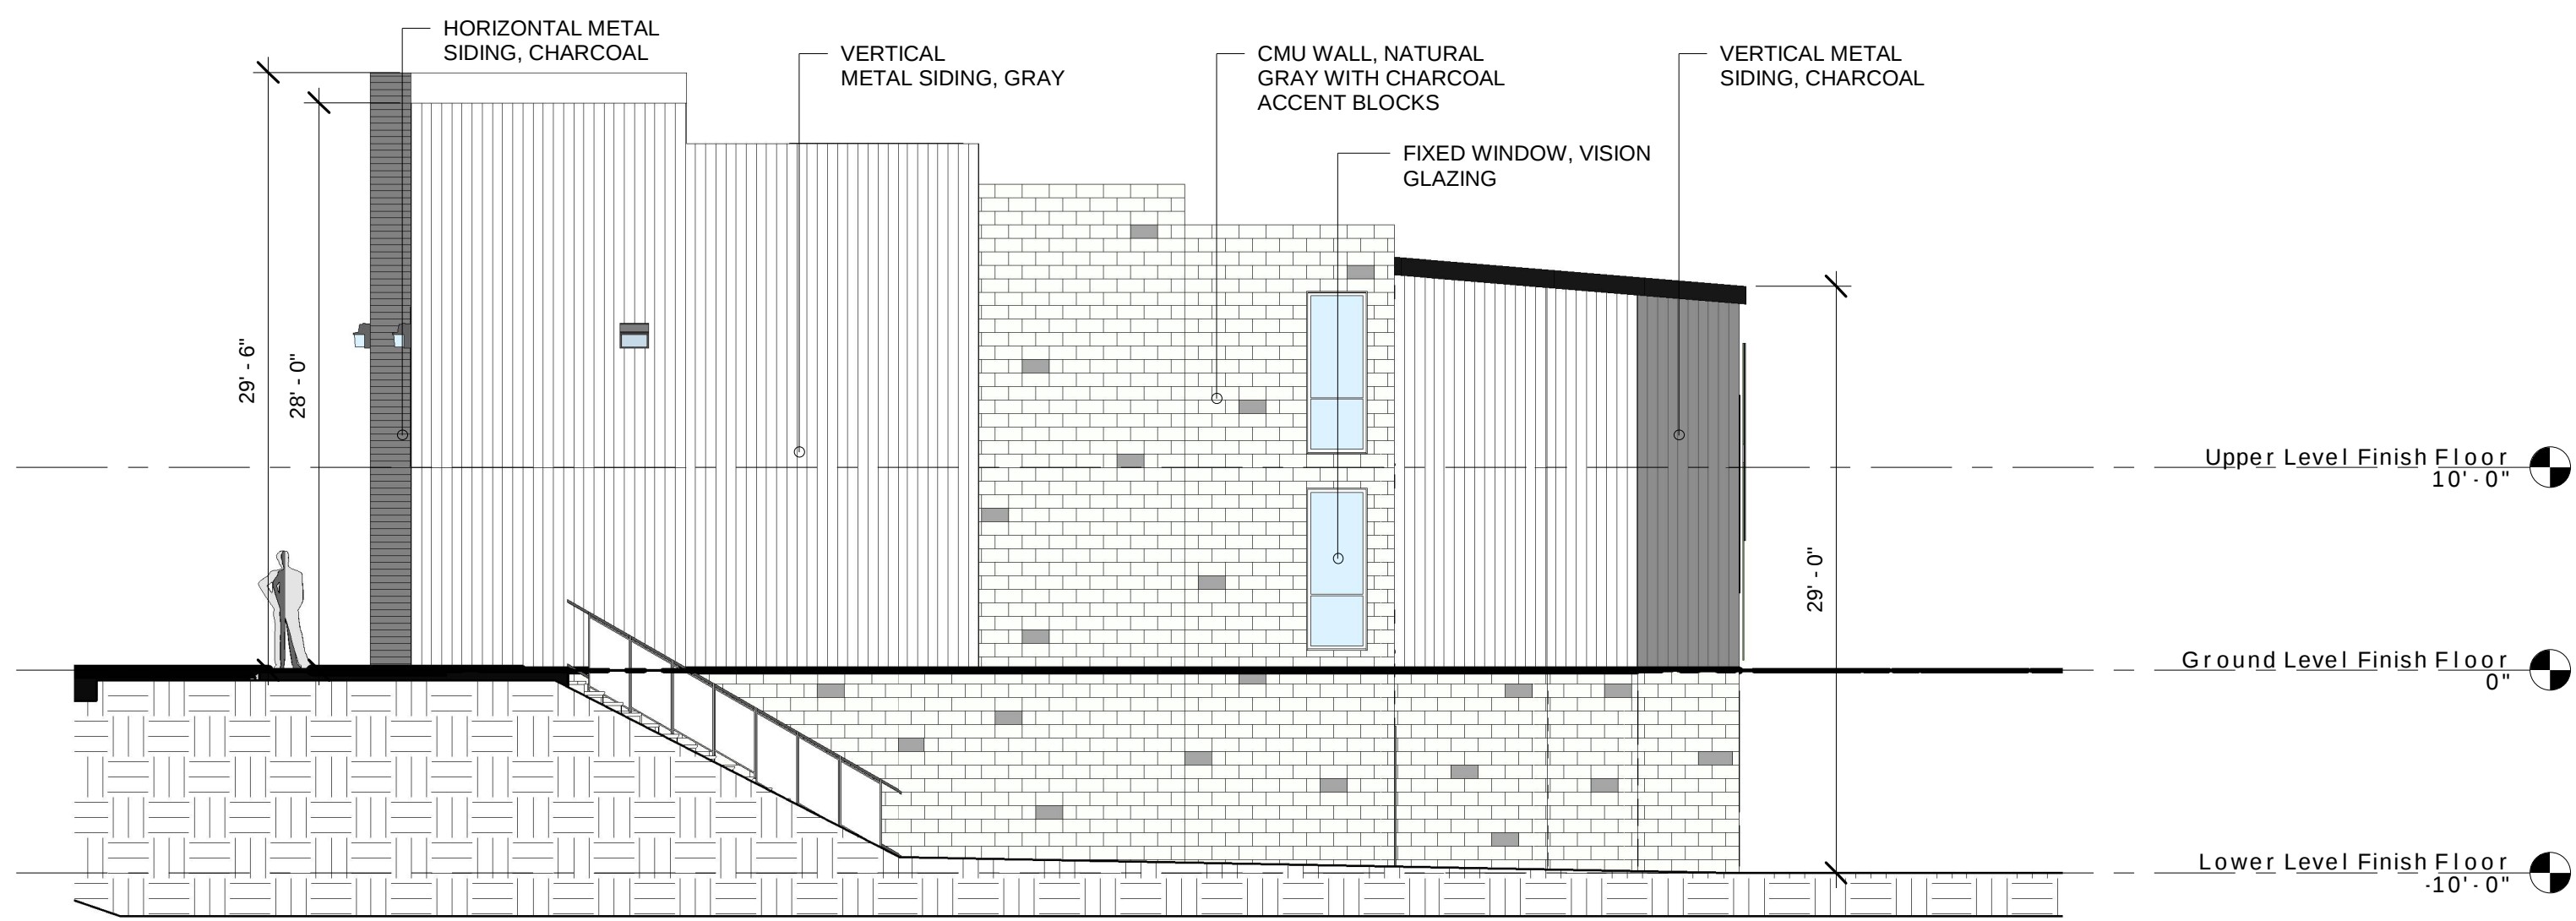


Buiding A Lot 2 West Elevation

Scale 1/8" = 1'-0"

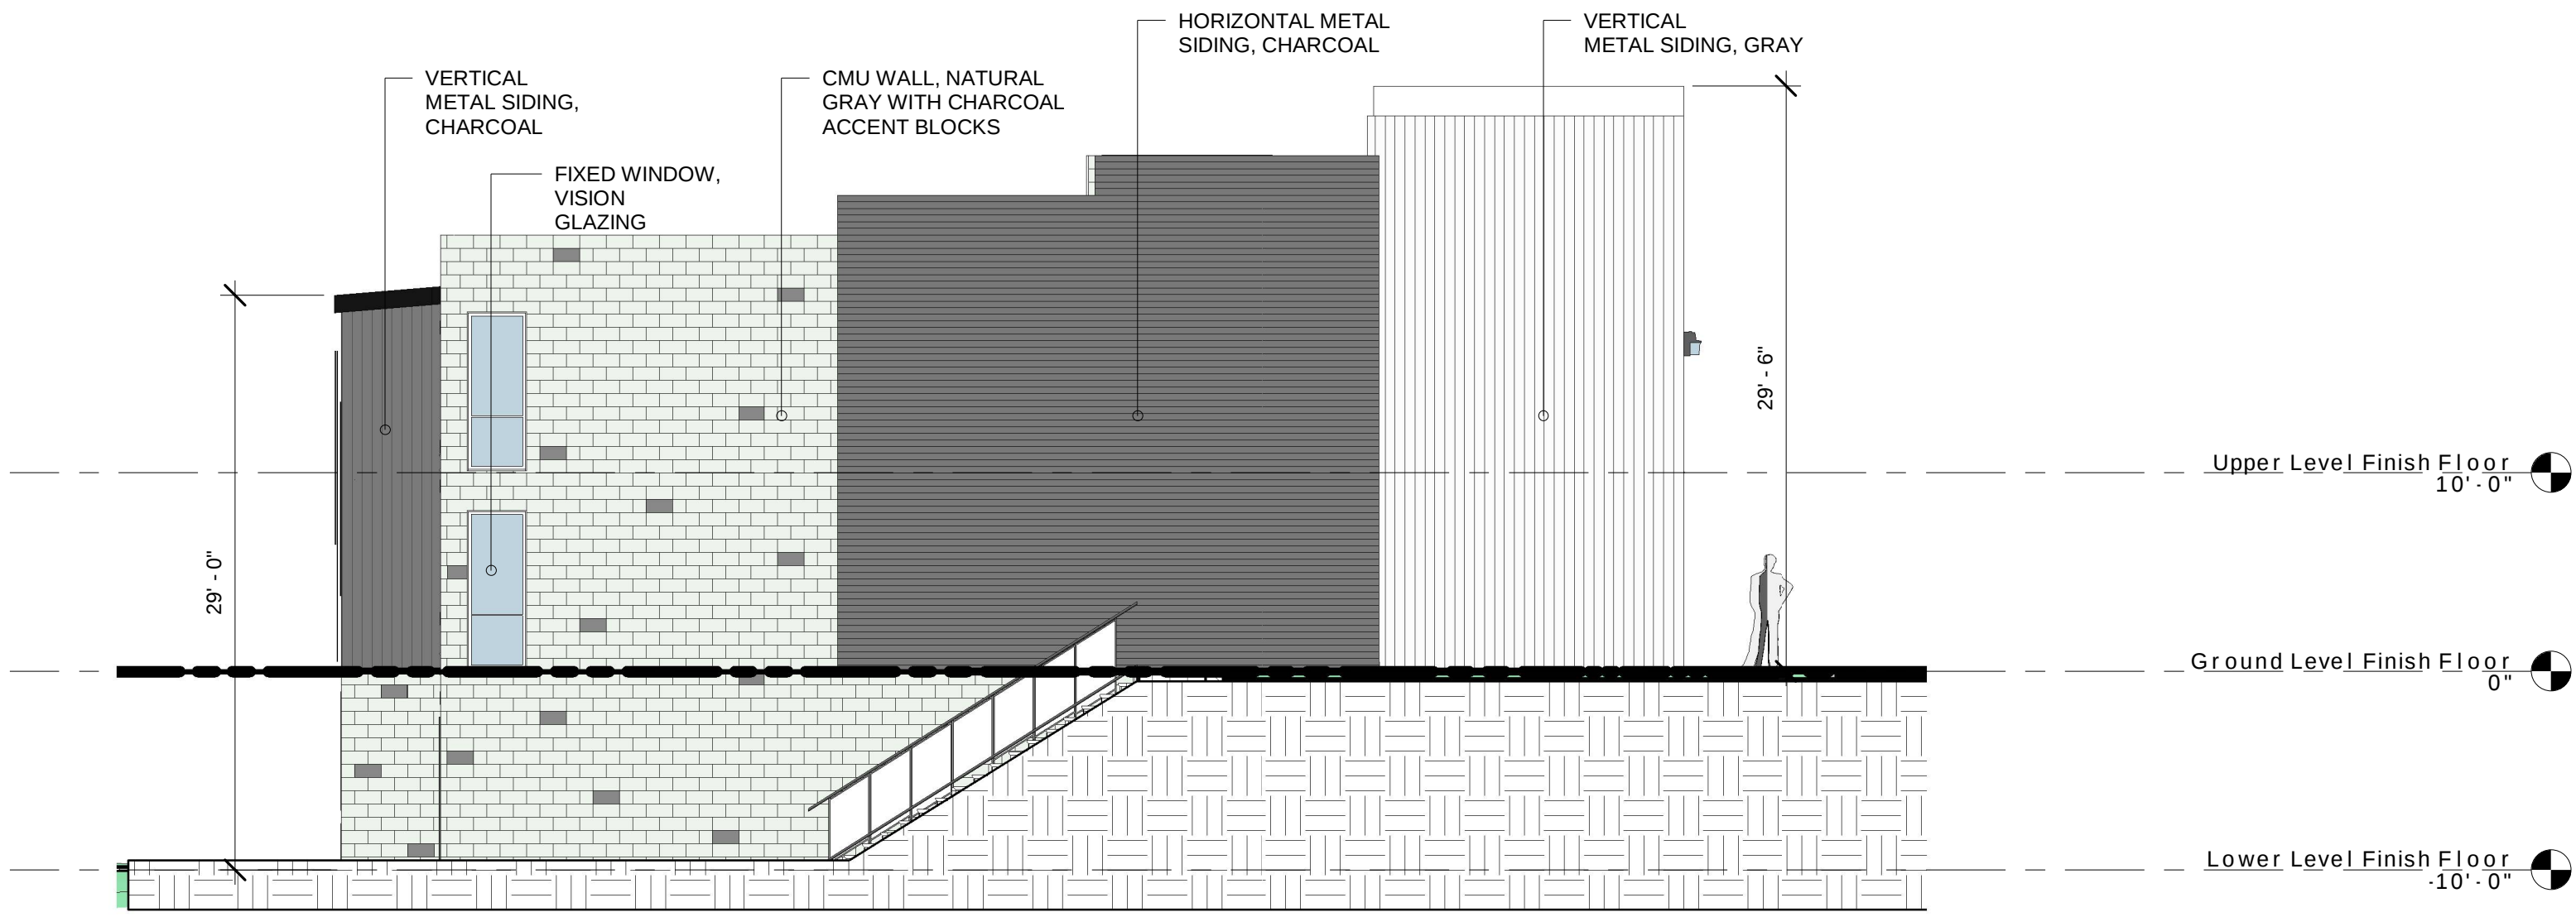


Buiding A Lot 2 East Elevation

Scale 1/8" = 1'-0"

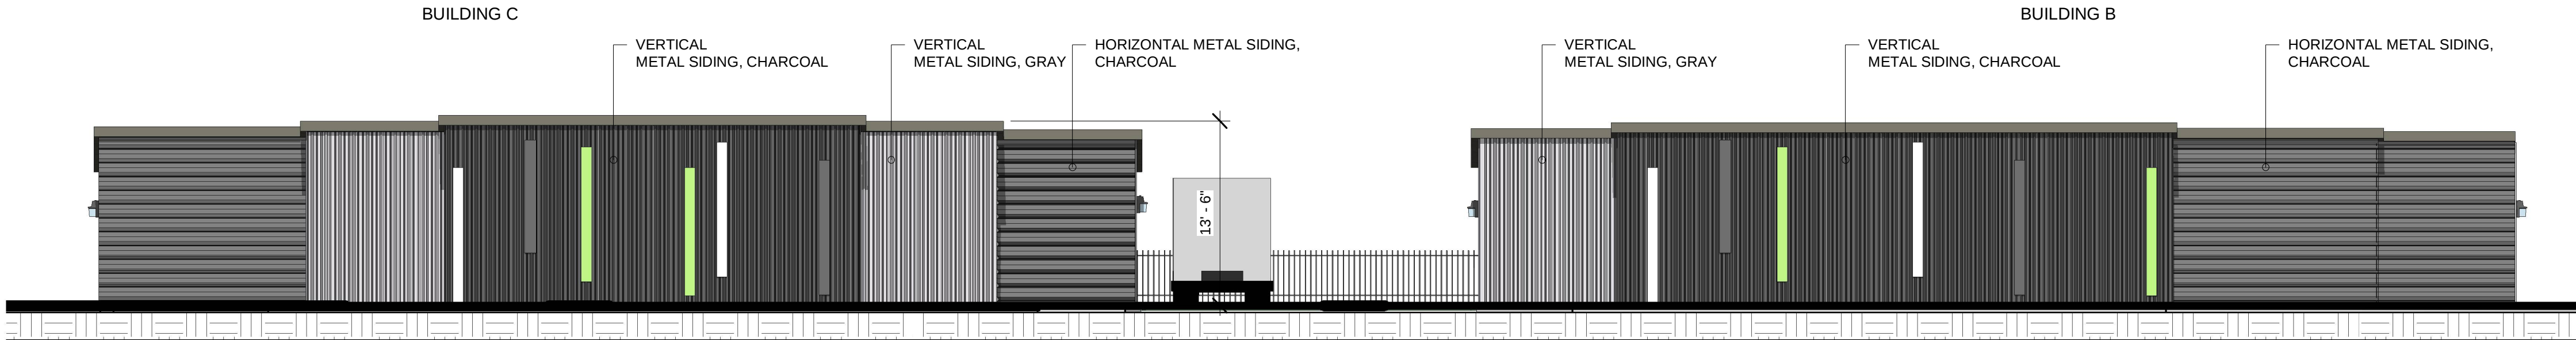


Building B and C Lot 3 North Elevation

Scale 1/8" = 1'-0"

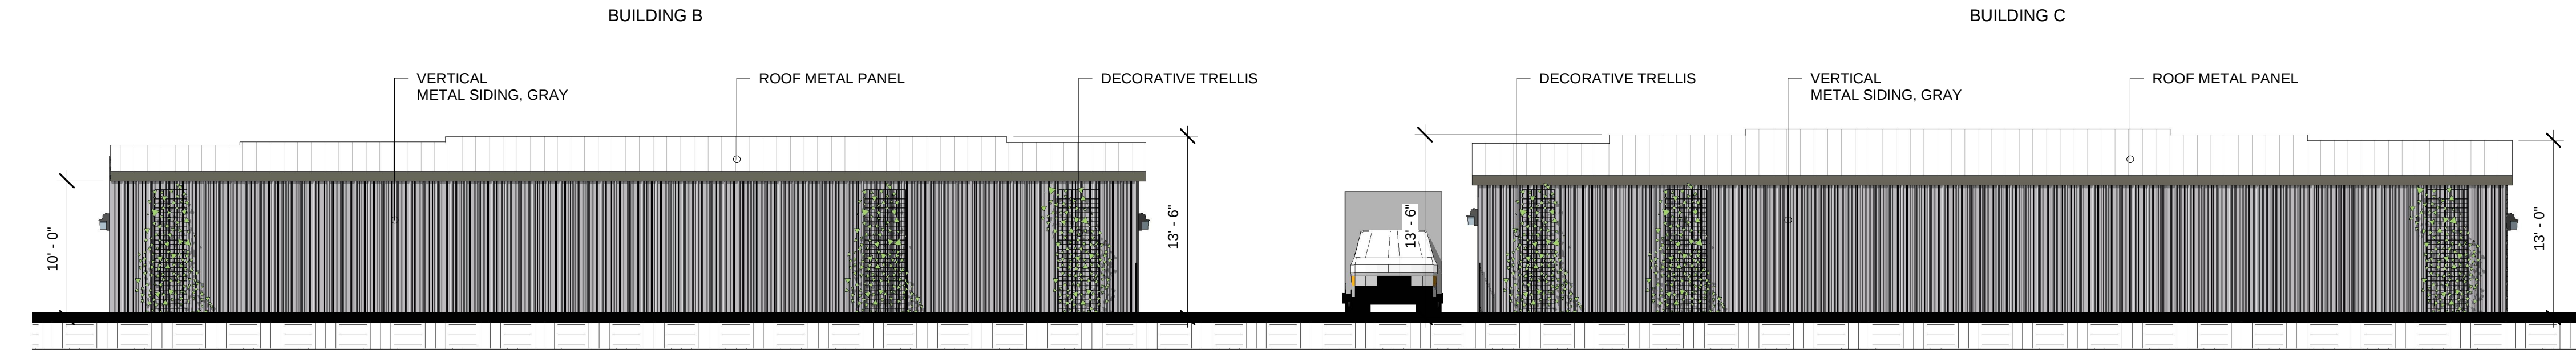


Building B and C Lot 3 South Elevation

Scale 1/8" = 1'-0"

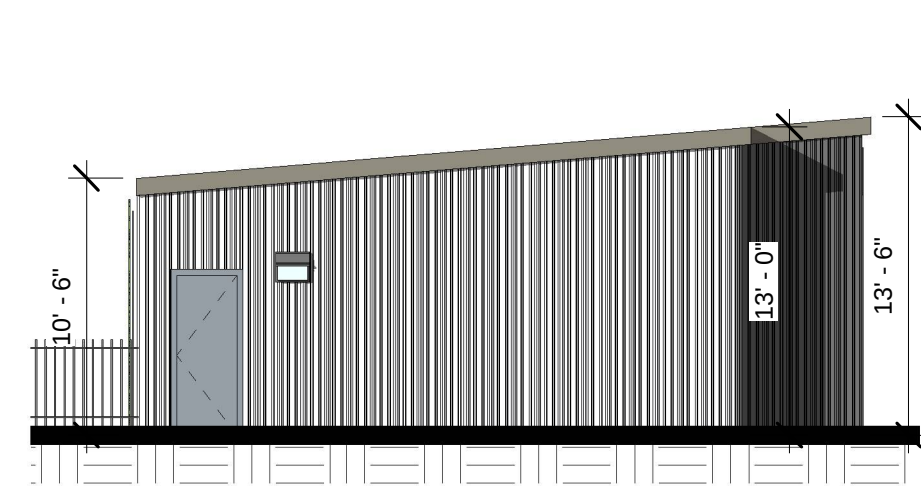


Building B Lot 3 East Elevation

Scale 1/8" = 1'-0"

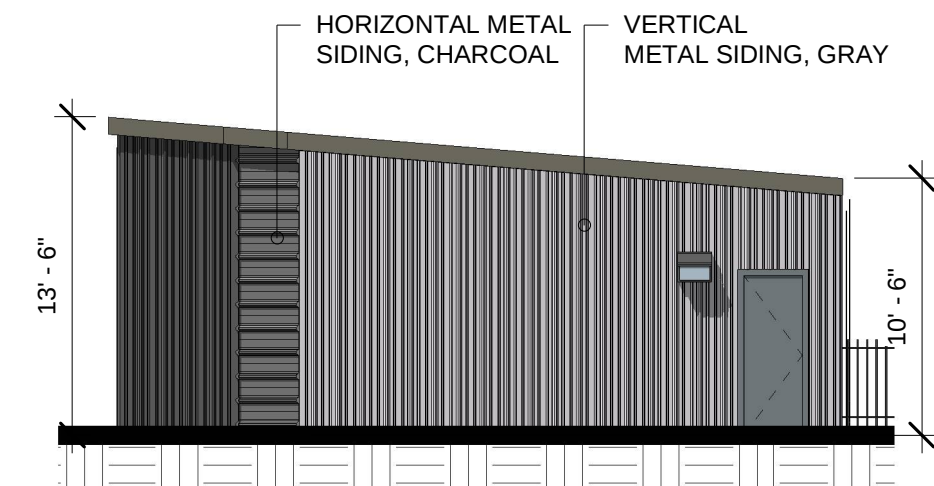


Building B Lot 3 West Elevation

Scale 1/8" = 1'-0"

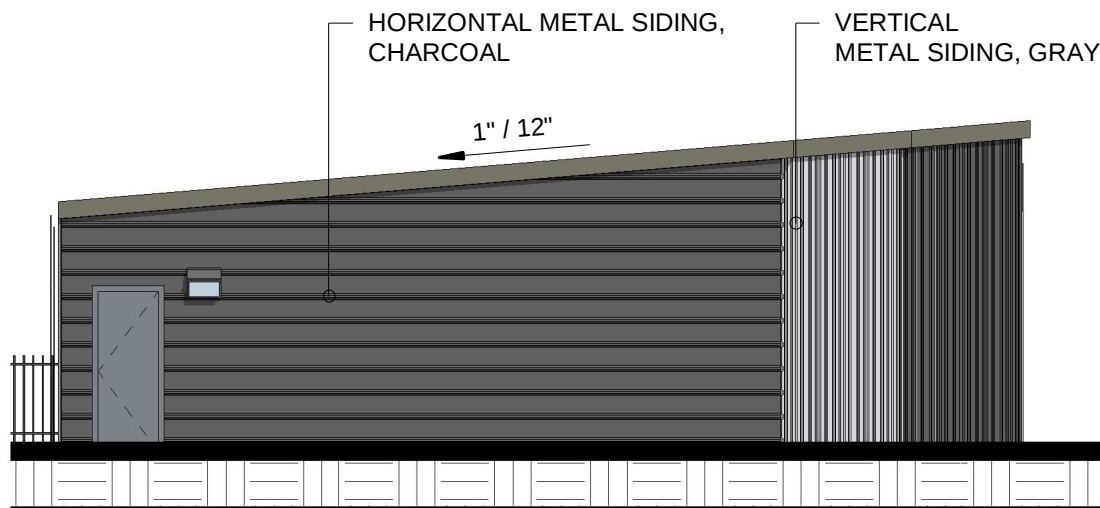


Building C Lot 3 East Elevation

Scale 1/8" = 1'-0"

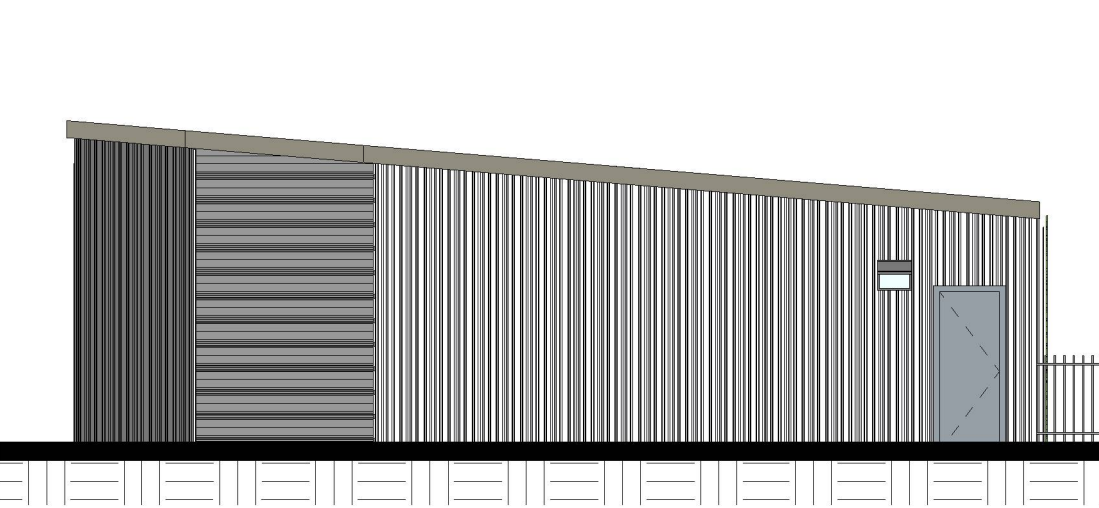


Building C Lot 3 West Elevation

Scale 1/8" = 1'-0"

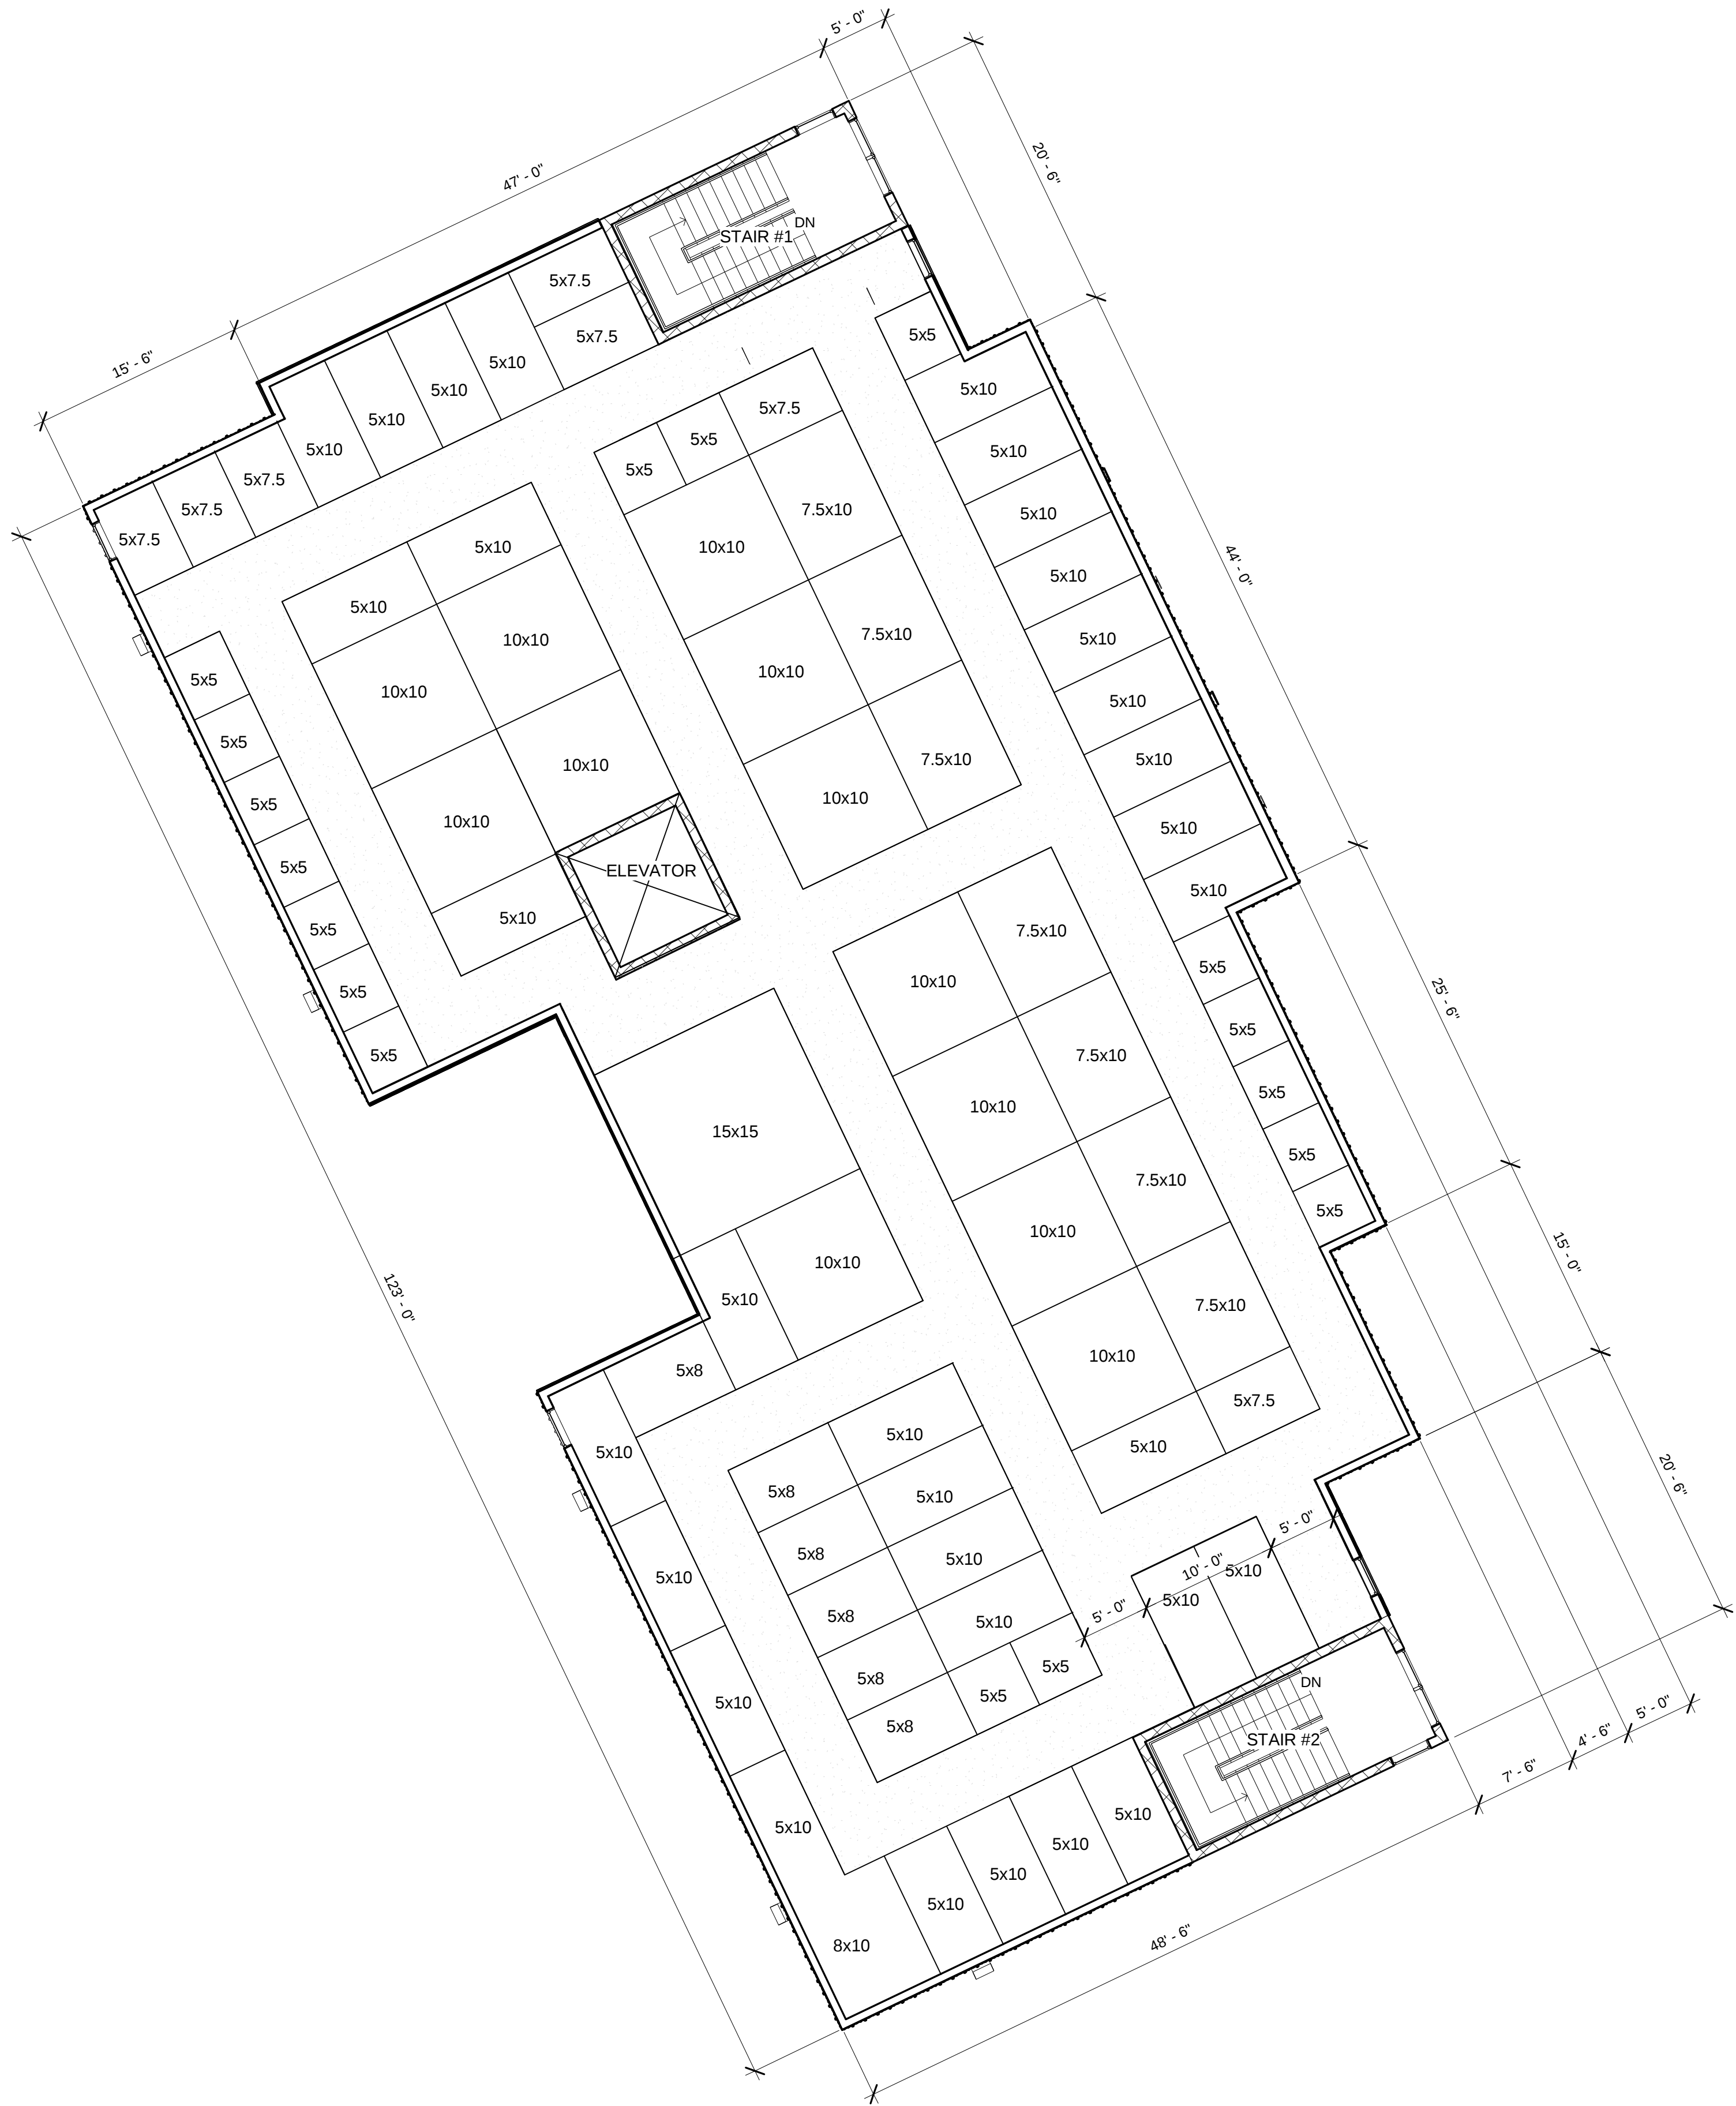

Building A LOT 2 Upper Level

Scale 1/8" = 1'-0"

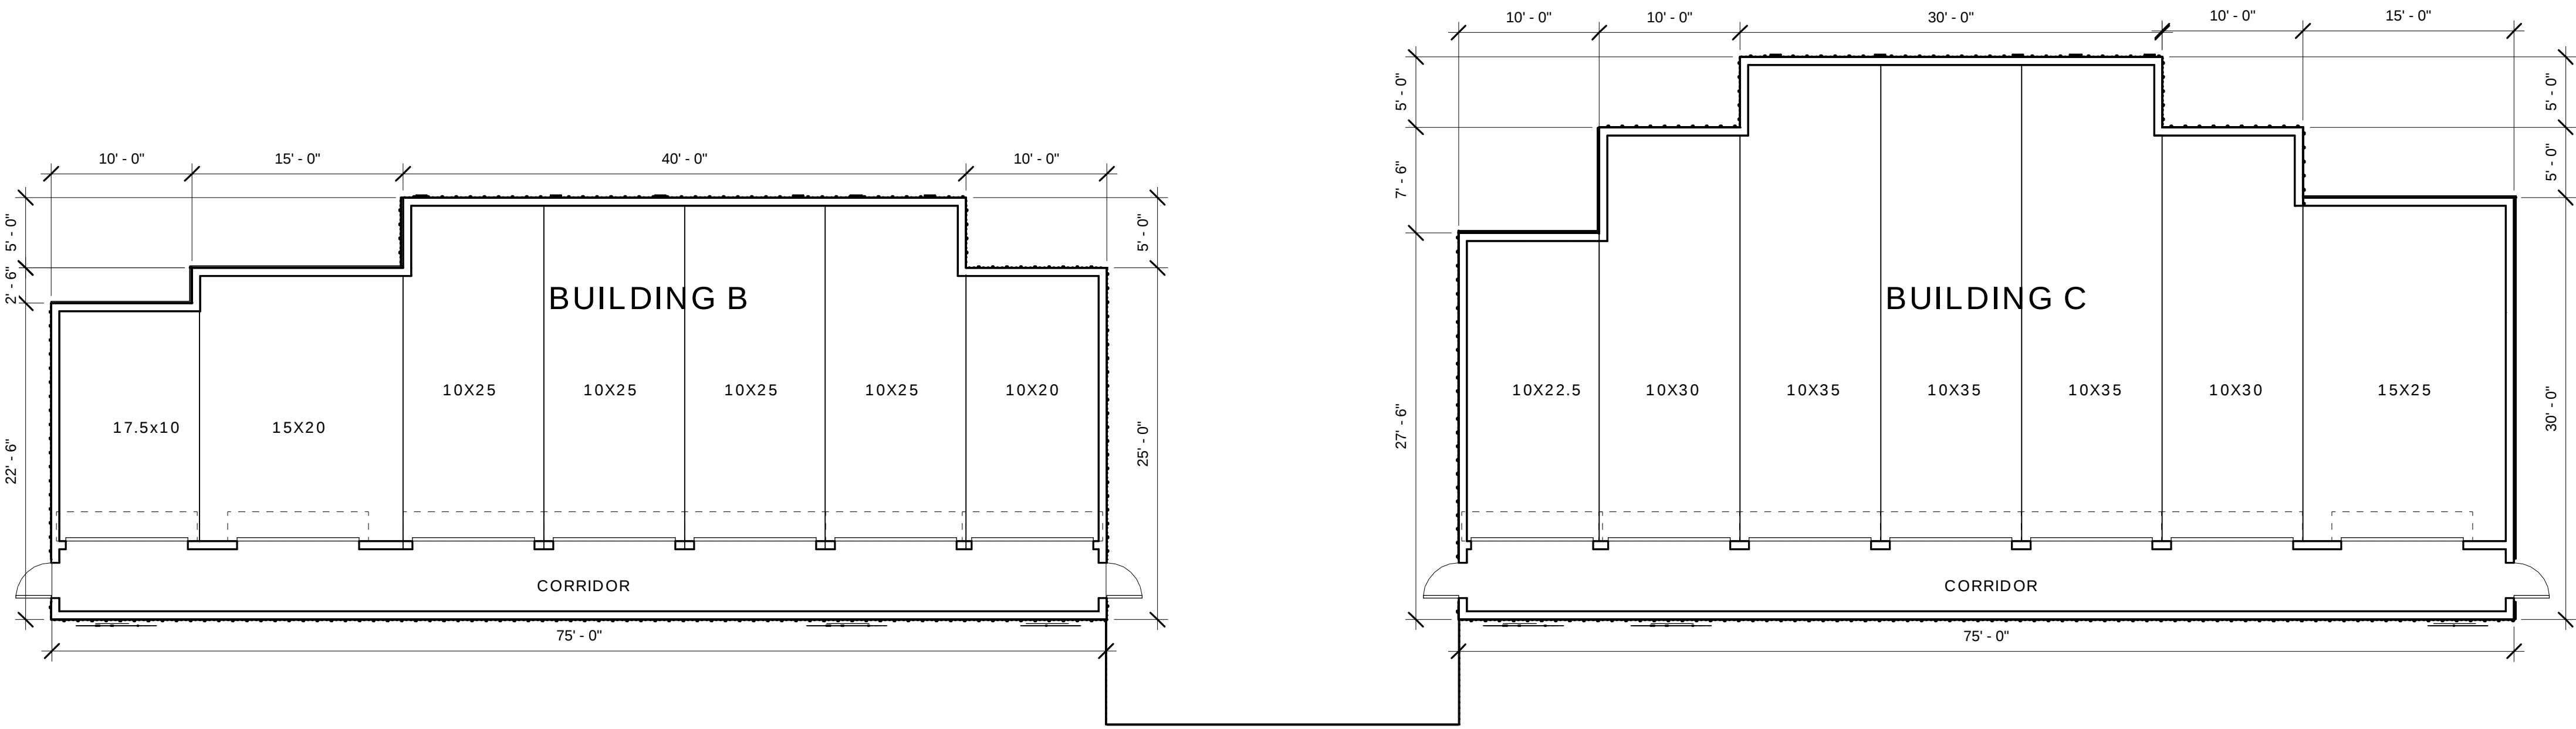


Building B and C LOT 3 Lower Level

Scale 1/8" = 1'-0"



  One Lithonia Way • Conyers, Georgia 30012 • Phone: 800.279.8041 • www.lithonia.com
© 2014 Acuity Brands Lighting, Inc. All rights reserved.



LITHONIA LIGHTING One Lithonia Way • Conyers, Georgia 30012 • Phone: 800.279.8041 • www.lithonia.com © 2012-2016 Aquity Brands Lighting, Inc. All rights reserved. DSXW Rev. 07/16 Room


LITHONIA
LIGHTING

One Lithonia Way • Conyers, Georgia 30012 • Phone: 800.279.8041 • www.lithonia.com
© 2012-2017 Acuity Brands Lighting, Inc. All rights reserved.

DS
Rev.
Pa



Rozella 2-Light Outdoor Wall Lantern

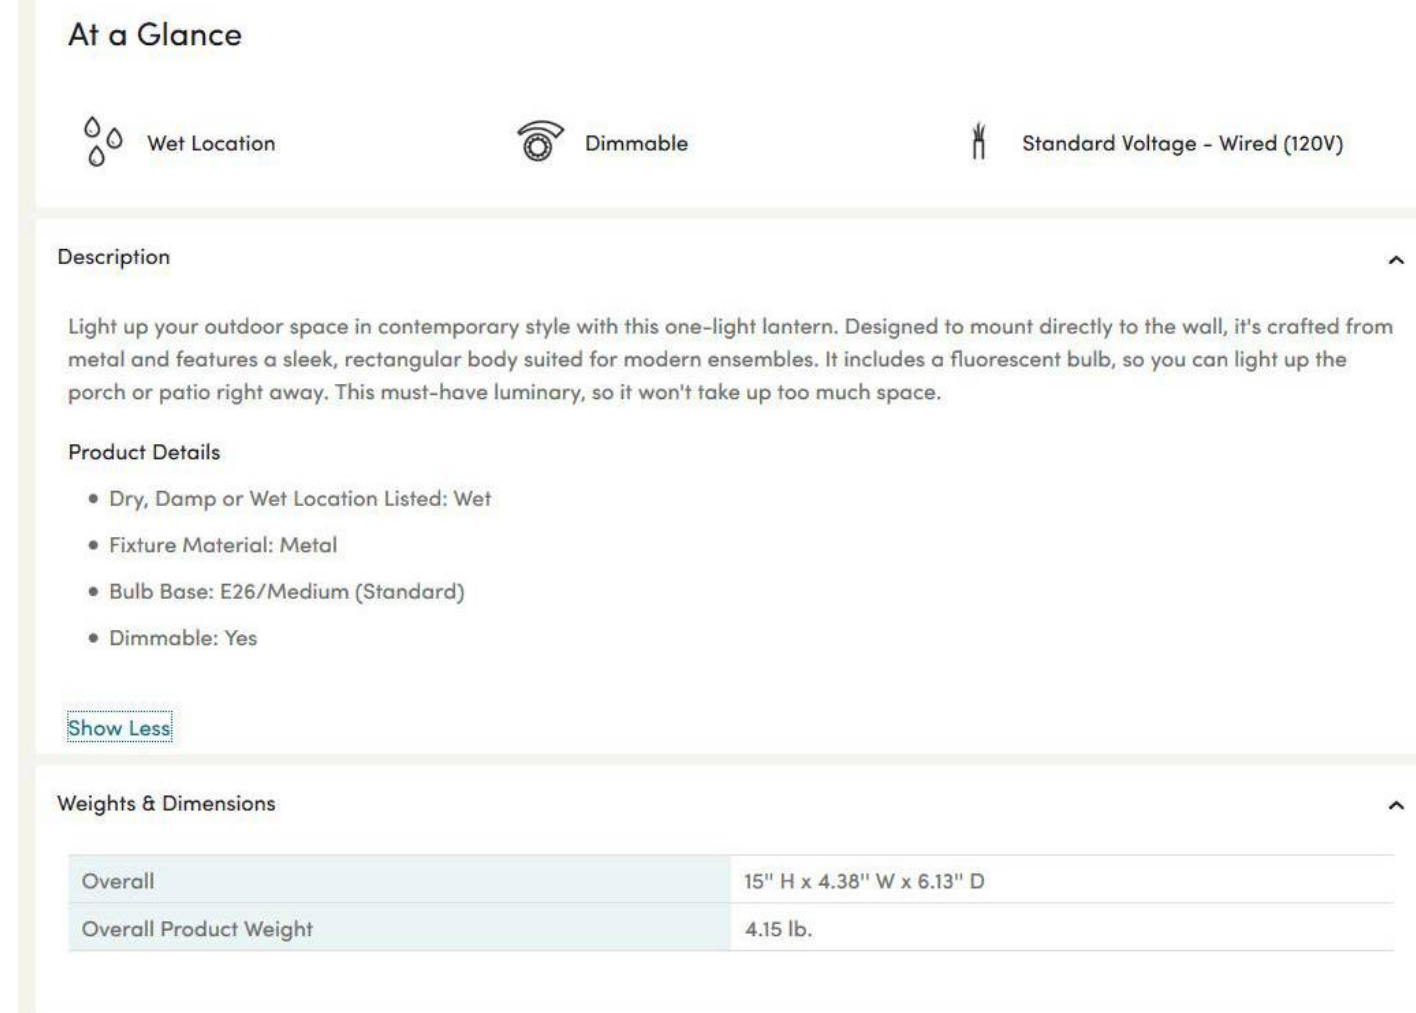

Features	
Lighting Type	Outdoor Wall Lantern
Dry, Damp or Wet Location Listed	Wet
Voltage	120 Volts
Fixture Shape	Square/Rectangle
Bulb Not Included but Required	Yes
Bulb Base	E26/Medium (Standard)
Number of Light Bulbs	2
Fixture Material	Metal
Dimmable	Yes
Light Direction	Down; Up
Maximum Wattage (per bulb)	75 Watts
Country of Origin	China
Specifications	
Commercial OR Residential Certifications	Yes
Dark Sky Compliant	Yes
Energy Star Compliant	Yes
Title 24 Compliant	Yes
UL Listed	Yes
What is UL Listed	The Underwriters Laboratories (UL) is an independent product safety certification organization that provides products with dry, damp, or wet location ratings.
cUL Listed	Yes



SCALE:
1" = 1'-0"

4465 & 4480 Streamside Dr
Santa Rosa, CA 95409
Sonoma County APN 032-010-005

DWG #

DR 1.1

ISSUED
FOR:

Feb. 2022	DESIGN REVIEW
DATE	DESCRIPTION



85 Keystone Avenue, Suite E
Reno, Nevada 89503
Tel (775) 813-6887

DRAWN BY: CRN
DESIGNED BY:
CHECKED BY:
SUBMITTED BY:

SCALE:
1" = 1'-0"

RECESS STORAGE



4465 & 4480 Streamside Dr
Santa Rosa, CA 95409
Sonoma County APN 032-010-005

SHEET CONTENT

Site Lighting Plan

Lighting Fixtures Cut Sheet

DR 1.1

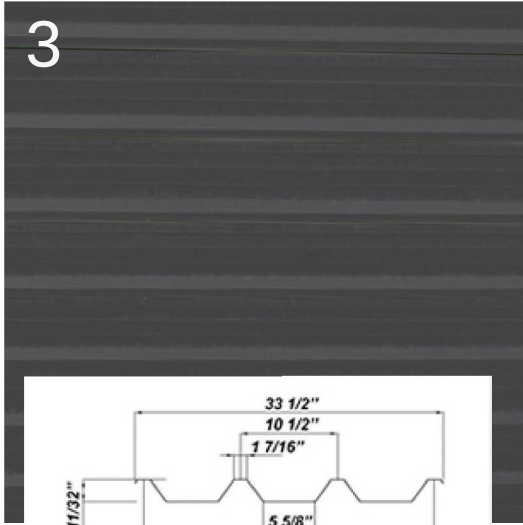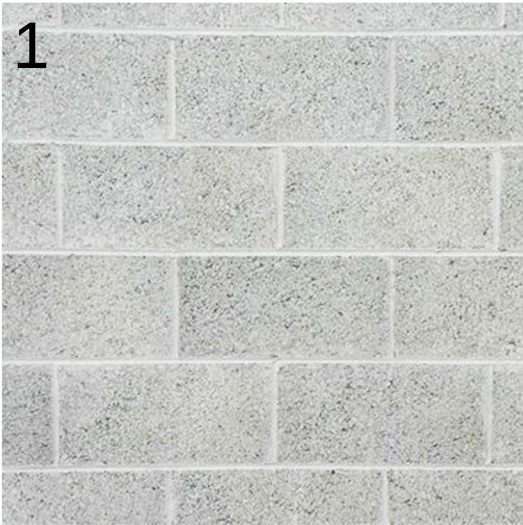

STORAGE EXTERIOR LIGHT FIXTURES - OR
EQUAL




OLWX1 LED
LED Wall Luminaire



Specifications

Width: 7-1/2" (19 cm)
Height: 8" (20.3 cm)
Depth: 3" (7.62 cm)
Weight: 5 lbs (2.27 kg)

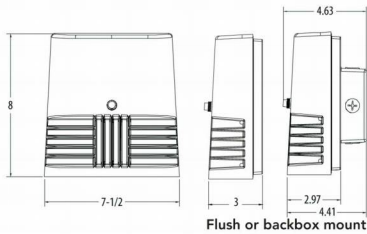

D-Series Size 2
LED Wall Luminaire



d"series

Specifications
Luminaire

 
Width: 18-1/2" (47.0 cm)
Depth: 10" (25.4 cm)
Height: 7-5/8" (19.4 cm)

Weight: 21 lbs (9.5 kg)

Back Box (BBW)

Width: 5-1/2" (14.0 cm)
Depth: 1-1/2" (3.8 cm)
Height: 4" (10.2 cm)


BBW Weight: 1 lbs (0.5 kg)



3. DECORATIVE,
METAL SIDING,
CHARCOAL

4. VERTICAL METAL SIDING, GRAY

8. 8'-4" X 7'-4" JANUS
ROLL-UP
METAL DOOR

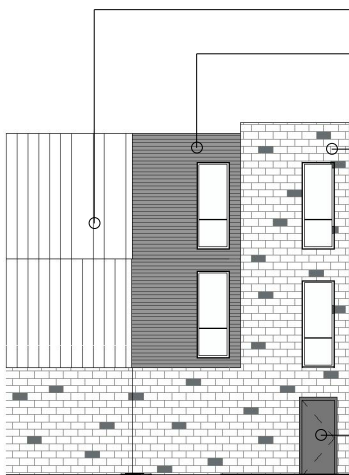

4. VERTICAL METAL SIDING, GRAY

3. HORIZONTAL METAL SIDING,
CHARCOAL

1. CMU WALL, NATURAL GRAY WITH
CHARCOAL ACCENT BLOCKS (2)

6. 3'-6" X 7'-0" METAL DOOR,
PAINTED, CHARCOAL

ISSUED FOR:	14 Aug. 2021	DESIGN REVIEW
	DATE	DESCRIPTION



ARECESS

85 Keystone Avenue, Suite E
Reno, Nevada 89503
Tel (775) 813-6887

SELF STORAGE and RESIDENTIAL COMPLEX

4465 & 4480 Streamside Dr
Santa Rosa, CA 95409
Sonoma County APN 032-010-005

DWG #

Materials
Storage