

RECEIVED
By E07081 at 7:13 am, Feb 09, 2021

NOT FOR CONSTRUCTION
FOR REVIEW ONLY

WEST COAST SELF STORAGE
GROUP
808 134TH ST SW, BLDG.B, STE 211
EVERETT WA, 98204

WCSS - SANTA ROSA
970 PINER RD,
SANTA ROSA, CA 95404

DATE	NO.	DESCRIPTION
02/05/2021	1	SITE PLAN PHOTOMETRICS

PROJECT NO.: 20143
PROJECT MGR.: MS
DRAWN BY: JO
CHECKED BY: MJ

SITE PLAN
PHOTOMETRICS

E1.1

SYMBOLS LIST


- LIGHTING FIXTURE SUBSCRIPTS:
A = FIXTURE TAG, SEE LIGHT FIXTURE SCHEDULE
- Q WALL-MOUNTED FIXTURE
P PENDANT MOUNTED FIXTURE
I IN-GRADE FIXTURE
1 KEY NOTE

KEY NOTES

- MOUNT LIGHT FIXTURE AT 9' AFF
- MOUNT LIGHT FIXTURE AT 14' AFF
- PENDANT FIXTURE AT 16' AFF

LIGHTING FIXTURE SCHEDULE

TYPE	MANUFACTURER AND MODEL	DESCRIPTION	LAMP TYPE	WATTS PER FIXTURE	VOLTAGE
A1	LSI INDUSTRIES LED PARTIOT SERIES # XPW53-F1-LED-48-350ma-NW-UE	LED WALL SCONCE, FORWARD THROW DISTRIBUTION, BUG RATING B1-U0-G1, CONFIRM FINISH WITH ARCHITECT	LED 4000K 4863LM	55	120
A2	LSI INDUSTRIES LED PARTIOT SERIES # XPW53-W1-LED-48-350ma-NW-UE	SAME AS FIXTURE TYPE A1 EXCEPT WIDE THROW DISTRIBUTION	LED 4000K 4781LM	55	120
B	LSI INDUSTRIES EXCLUSION (EXN) SERIES # EXN-H-50LED-8L-T5N-T5WU-UVV-DIM-40-70CRI	LED PENDANT MOUNT FIXTURE WITH UP AND DOWN LIGHTING COMPONENTS, TYPE V NARROW DOWNLIGHT DISTRIBUTION AND TYPE V WIDE UPLIGHT DISTRIBUTION, 0-10V DIMMING DRIVER, CONFIRM FINISH WITH ARCHITECT	LED 4000K 8810LM	60	120
C	KIM LIGHTING LIGHTVAULT 8 EYE BALL # LTV82EB-WW-12L-3K-UV-ROA82	LED IN GRADE LIGHT FIXTURE, WALL WASH DISTRIBUTION, 59.4 DEGREES BEAM ANGLE	LED 3000K 1198LM	15	120

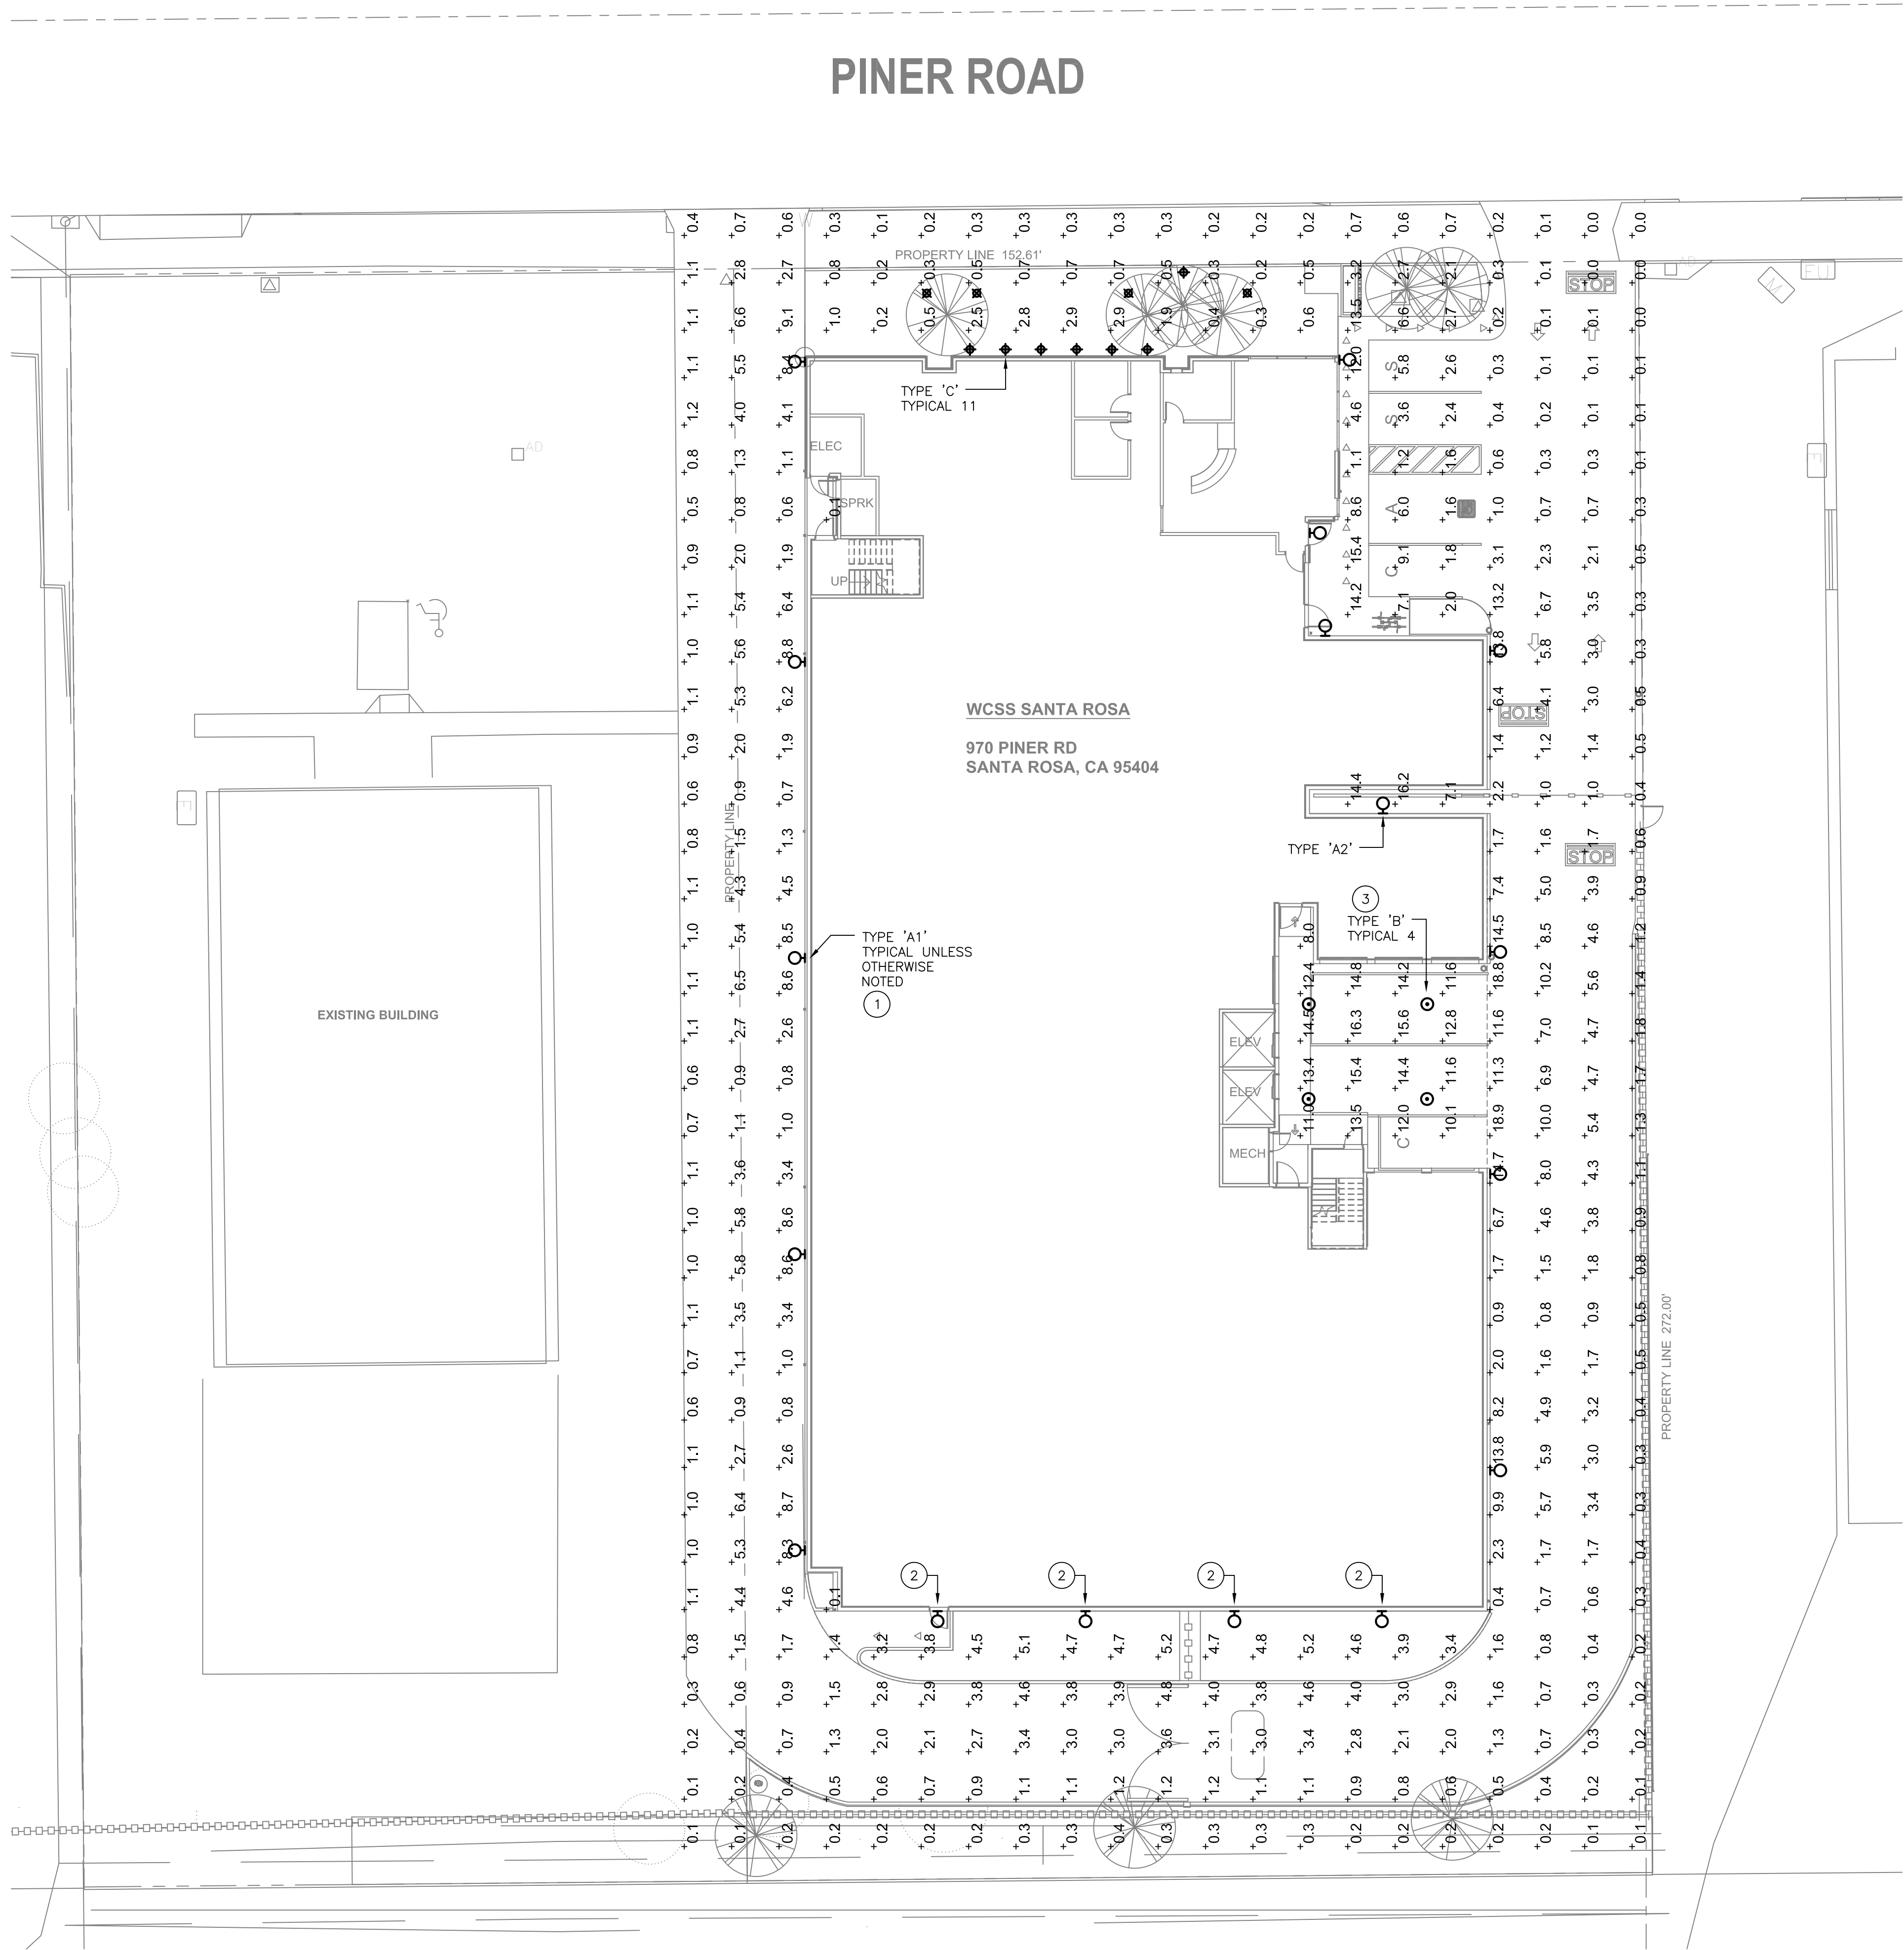

SITE PLAN PHOTOMETRICS

SCALE: 1/16"=1'-0"

1