


① BUILDING 'B' FLOOR PLAN  
1/8" = 1'-0"




② BUILDING 'A' FLOOR PLAN  
1/8" = 1'-0"


0 4' 8'  
SCALE: 1/8" = 1'-0"

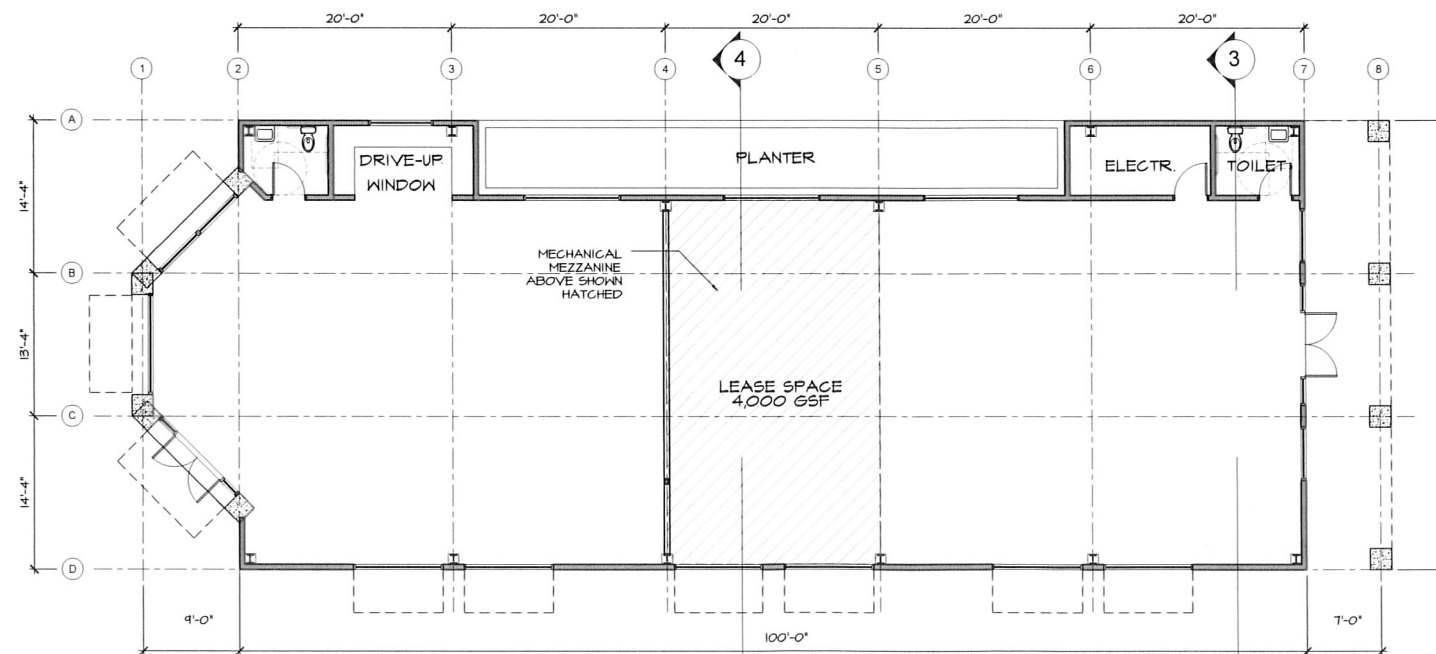

COLLEGE STATION  
FLOOR PLANS

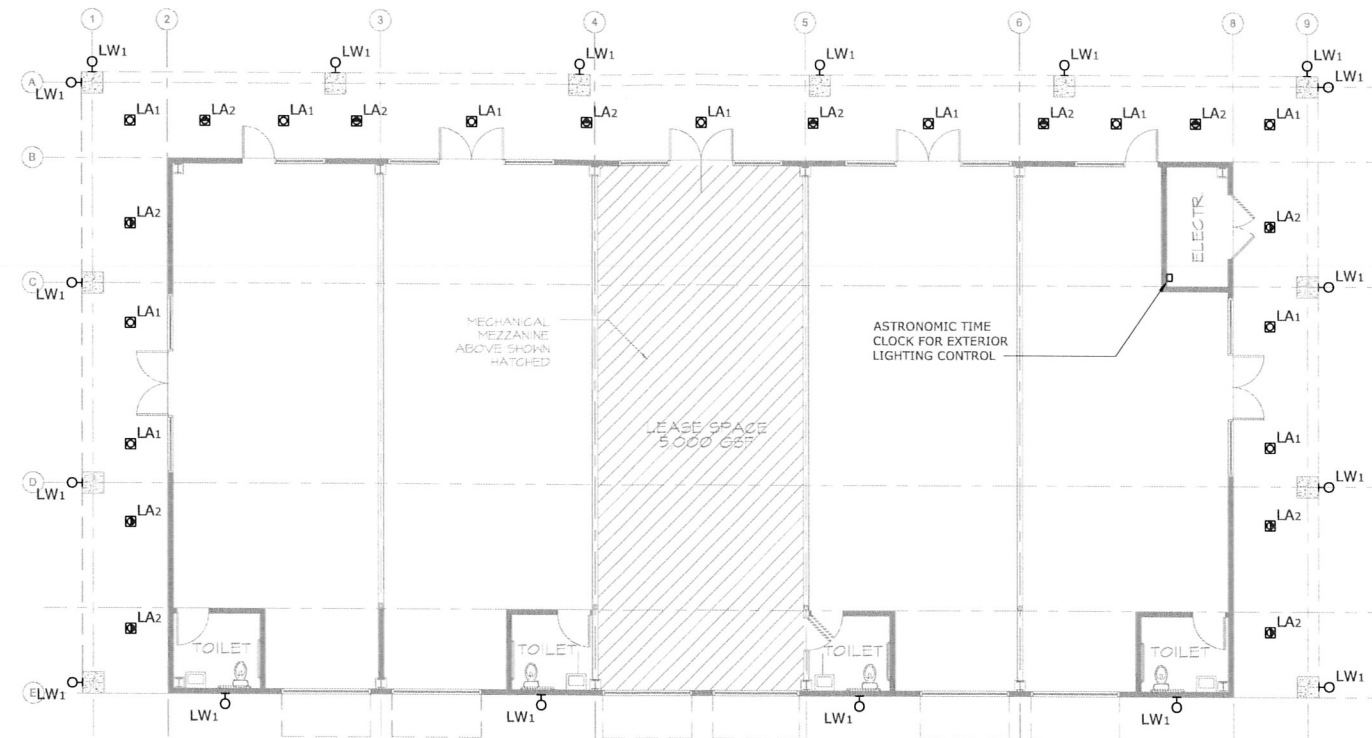

① BUILDING 'B' FLOOR PLAN  
1/8" = 1'-0"

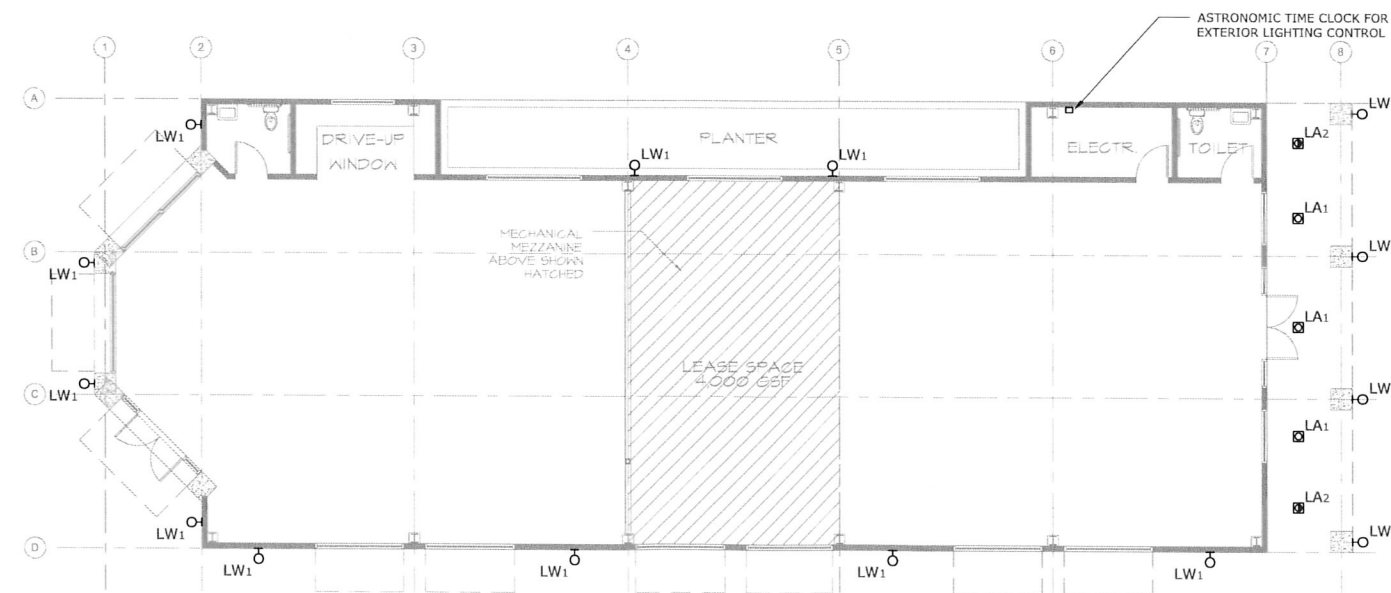


② BUILDING 'A' FLOOR PLAN  
1/8" = 1'-0"




6 WEST COLLEGE AVENUE SHOPPING CENTER  
FLOOR PLANS - EXTERIOR LIGHTING




4/22/2016

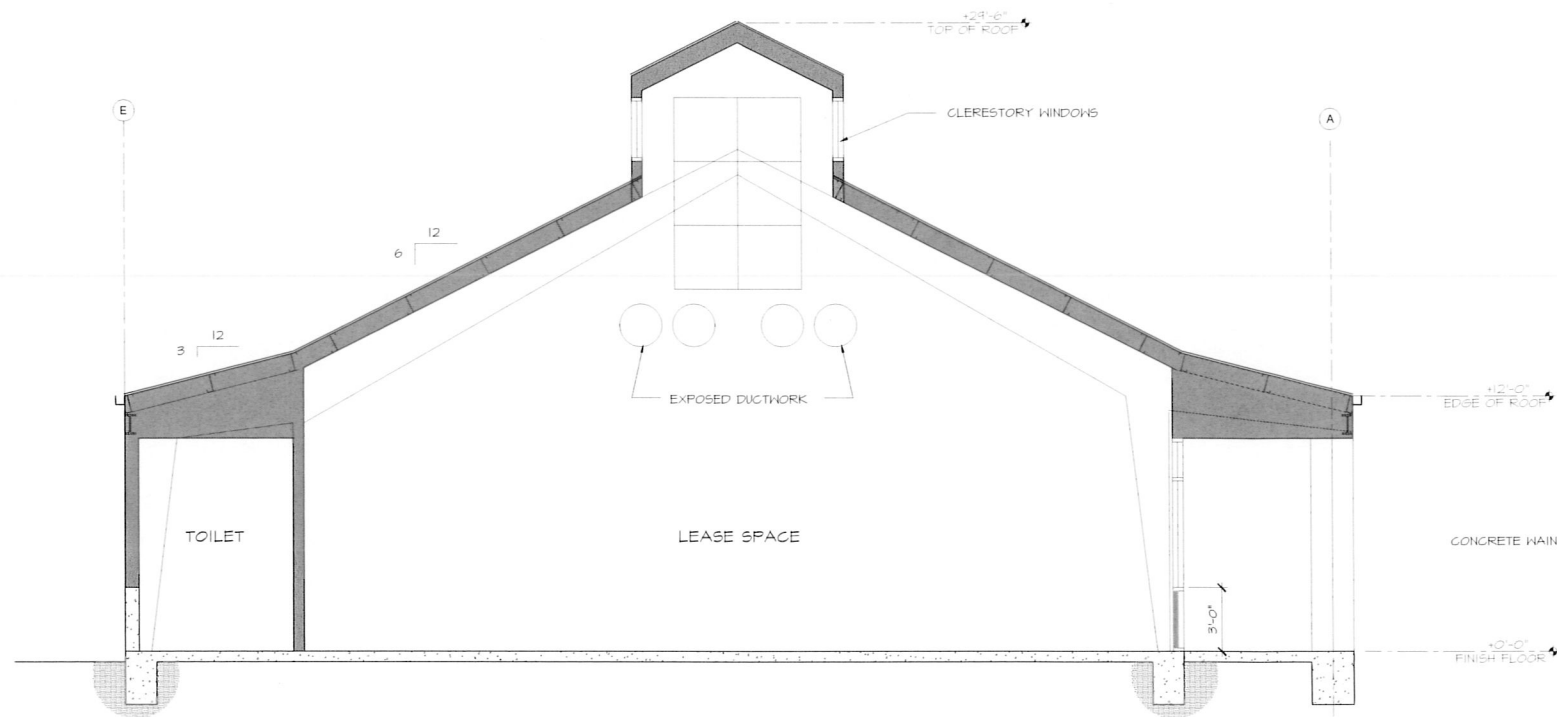


1 BUILDING 'B' SECTION  
1/4" = 1'-0"

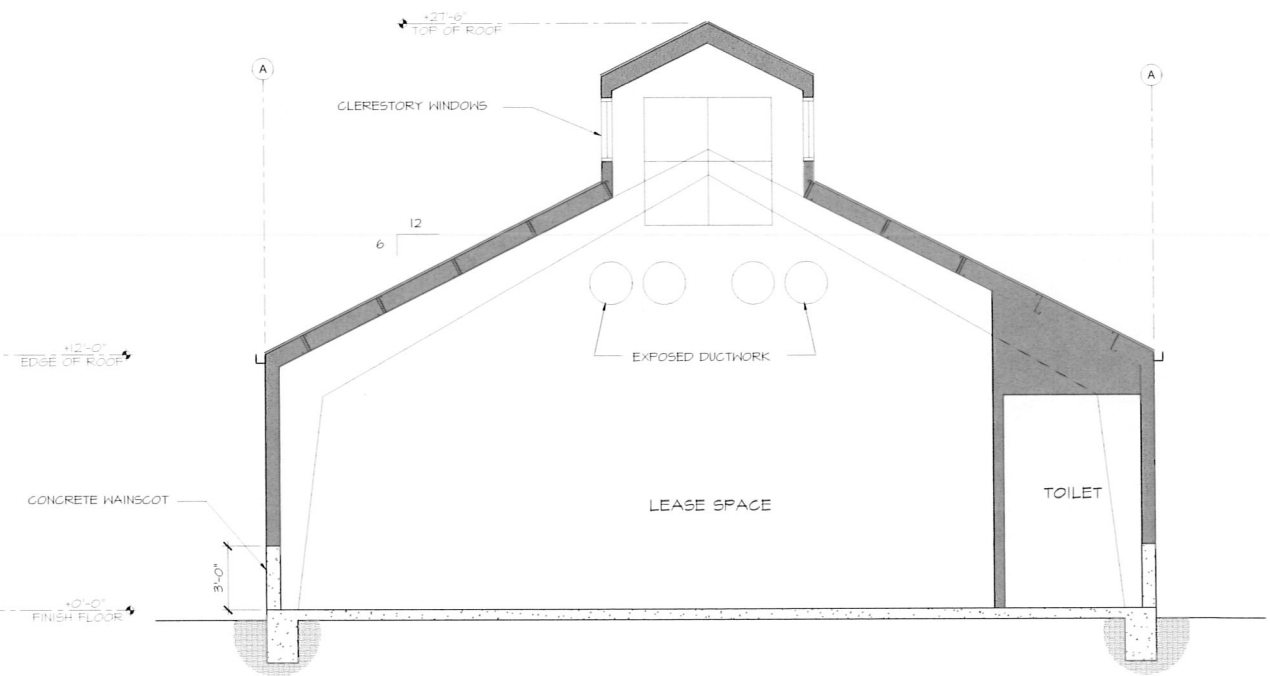




3 BUILDING 'A' SECTION  
1/4" = 1'-0"

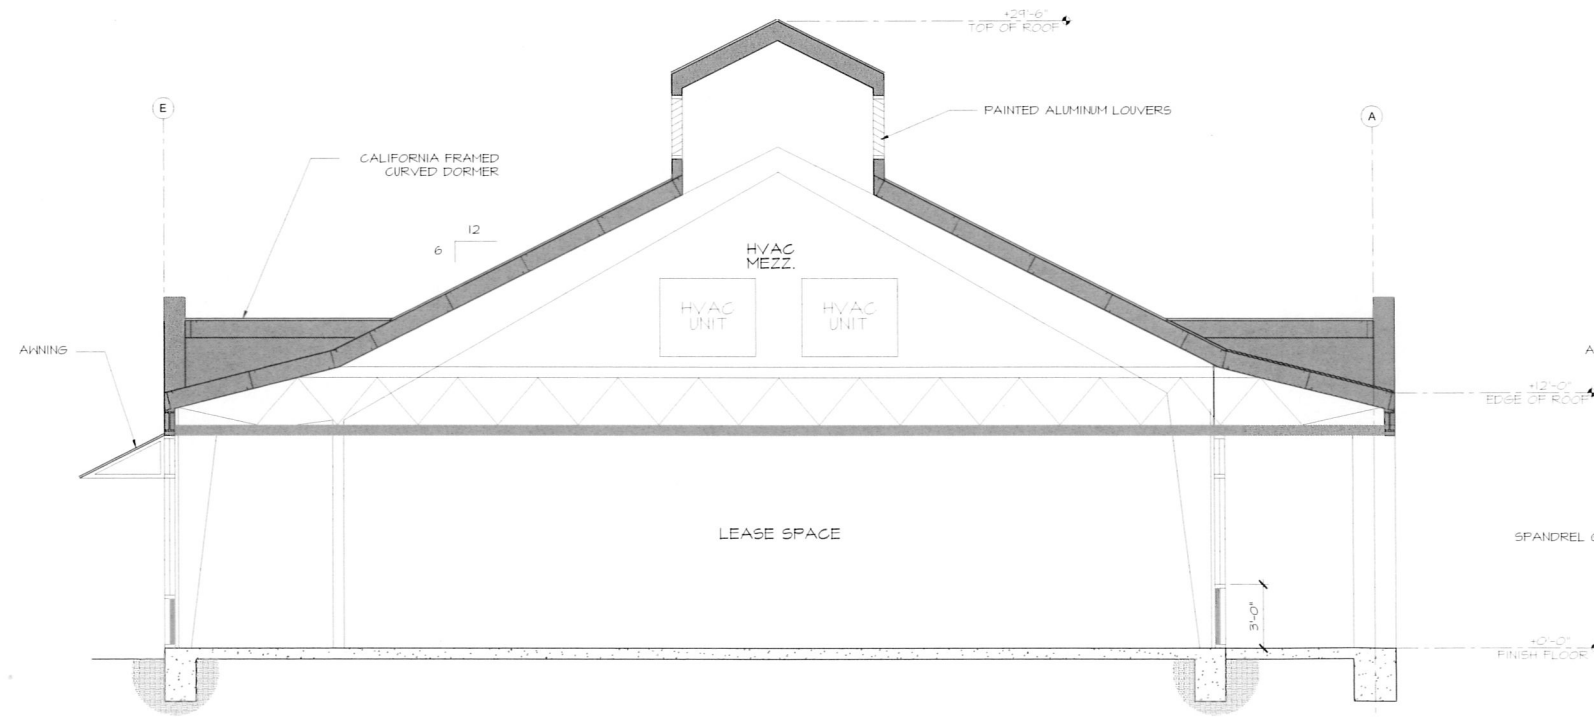

2 BUILDING 'B' SECTION  
1/4" = 1'-0"

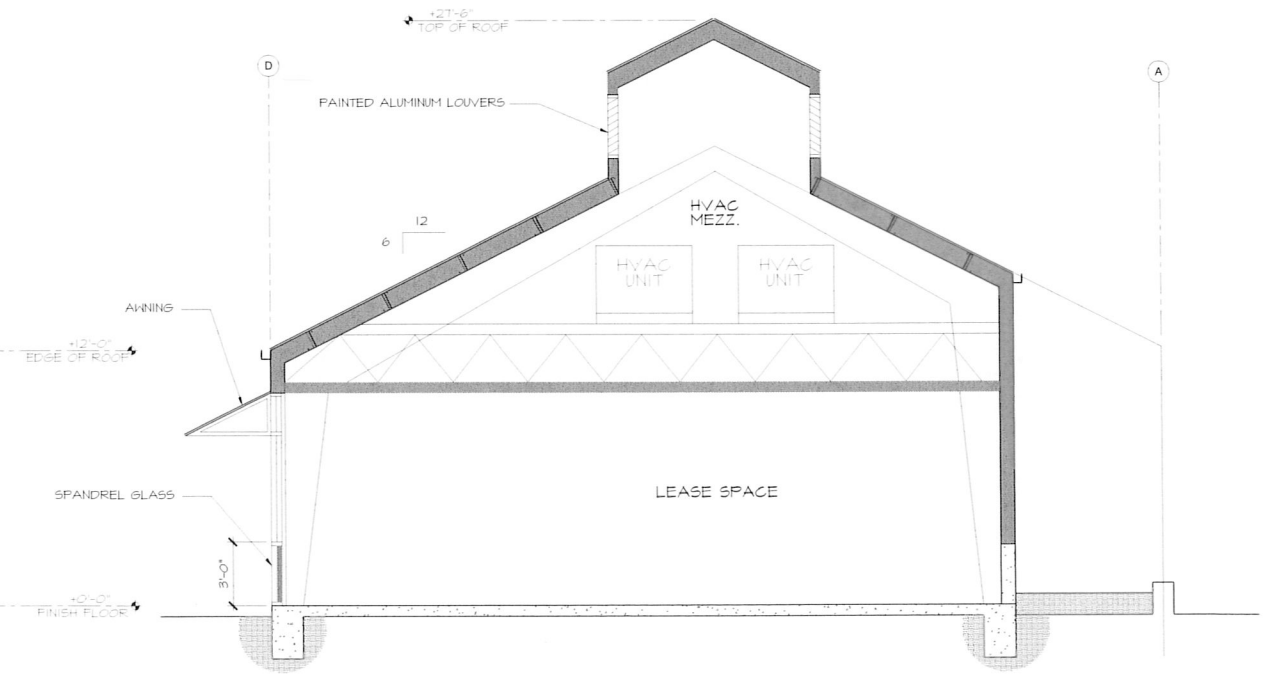


4 BUILDING 'A' SECTION  
1/4" = 1'-0"

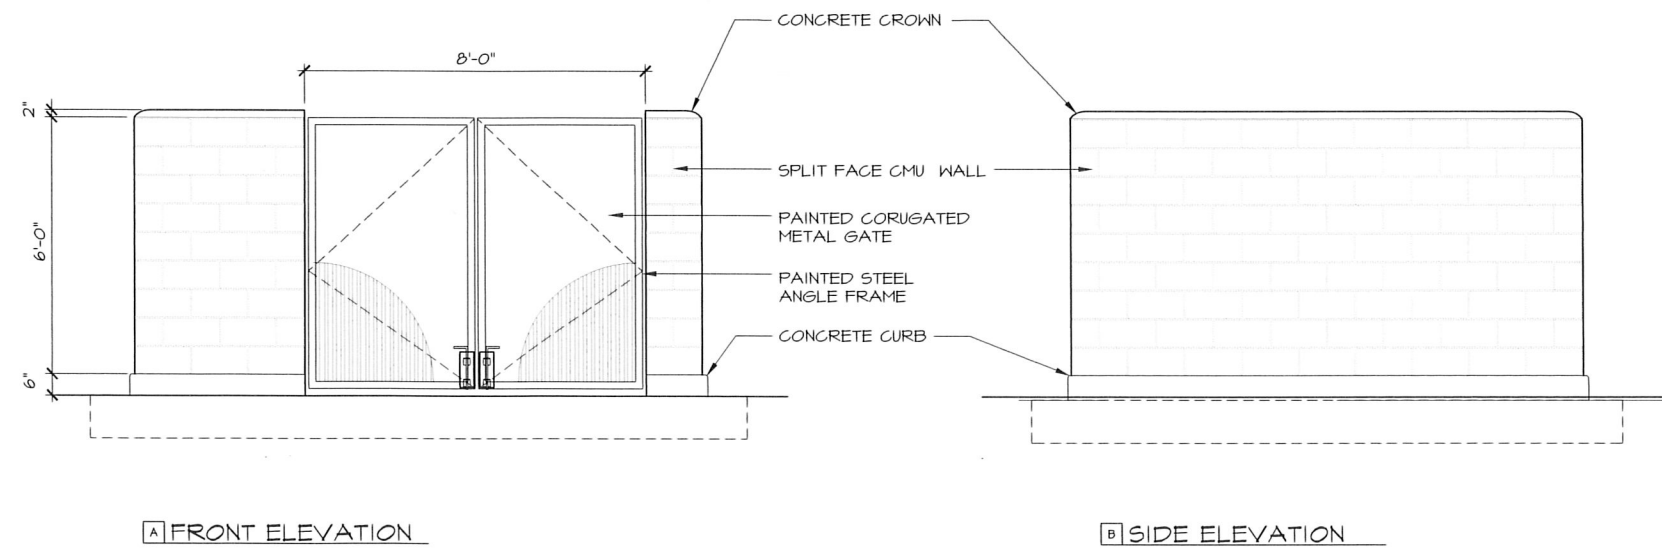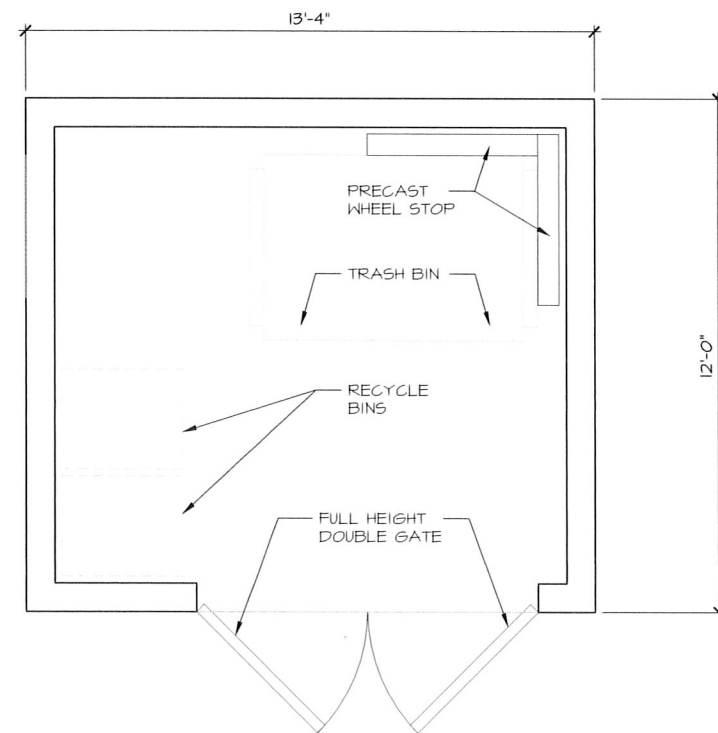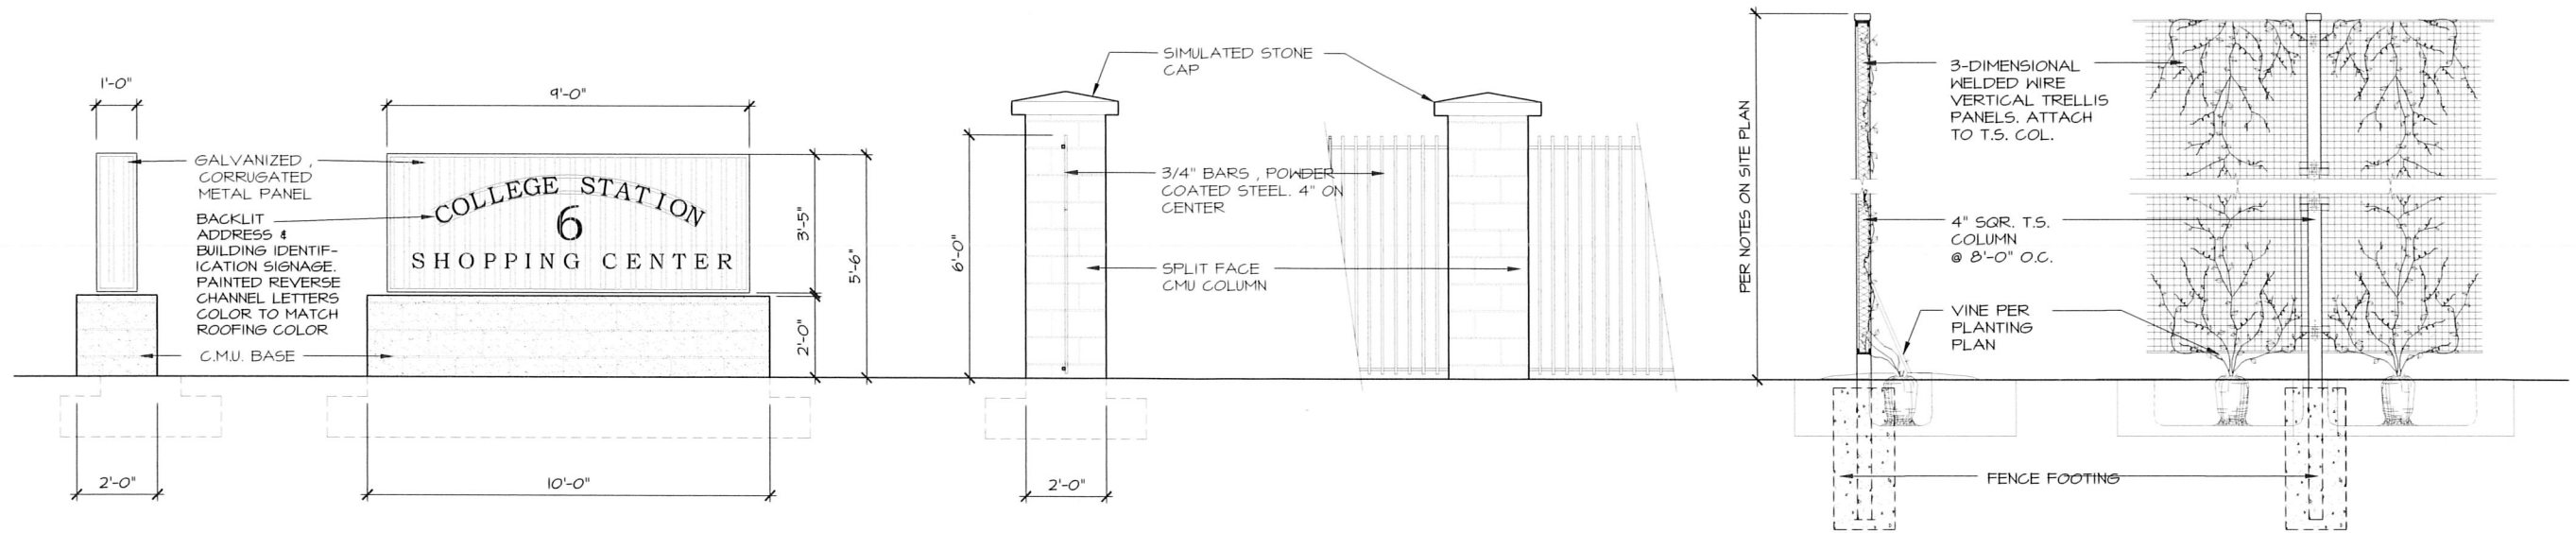




CLEVELAND AVENUE

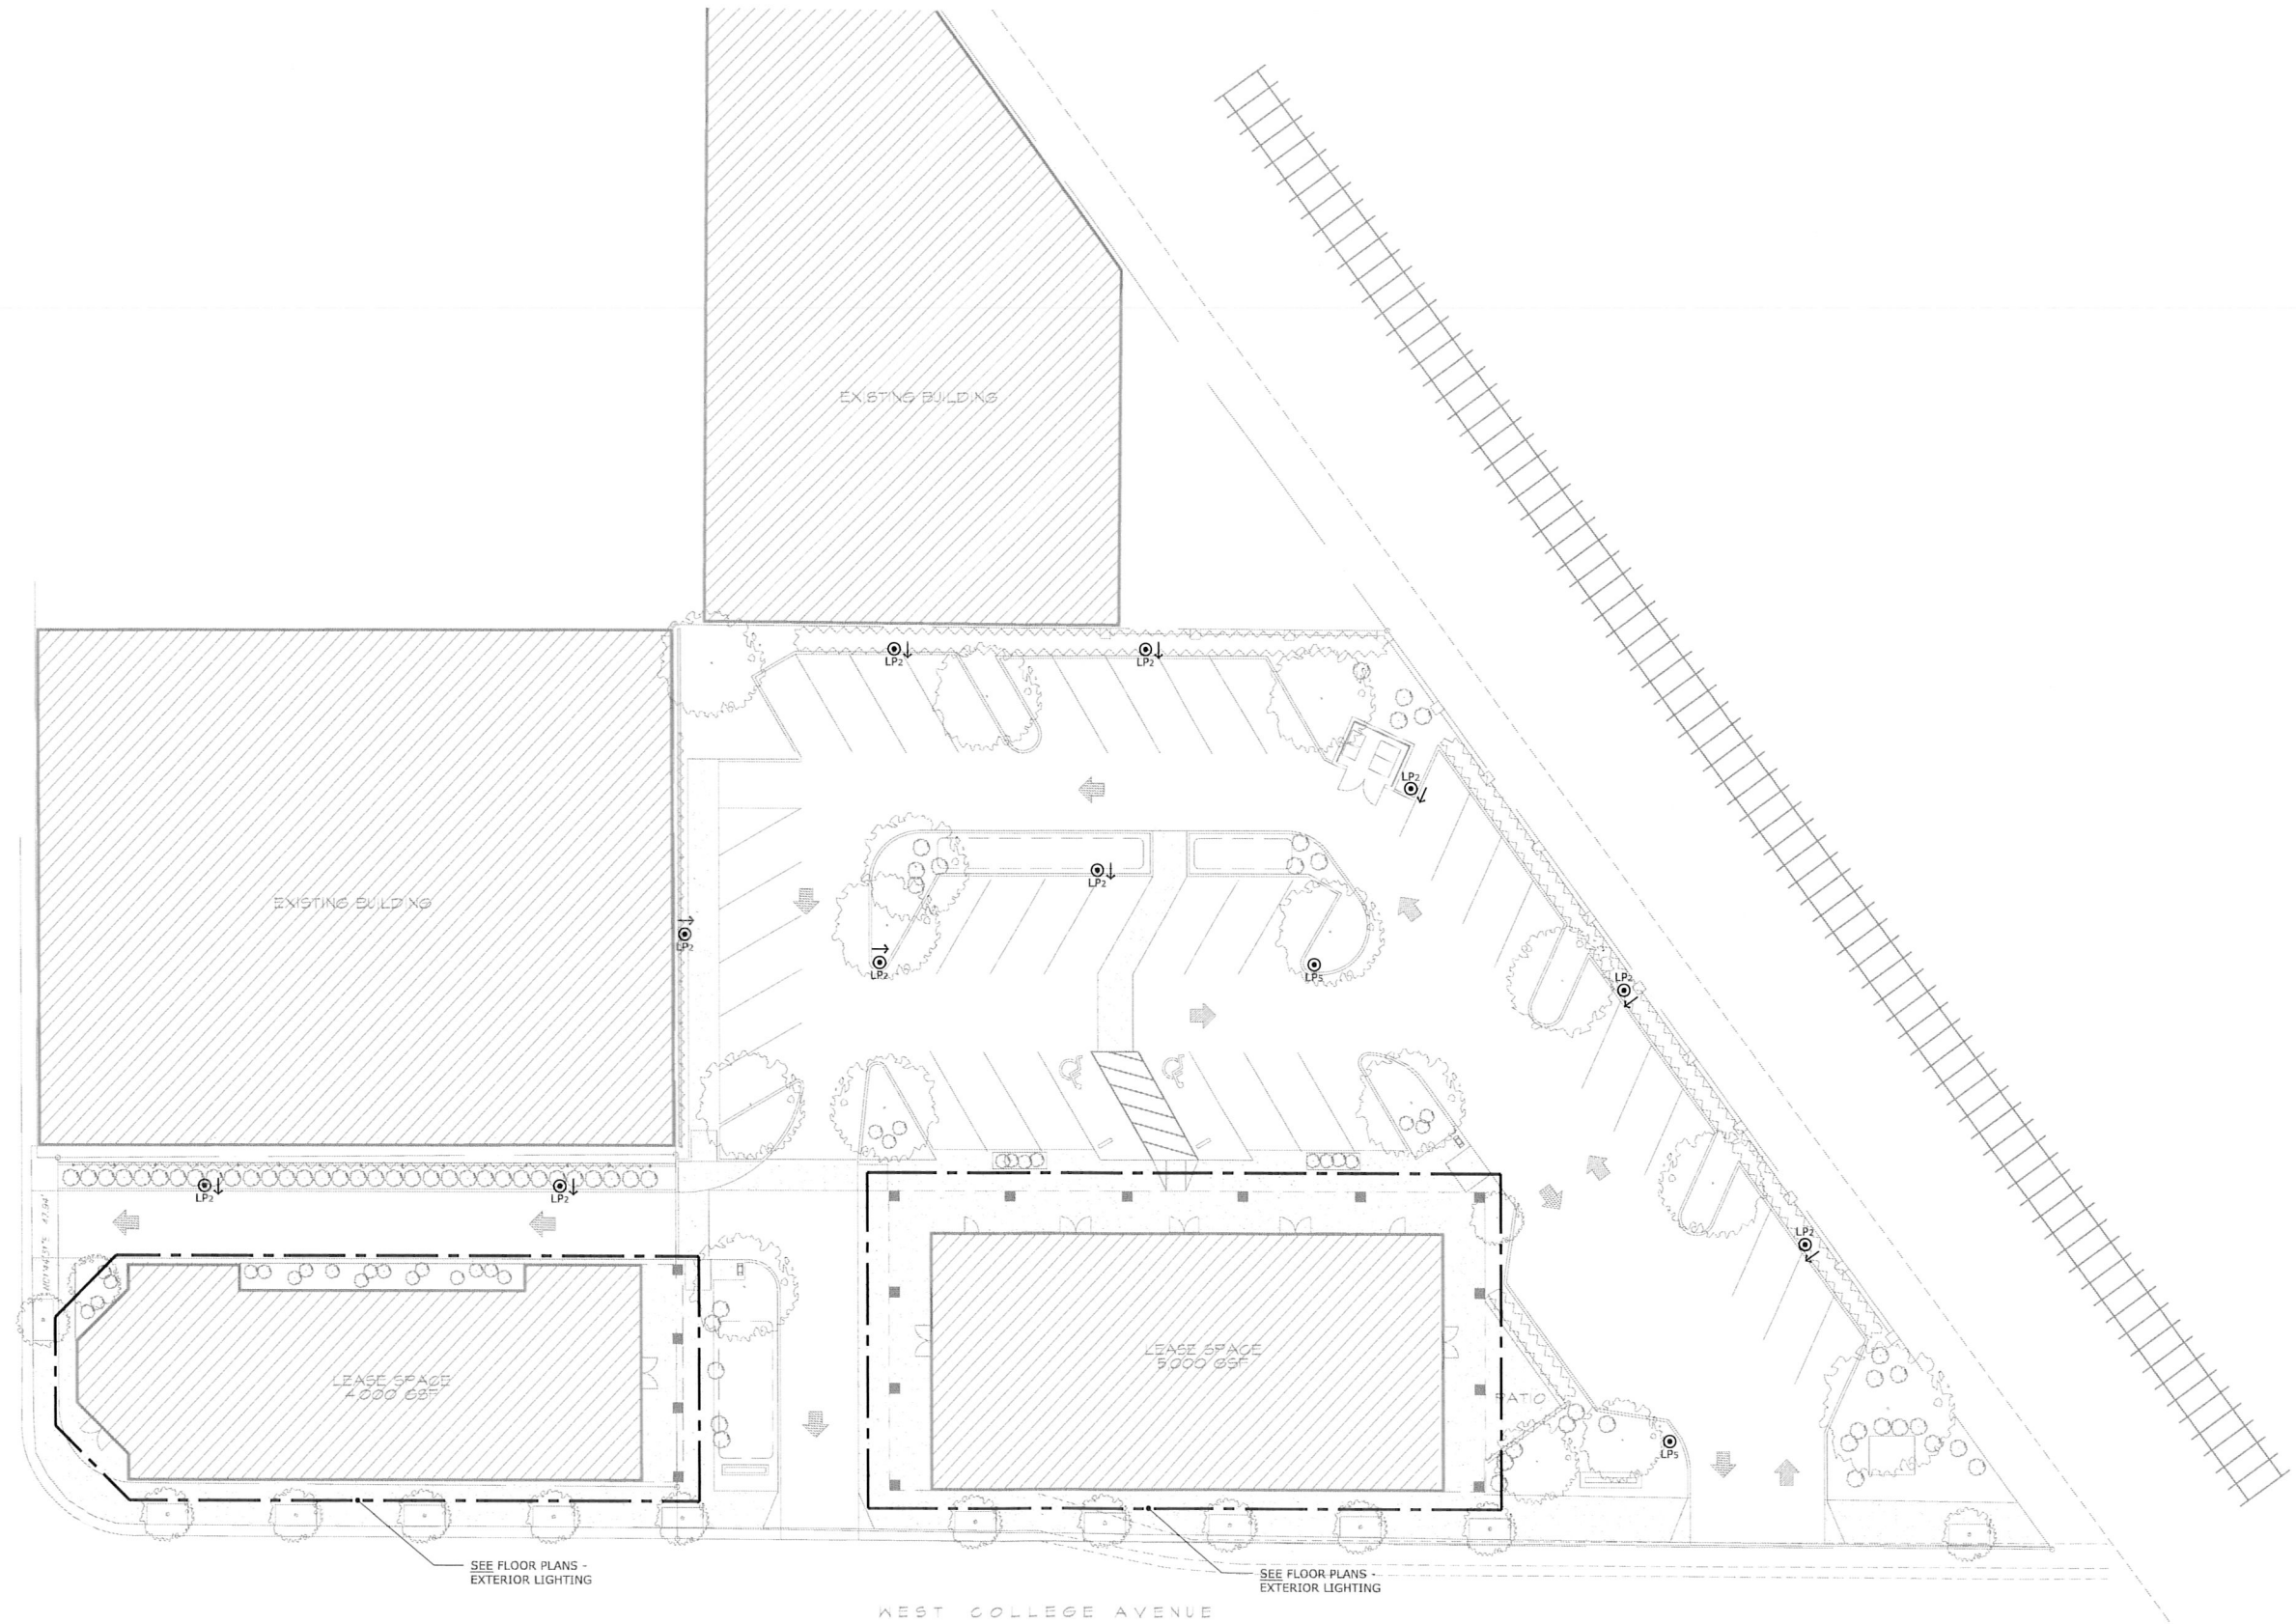

6 WEST COLLEGE AVENUE SHOPPING CENTER  
SITE LIGHTING PLAN

4/22/2016

CLEVELAND AVENUE

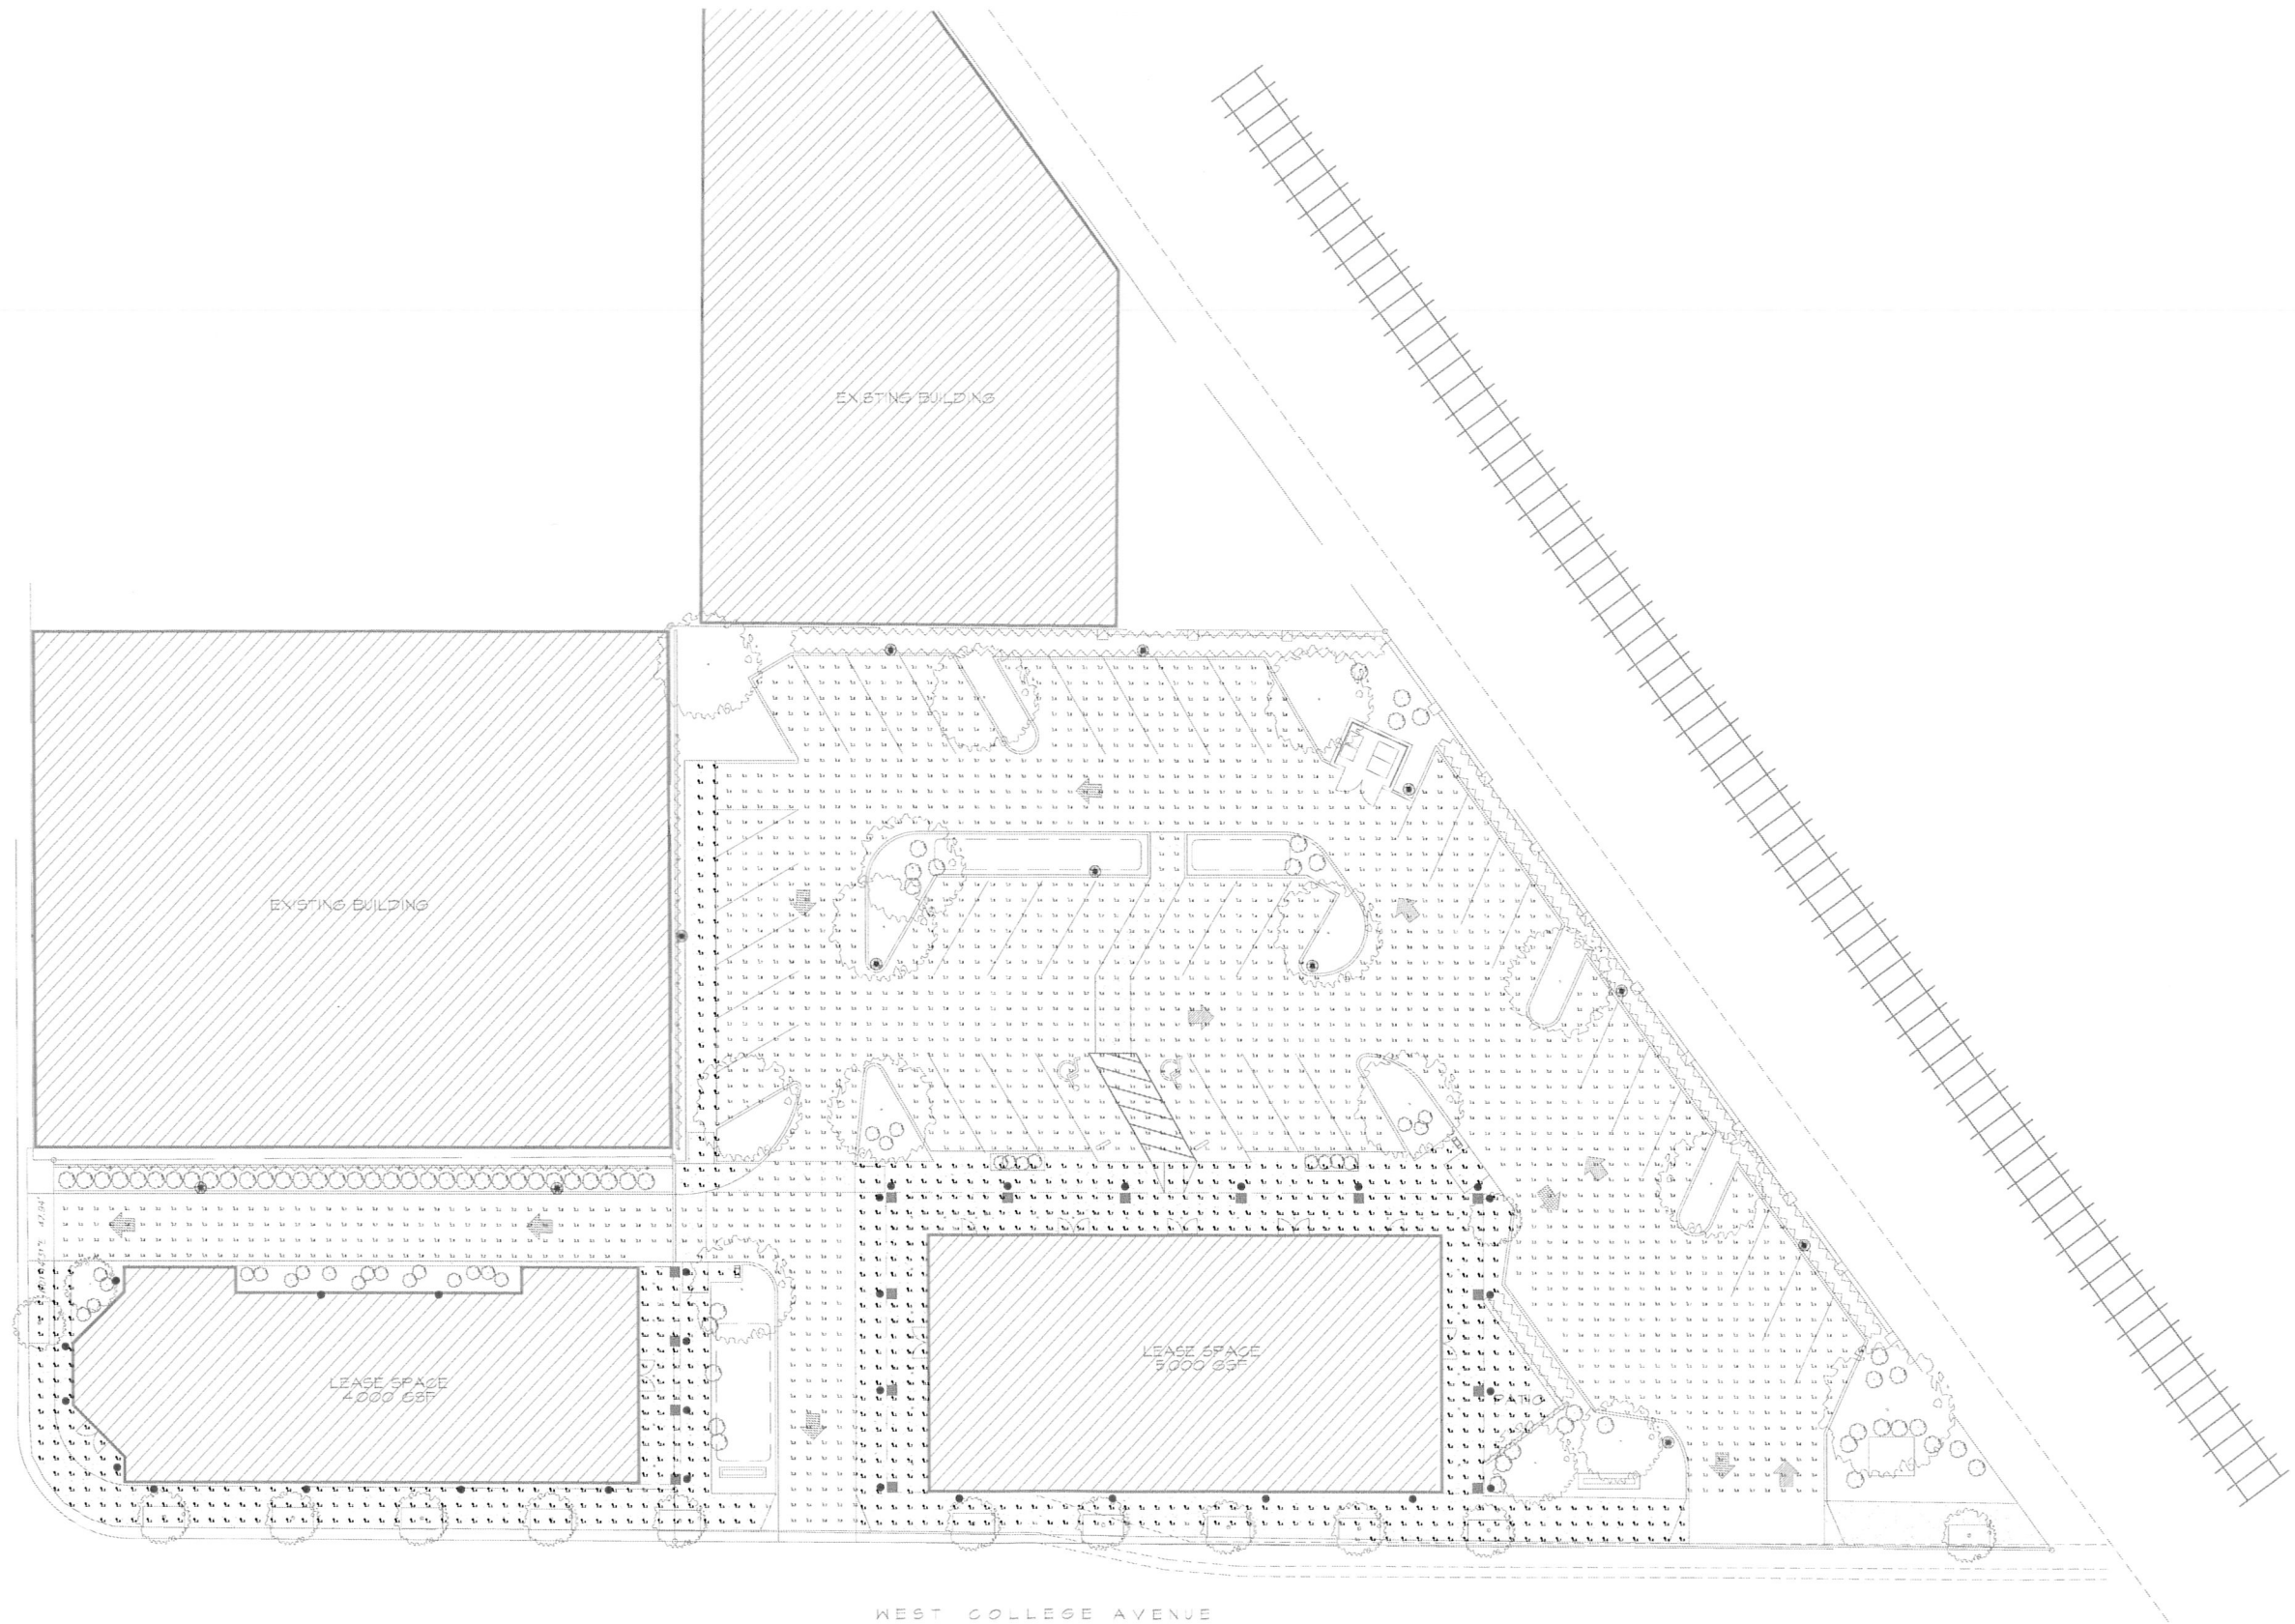

WEST COLLEGE AVENUE



6 WEST COLLEGE AVENUE SHOPPING CENTER  
SITE LIGHTING PHOTOMETRIC PLAN

0 8' 16'  
SCALE: 1/16"=1'-0"



4/22/2016



**WALL MOUNTED SCNCE - 9' MTG. HEIGHT**

**PARKING LOT POLE LIGHT - 16' HEIGHT**

4/22/2016