

DEER CREEK

4743 MONTGOMERY DRIVE
SANTA ROSA, CALIFORNIA

A DEVELOPMENT BY:

RCG REAL ESTATE GROUP


725 WEST VENTURA BLVD, SUITE J, CAMARILLO, CA 93010
805-444-4414

INDEX OF DRAWINGS

1. TITLE SHEET, VICINITY MAP, PROJECT INFORMATION
2. GENERAL CONSTRUCTION NOTES
- 2-D. GENERAL CONSTRUCTION NOTES
3. SITE PLAN, INTERIOR ELEVATIONS
4. MAIN LEVEL FLOOR PLAN, STAIR SECTIONS
3. UPPER LEVEL FLOOR PLAN, DETAILS
0. BUILDING SECTIONS
7. DOOR, WINDOW & ROOM FINISH SCHEDULES
0. EXTERIOR ELEVATIONS
0. EXTERIOR ELEVATION, ROOF PLAN, DETAILS
10. MAIN LEVEL ELECTRICAL PLAN, NOTES
11. UPPER LEVEL ELECTRICAL PLAN, NOTES, REFL. CLG PLAN
- EC-1 TITLE 24 CALC & EC-2 TITLE 24
- CG-1 CALGREEN CHECKLIST & CG-2 CALGREEN CHECKLIST (ATT)

- | | |
|-----|----------------------------------|
| 5N | STRUCTURAL NOTES |
| 5-1 | FOUNDATION PLAN, NOTES |
| 5-2 | SECOND FLOOR FRAMING PLAN, NOTES |
| 5-3 | ROOF FRAMING PLAN, NOTES |
| D-1 | STRUCTURAL DETAILS |
| D-2 | STRUCTURAL DETAILS |
| D-3 | STRUCTURAL DETAILS |

PLAN KEY

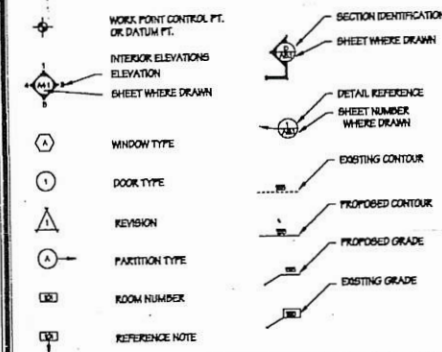


City of Santa Rosa

JUL - 5 2017

Planning & Economic
Development Department

CONSULTANT

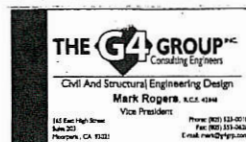

TITLE 24 CALCULATIONS:
NRG COMPLIANCE INC.
SANTA ROSA, CA
PH: 707-237-6957

BAECHTEL HUDIS
CONSULTING CIVIL ENGINEERS & PLANNERS

BH 2360 PROFESSIONAL DRIVE
SANTA ROSA, CALIF. 95403
(707) 542-8786

DARKER SMITH
LANDSCAPE ARCHITECTURE
P. O. BOX 2028, SEBASTOPOL, CA 95473
TEL. & FAX (707) 829-0600

SUMMARY

SINGLE FAMILY RESIDENCE,
TWO STORY, WITH ATTACHED TWO
CAR GARAGE.

TYPE V-B CONSTRUCTION

OCCUPANCY CLASSIFICATION = R3/U

Area Tabulation:

LIVABLE AREA-	
MAIN LEVEL -	1,700 S.F.
UPPER LEVEL -	579
TOTAL LIVABLE -	2,279 S.F.
GARAGE AREA -	553 S.F.
TOTAL BUILDING	2,832 S.F.
COVERED PORCH AREA -	302 S.F.


ENERGY COMPLIANCE

DEF. SHEET EC-1 & EC-2

LEGAL DESCRIPTION

MONTGOMERY CREEK SUBDIVISION & DEER CREEK
4740 MONTGOMERY DRIVE, SANTA ROSA, CA

VICINITY MAP

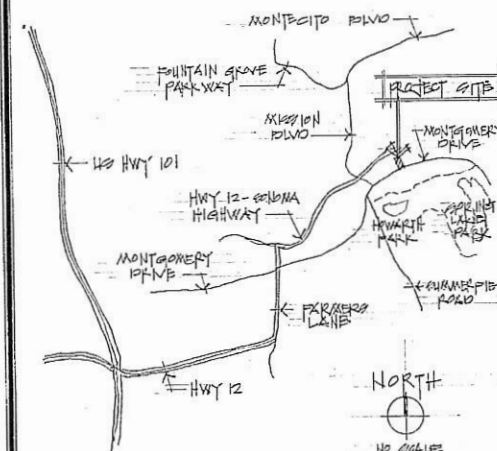

ABBREVIATIONS

[illegible][illegible]

These drawings are the instruments of analysis of CONCEPTUAL STRUCTURES. All designs and other information contained on layers depending on information on the specific problem and their solution are placed on them. The information on the specific problem and that on its solution are placed on them without first abstracting what is essential from the problem and from the solution. This makes it possible to obtain the origin and course of CONCEPTUAL STRUCTURES. These drawings will be reproduced, changed or copied as they see fit by whom without first obtaining written permission from the author.

Abstracting the expressed sentence presentation and essence of CONCEPTUAL STRUCTURES, we may play to be assigned to any third party without need written permission and consent.

*Copyleft: CONCEPTUAL STRUCTURES
All Rights Reserved*

ARCHITECTURAL DESIGN & DRAWINGS DE:
CONCEPTUAL STRUCTURES²
T A U L D E I G H
2300-C LAS ROSAS ROAD #400, CARMILLO, CA 93010
TEL: 408-313-3720 FAX: 408-402-3750
EMAIL: CONCEPTUALSTRUCTURES@ATTN.COM

DEER CREEK
4743 MONTGOMERY DRIVE
SANTA ROJA, CALIFORNIA
A SOUTHWEST BH
KCQ REAL ESTATE GROUP
725 WEST VENTURA BLVD. SUITE J, CARMARKILLO, CA 93010
852-444-1414


PLXH-2


Scale _____

Job DABHM-64

Sheet 1


[illegible]

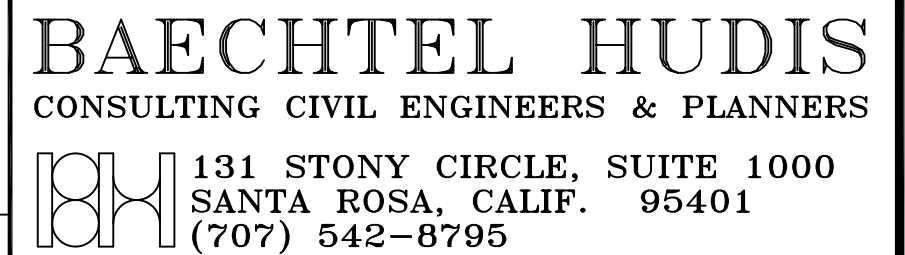

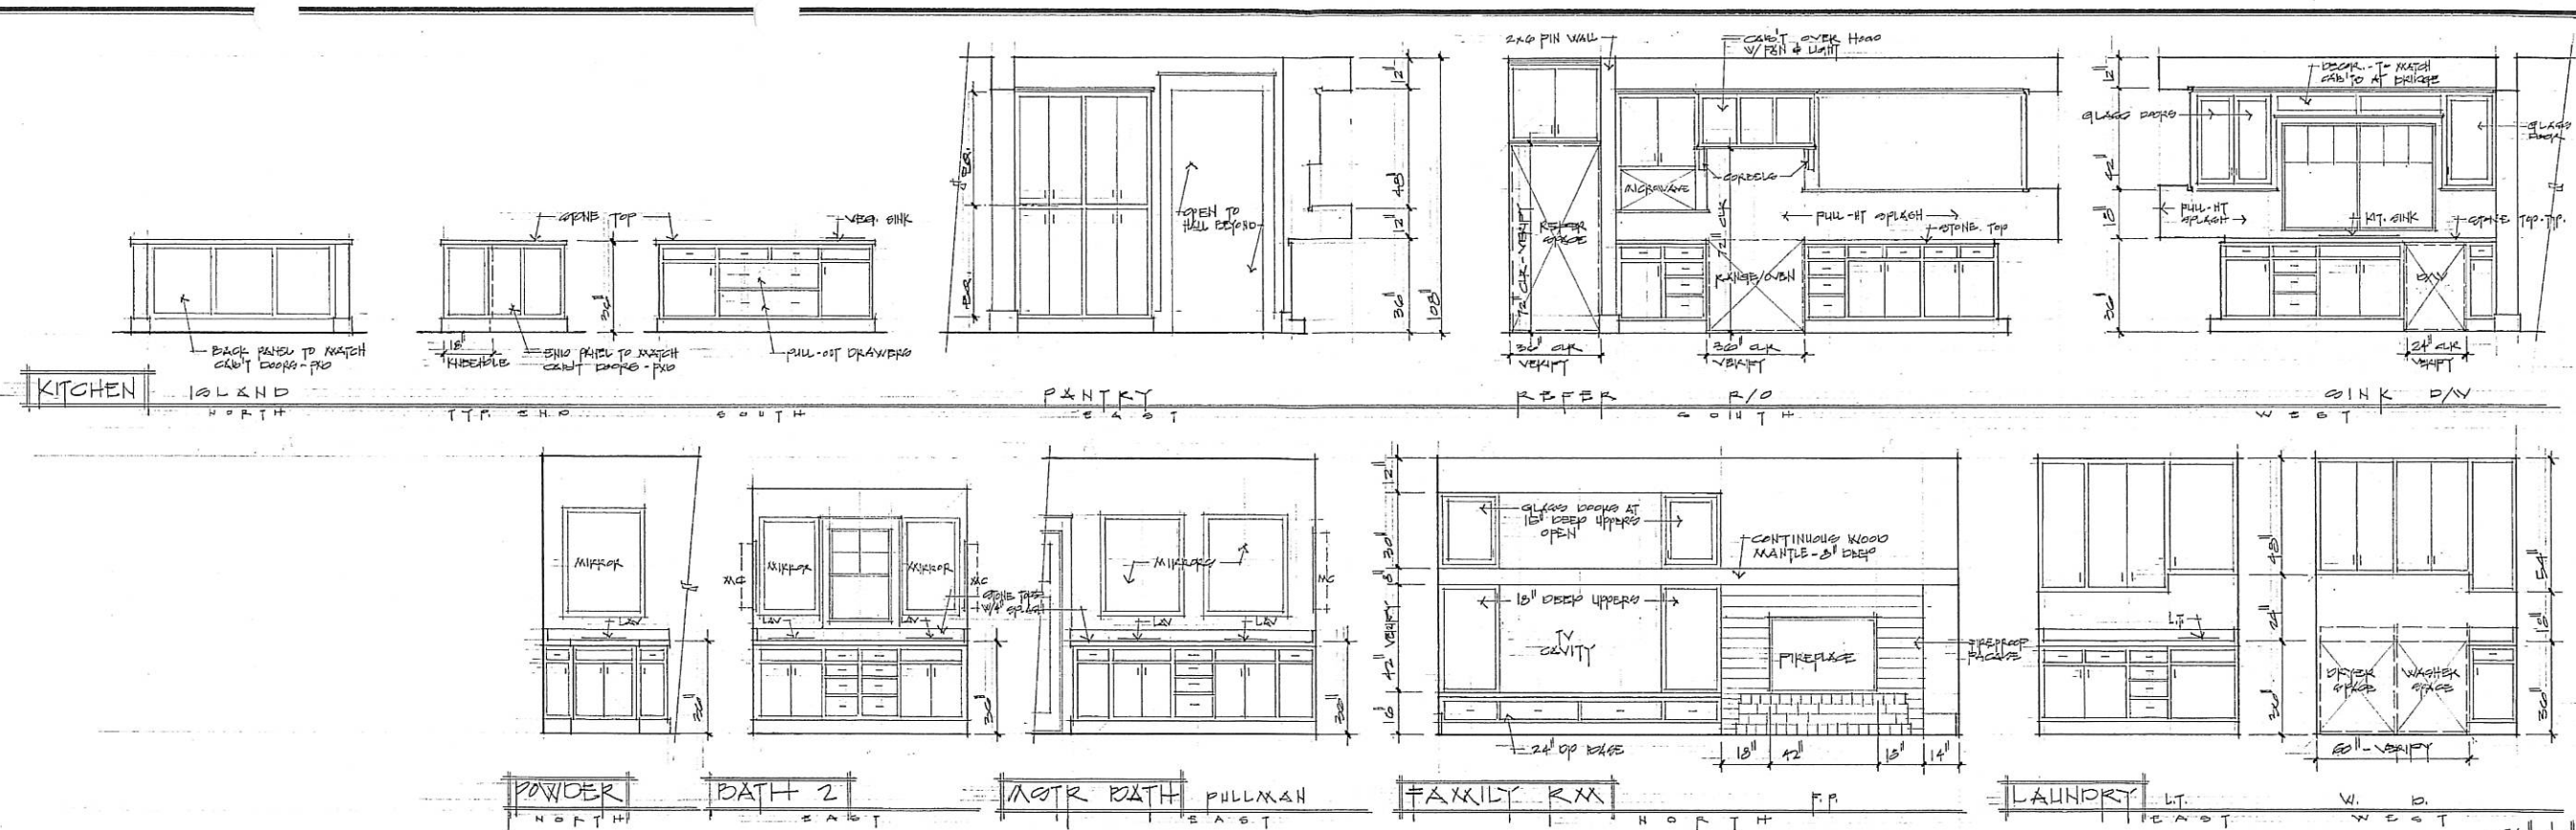

INTERIOR ELEVATIONS

MONTGOMERY DRIVE

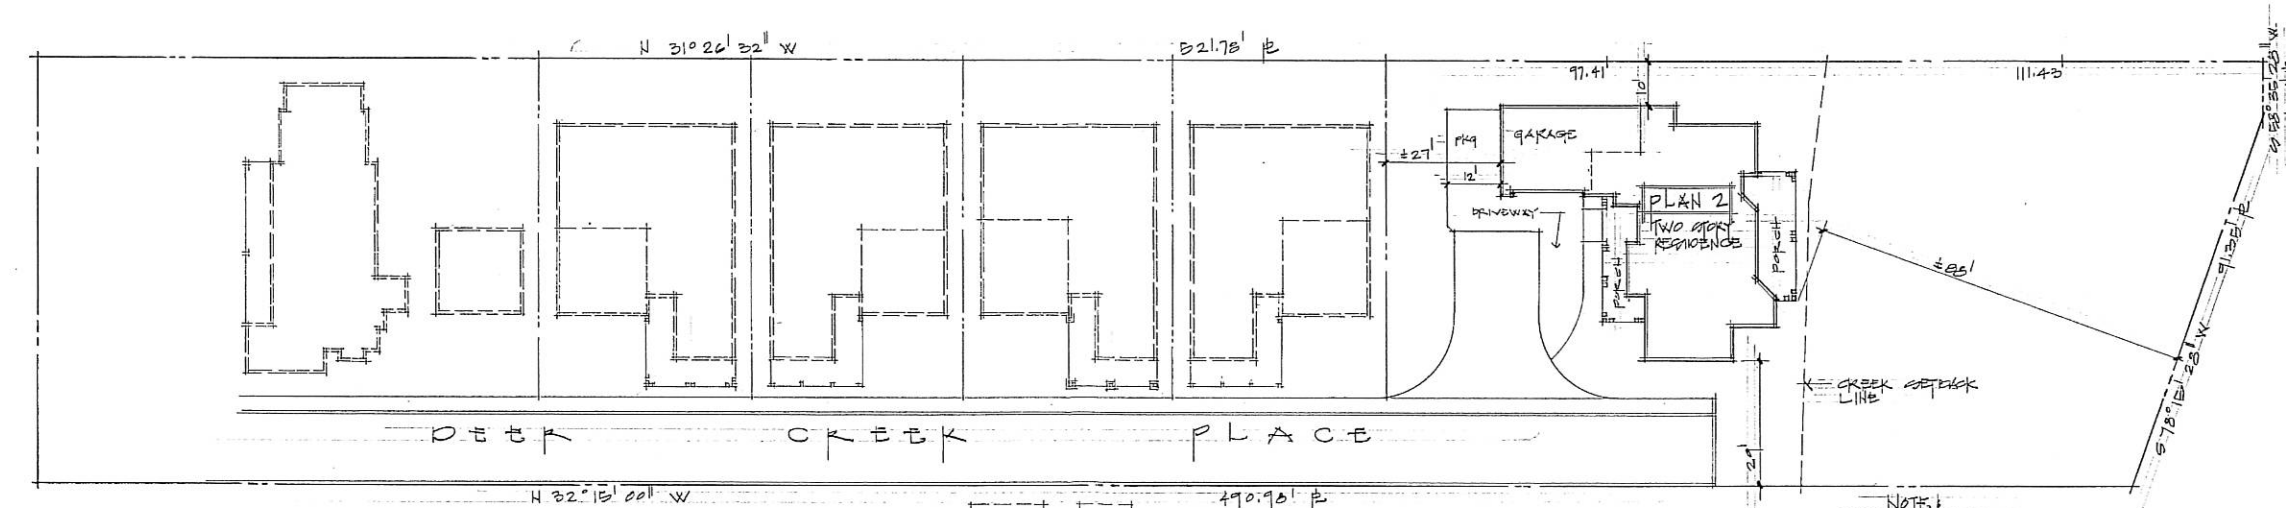

NOTE:
SEE CIVIL ENGINEERING PLANS PREPARED BY:
PETER H. HUI CONSULTING CIVIL ENGINEERS
2800 PROFESSIONAL DRIVE, SANTA ROSA, CA 95408
PH: 707-542-8795, FOR ALL STREET AND GATE
IMPROVEMENTS & SPECIFICATIONS
SEE LANDSCAPE PLANS PREPARED BY:
PARKER-SMITH LANDSCAPE ARCHITECTS
P.O. BOX 2020, SEASIDE, CA 95742
PH: 707-827-0800 FOR ALL LANDSCAPE AND
HARDSCAPE SPECIFICATIONS

S I T E P L A N


REVISIONS		BY

These drawings are the intellectual property of CONCEPTUAL STRUCTURES, INC. All designs and construction information contained herein are for the use of the client only. No part of these drawings may be reproduced, stored in a retrieval system, or transmitted in any form or by any means, electronic, mechanical, photocopying, recording, or by any information storage and retrieval system, without the prior written permission of CONCEPTUAL STRUCTURES, INC. The client agrees to indemnify and hold the architect harmless from all claims, damages, and expenses, including reasonable attorneys' fees, arising out of or from the use of these drawings.


CONCEPTUAL STRUCTURES, INC.
ARCHITECTURAL DESIGN & DRAWINGS BY:
CONCEPTUAL STRUCTURES, INC.
2300-C LAS POSAS ROAD #400, CANTARILLO, CA 93010
TEL: 660-413-1728 - FAX: 660-497-1330
EMAIL: CONCEPTUALSTRUCTURES@GMAIL.COM

DEER CREEK
4743 MONTGOMERY DRIVE
SANTA ROSA, CALIFORNIA
A DEVELOPMENT BY
RCQ REAL ESTATE GROUP
725 WEST VENTURA BLVD., SUITE J, CANTARILLO, CA 93010
953-144-1414


PLAN 2
Date: 10/24/2017
Scale: AS NOTED
Drawn: P. BELSH
Job: POEM-L07
Sheet: 3
Of: 3 Sheets

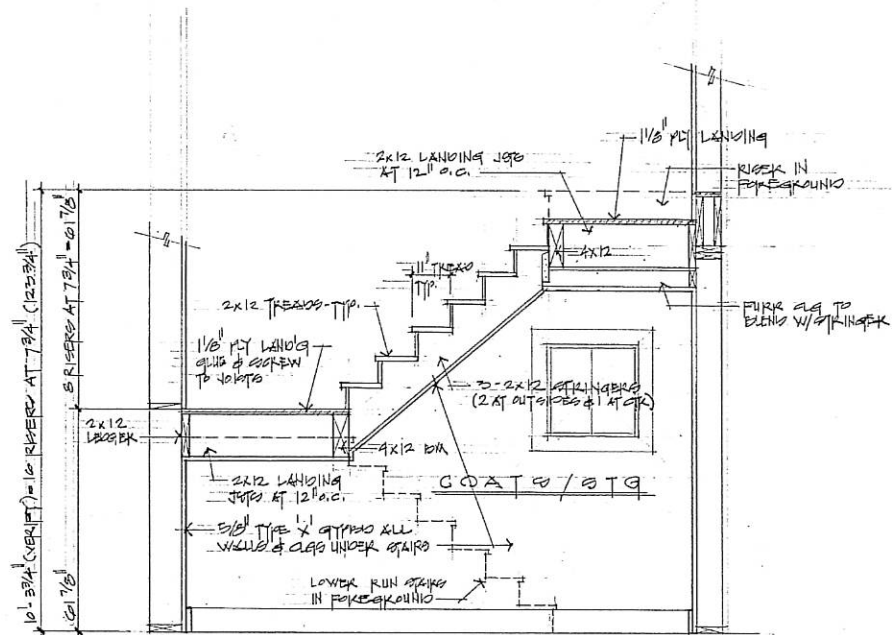

SECTION A AT UPPER RUN

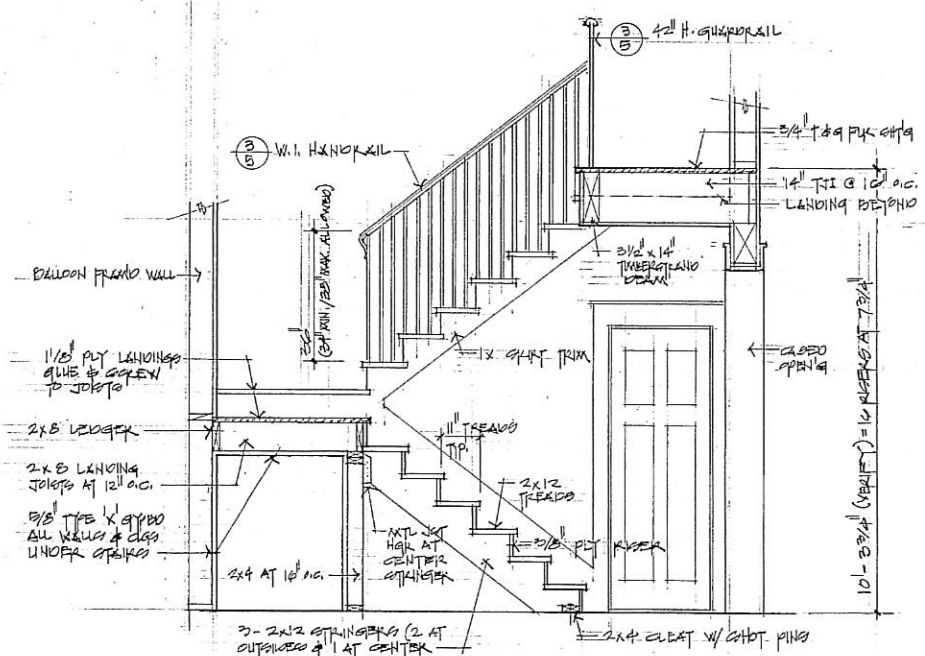

SECTION B AT LOWER RUN

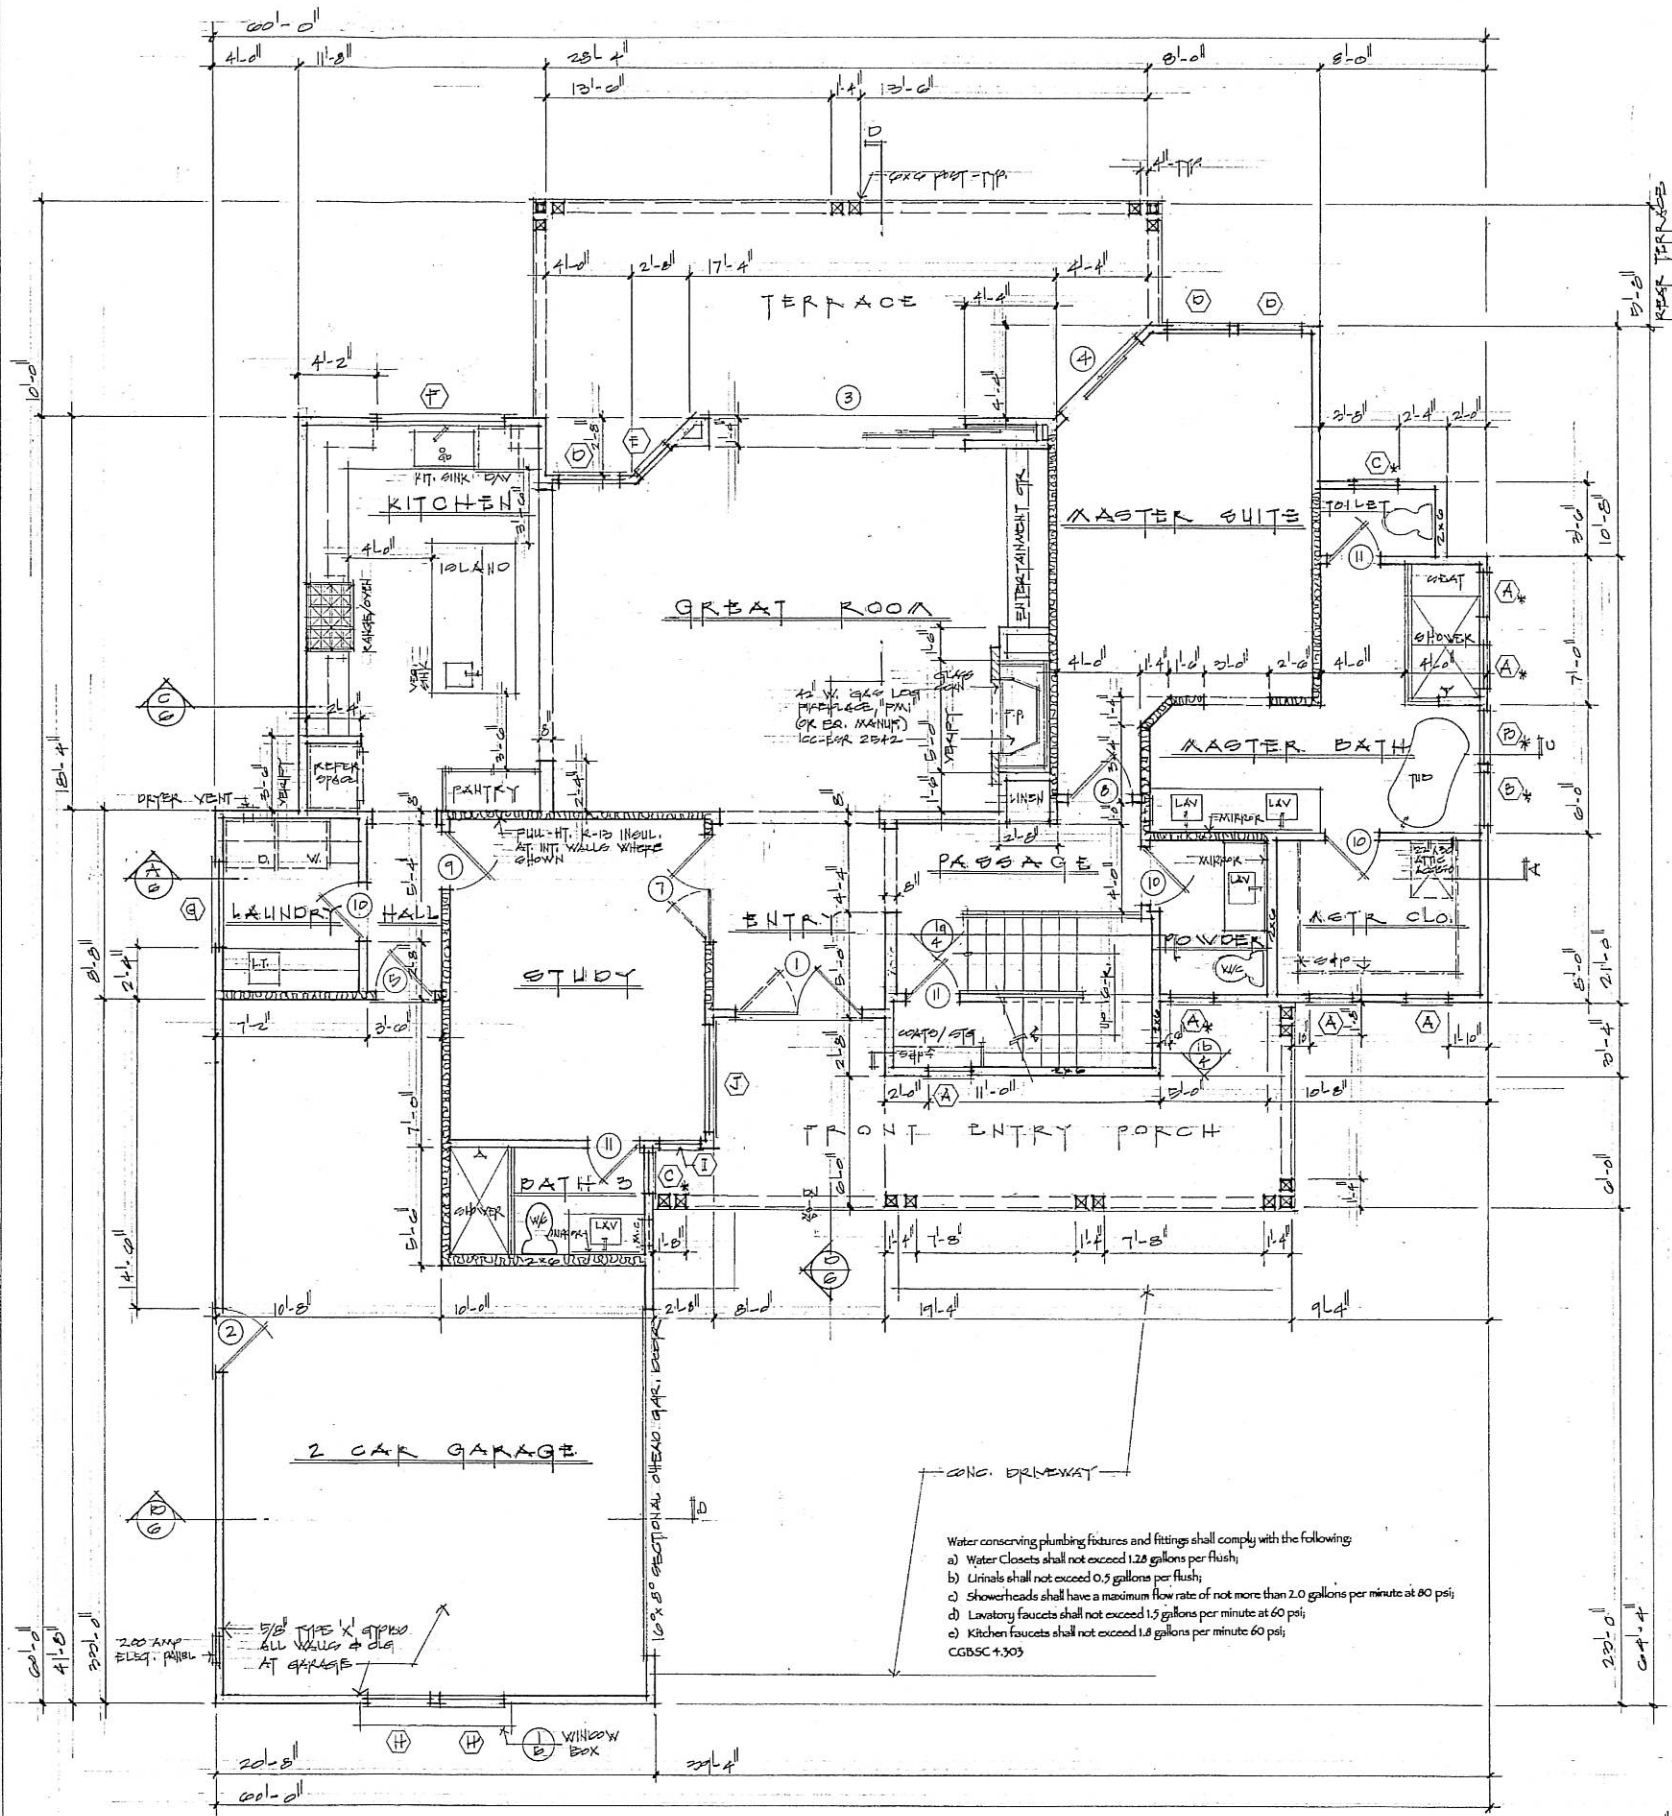

MAIN LEVEL FLOOR PLAN

REVISIONS	BY




These drawings are for the construction of CONCEPTUAL STRUCTURES. The drawings are not to be used for any other purpose, and the user assumes all liability for any errors or omissions. The drawings are not to be used for any other purpose, and the user assumes all liability for any errors or omissions. The drawings are not to be used for any other purpose, and the user assumes all liability for any errors or omissions.

ARCHITECTURAL DESIGN & DRAWINGS BY:
CONCEPTUAL STRUCTURES
 2300-C LAS POSAS ROAD #400, CARMARILLO, CA 93010
 TEL: 805-407-1370 FAX: 805-407-1370
 E-MAIL: CONCEPTUALSTRUCTURES@GMAIL.COM


DEER CREEK
 4743 MONTGOMERY DRIVE
 SANTA ROSA, CALIFORNIA
 DEVELOPMENT BY:
KCO REAL ESTATE GROUP
 725 WEST VENTURA BLVD., SUITE J, CARMARILLO, CA 93010
 805-444-4444

PLAN 2
 Date: 11/14/2017
 Scale: AS NOTED
 Drawn: P. DELIGHT
 Job: BATH-170
 Sheet
 Of 4 Sheets


LATERAL FORCE = 200 LBS
 SPACING OF BRACKETED VERTICALS = 4' O.C.
 ME RAILS = 200 X 4 X 3.5 = 700
 REQ'D @ 700 X 12 / 10,140 = 0.032 IN² USE 1/4" X 1/2" TUBS
 FORCE ON RAILS = 700 X 12 / 240 = 400 LBS (WITH KAYAK)
 CAPACITY OF 1/2" X 1/2" LAGS = 0.370 ACUS (4) 1/2" LAGS

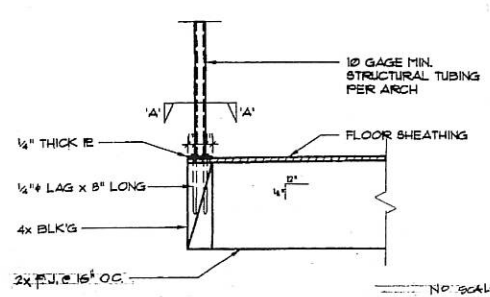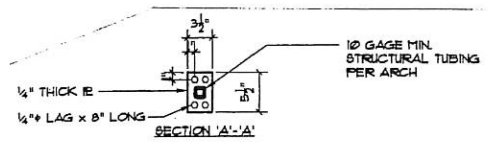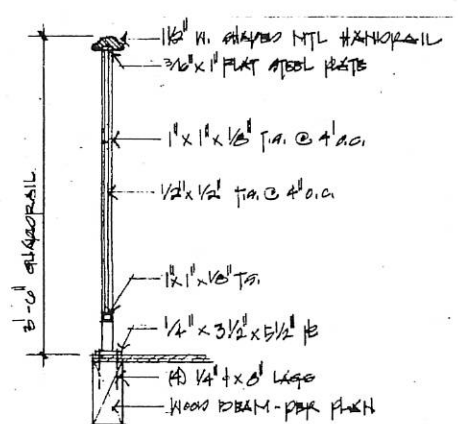


RAILING 3

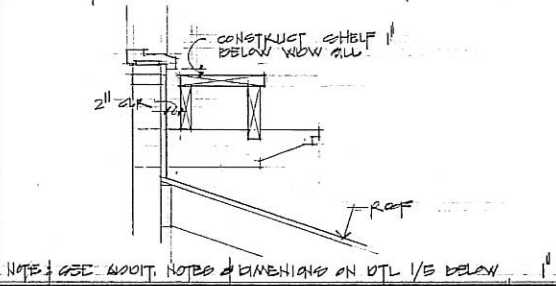


WINDOW BOX 2

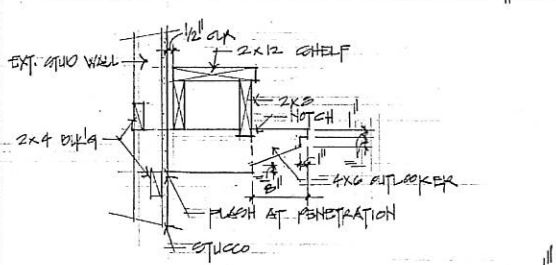

WINDOW BOX 1

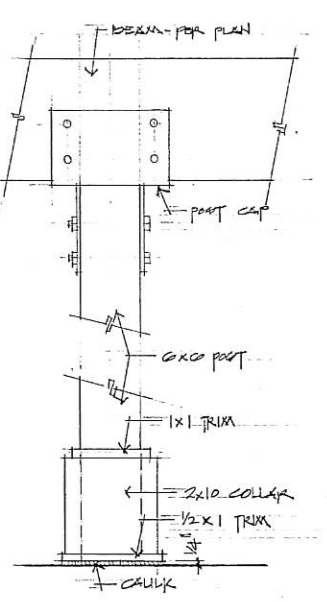

TYP. POST 4

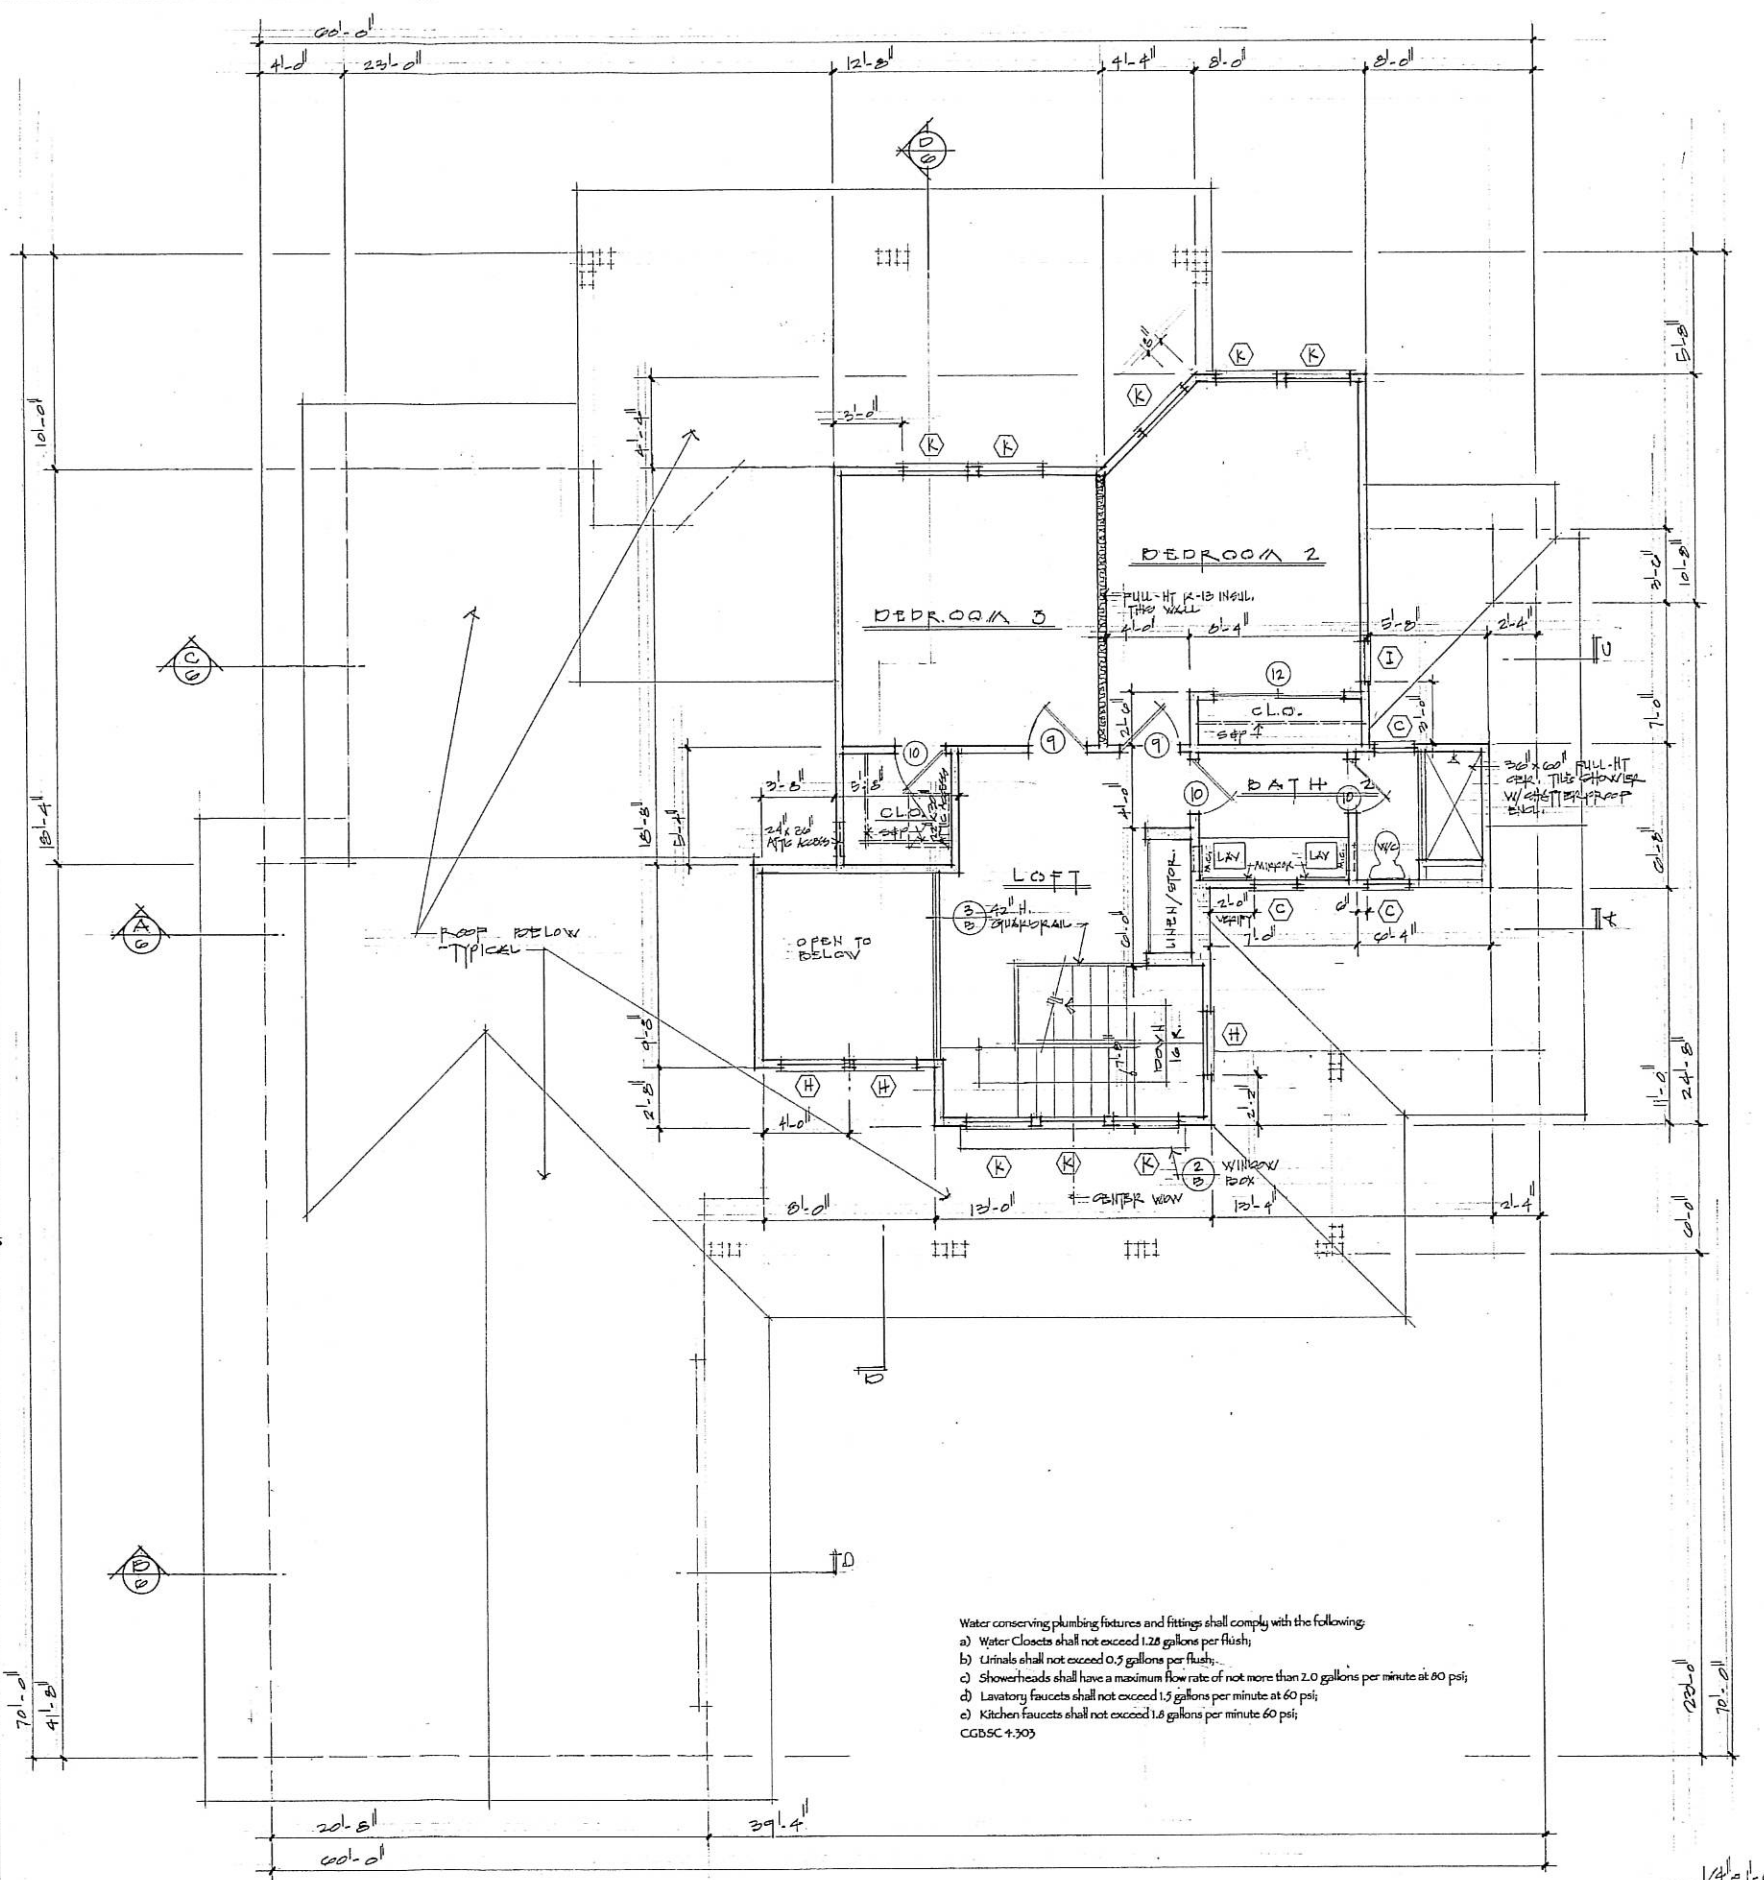

UPPER LEVEL FLOOR PLAN 579 S.F.


REVISIONS		BY

These drawings are the property of CONCEPTUAL STRUCTURES, INC. and shall not be reproduced, copied, or used in any way without the written permission of CONCEPTUAL STRUCTURES, INC. The drawings are prepared for the project and shall not be used for any other project. The drawings are prepared for the project and shall not be used for any other project. The drawings are prepared for the project and shall not be used for any other project.

ARCHITECTURAL DESIGN & DRAWINGS BY:
CONCEPTUAL STRUCTURES, INC.
 2300-C LINS TOWNS ROAD #100, CANTERBURY, CA 93010
 TEL: 805-413-1370 FAX: 805-413-1370

DEER CREEK
 4743 MONTGOMERY DRIVE
 SANTA ROSA, CALIFORNIA
 95405
 725 WEST VENTURA BLVD, SUITE J, CANTERBURY, CA 93010
 805-444-4411

 PLAN 2
 Date: 10/11/2017
 Scale: 1/8" = 1'-0"
 Drawn: P. BISHOP
 Job: BISHOP-1070
 Sheet: 5
 Of: 5 Sheets



ROOF PLAN

— E X T E R I O R E L E V A T I O N

PLAN 2
Date: April 2017
Scale: AS NOTED
Drawn: P. DELIGHT
Job: BETHA-LOTG
Sheet: 9
of 9 Sheets