



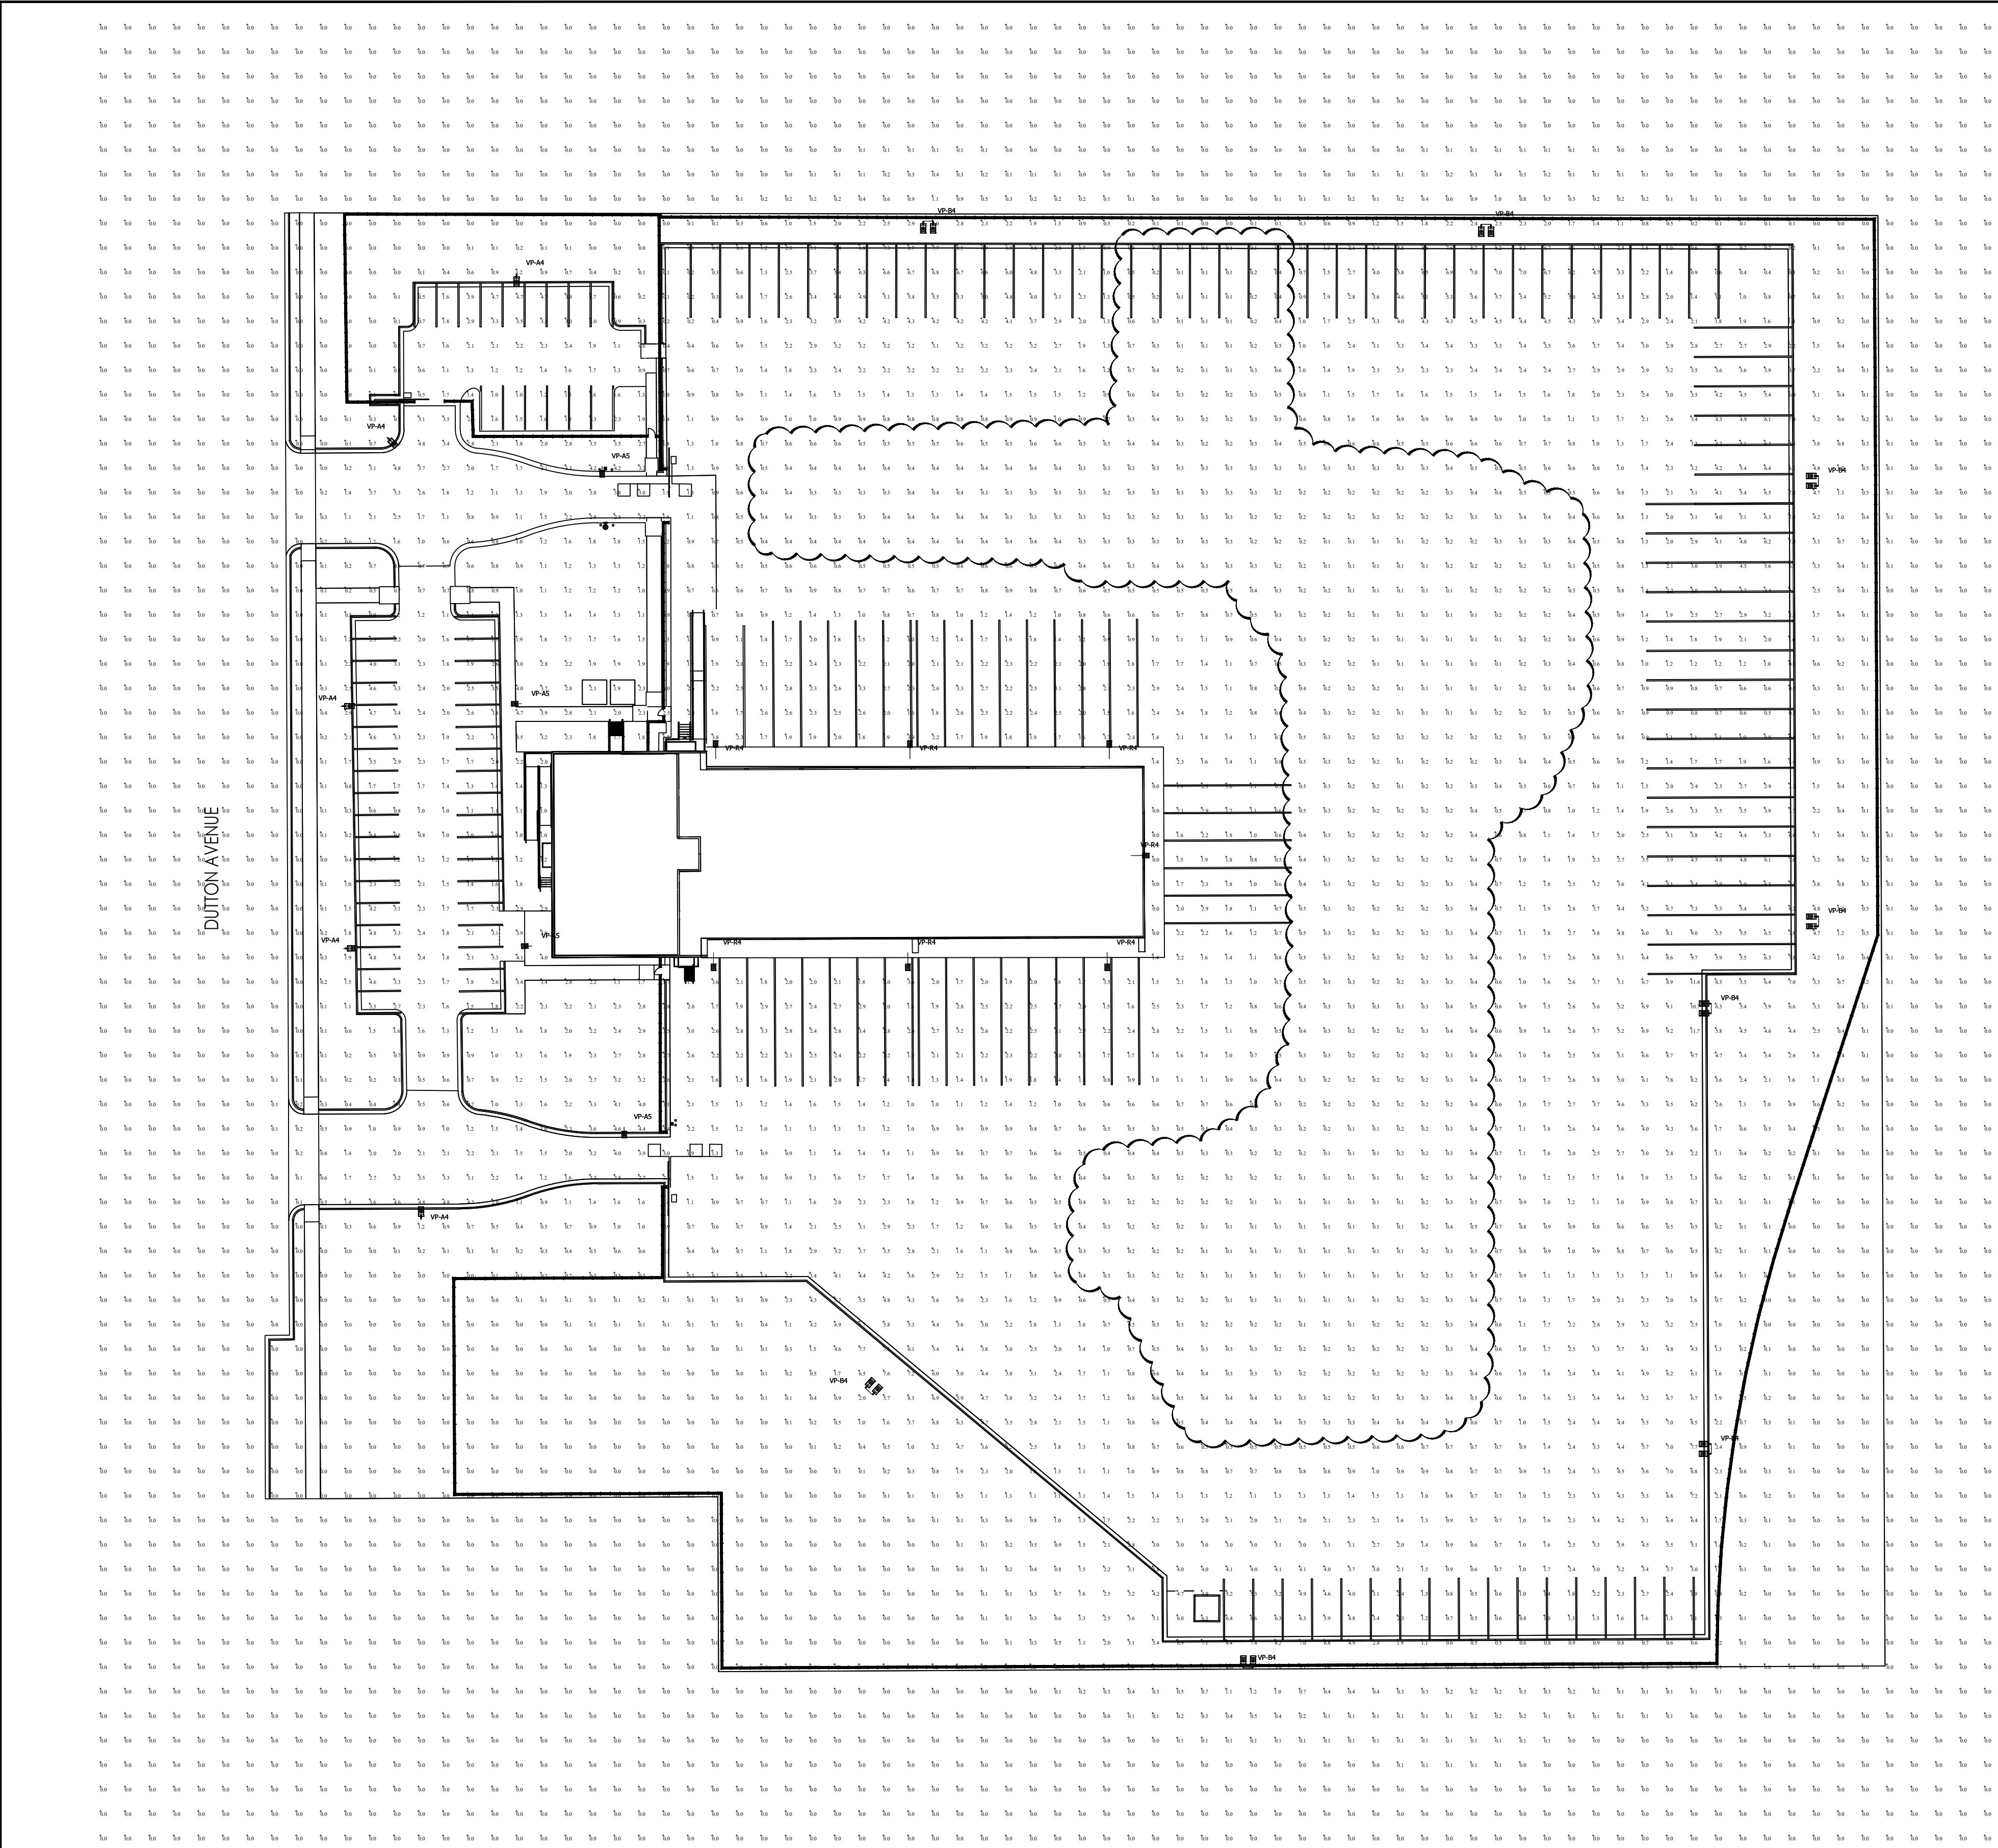

Luminaire Schedule							
Symbol	Label	Qty	Mounting Height	LLF	Watts	Lumens	Description
	VP-A4	5	16' - 0" AFG	0.900	135	9372	VP-L-64L-135-3K7-4W-BC-B
	VP-A5	4	16' - 0" AFG	0.900	136	15071	VPS-60L-136-4K7-5W
	VP-R4	7	25' - 0" AFG	0.900	136	15104	VPS-60L-136-4K7-4W
	VP-B4	8	30' - 0" AFG	0.900	395	24737	VP-L-96L-395-4K7-4W-BC-B

Calculation Summary							
Label	CalcType	Units	Avg	Max	Min	Avg/Min	Max/Min
Employee Lot	Iluminance	Fc	2.06	4.8	0.2	10.30	24.00
Overall Area	Iluminance	Fc	0.84	11.7	0.0	N.A.	N.A.
Terminal Lot	Iluminance	Fc	1.52	11.7	0.0	N.A.	N.A.

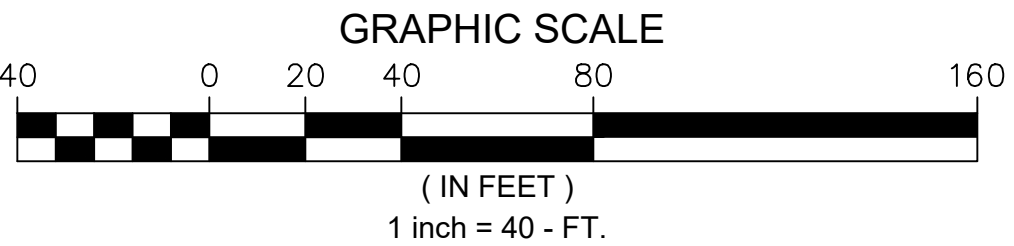

THIS LIGHTING DESIGN IS BASED ON LIMITED INFORMATION SUPPLIED BY OTHERS TO HUBBELL LIGHTING. SITE DETAILS PROVIDED HEREON ARE REPRODUCED ONLY AS A VISUALIZATION AID. FIELD DEVIATIONS MAY SIGNIFICANTLY AFFECT PREDICTED PERFORMANCE. PRIOR TO INSTALLATION, CRITICAL SITE INFORMATION (POLE LOCATIONS, ORIENTATION, ETC.) SHOULD BE COORDINATED WITH THE CONTRACTOR AND/OR SPECIFIER RESPONSIBLE FOR THE PROJECT.											
2. LUMINAIRE DATA IS TESTED TO INDUSTRY STANDARDS UNDER LABORATORY CONDITIONS. OPERATING VOLTAGE AND NORMAL MANUFACTURING TOLERANCES OF LAMP, BALLAST, AND LUMINAIRE MAY AFFECT FIELD RESULTS.											
3. CONFORMANCE TO FACILITY CODE AND OTHER LOCAL REQUIREMENTS IS THE RESPONSIBILITY OF THE OWNER AND/OR THE OWNER'S REPRESENTATIVE.											
TITLE:		REVISED FROM DRAWING NUMBER(S):			 Hubbell Lighting, Inc. 701 MILLENNIUM BLVD. GREENVILLE, SC 29607		DN BY:		DATE:	CHK BY:	
OLD DOMINION FREIGHT LINES SANTA ROSA, CA SITE LIGHTING PLAN (OPTION A)		R1: 06/04/18		REV BY:			DHK		04/25/18	N/A	
		R2: 01/07/19					DHK				
		R3: 09/24/19							10/02/19	AS NOTED	
		R4: 10/02/19									
						QUOTE:		DRAWING / DESIGN NO.:			
						N/A		1821681R4			

- THIS LIGHTING DESIGN IS BASED ON LIMITED INFORMATION SUPPLIED BY OTHERS TO HUBBELL LIGHTING. SITE DETAILS PROVIDED HEREON ARE REPRODUCED ONLY AS A VISUALIZATION AID. FIELD DEVIATIONS MAY SIGNIFICANTLY AFFECT PREDICTED PERFORMANCE. PRIOR TO INSTALLATION, CRITICAL SITE INFORMATION (POLE LOCATIONS, ORIENTATION, MOUNTING HEIGHT, ETC) SHOULD BE COORDINATED WITH THE CONTRACTOR AND/OR SPECIFIER RESPONSIBLE FOR THE PROJECT.
- LUMINAIRE DATA IS TESTED TO INDUSTRY STANDARDS UNDER LABORATORY CONDITIONS. OPERATING VOLTAGE AND NORMAL MANUFACTURING TOLERANCES OF LAMP, BALLAST, AND LUMINAIRE MAY AFFECT FIELD RESULTS.
- CONFORMANCE TO FACILITY CODE AND OTHER LOCAL REQUIREMENTS IS THE RESPONSIBILITY OF THE OWNER AND/OR THE OWNER'S REPRESENTATIVE.