


Calculation Summary							
Label	CalcType	Units	Avg	Max	Min	Avg/Min	Max/Min
Employee Lot	Illuminance	Fc	3.18	9.6	1.1	2.89	8.73
Overall Area	Illuminance	Fc	1.38	11.1	0.0	N.A.	N.A.
Terminal Lot	Illuminance	Fc	2.33	7.1	1.0	2.33	7.10

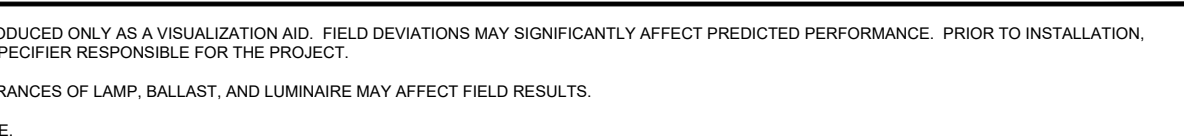

1. THIS LIGHTING DESIGN IS BASED ON LIMITED INFORMATION SUPPLIED BY OTHERS TO HUBBELL LIGHTING. SITE DETAILS PROVIDED HEREON ARE REPRODUCED ONLY AS A VISUALIZATION AND, FIELD DEVIATIONS MAY SIGNIFICANTLY AFFECT PREDICTED PERFORMANCE. PRIOR TO INSTALLATION, CRITICAL SITE INFORMATION (POLE LOCATIONS, ORIENTATION, MOUNTING HEIGHT, ETC.) SHOULD BE COORDINATED WITH THE CONTRACTOR AND/OR SPECIFIER RESPONSIBLE FOR THE PROJECT. 2. LUMINAIRE DATA IS TESTED TO INDUSTRY STANDARDS UNDER LABORATORY CONDITIONS. OPERATING VOLTAGE AND NORMAL MANUFACTURING TOLERANCES OF LAMP, BALLAST, AND LUMINAIRE MAY AFFECT FIELD RESULTS. 3. CONFORMANCE TO FACILITY CODE AND OTHER LOCAL REQUIREMENTS IS THE RESPONSIBILITY OF THE OWNER AND/OR THE OWNER'S REPRESENTATIVE.										
TITLE:		REVISED FROM DRAWING NUMBER(S): R1: 06/04/18 R5: 10/04/19 R2: 01/07/19 R6: 10/07/19 R3: 09/24/19 R7: 10/10/19 R4: 10/02/19 R8: 10/29/19				 Hubbell Lighting, Inc. 701 MILLENNIUM BLVD. GREENVILLE, SC 29607		DN BY: DHK REV. BY: DHK QUOTE: N/A	DATE: 04/25/18 DATE: 10/29/19 DRAWING / DESIGN NO: 1821681BR10	CHK BY: N/A SCALE: AS NOTED
OLD DOMINION FREIGHT LINES SANTA ROSA, CA SITE LIGHTING PLAN										