



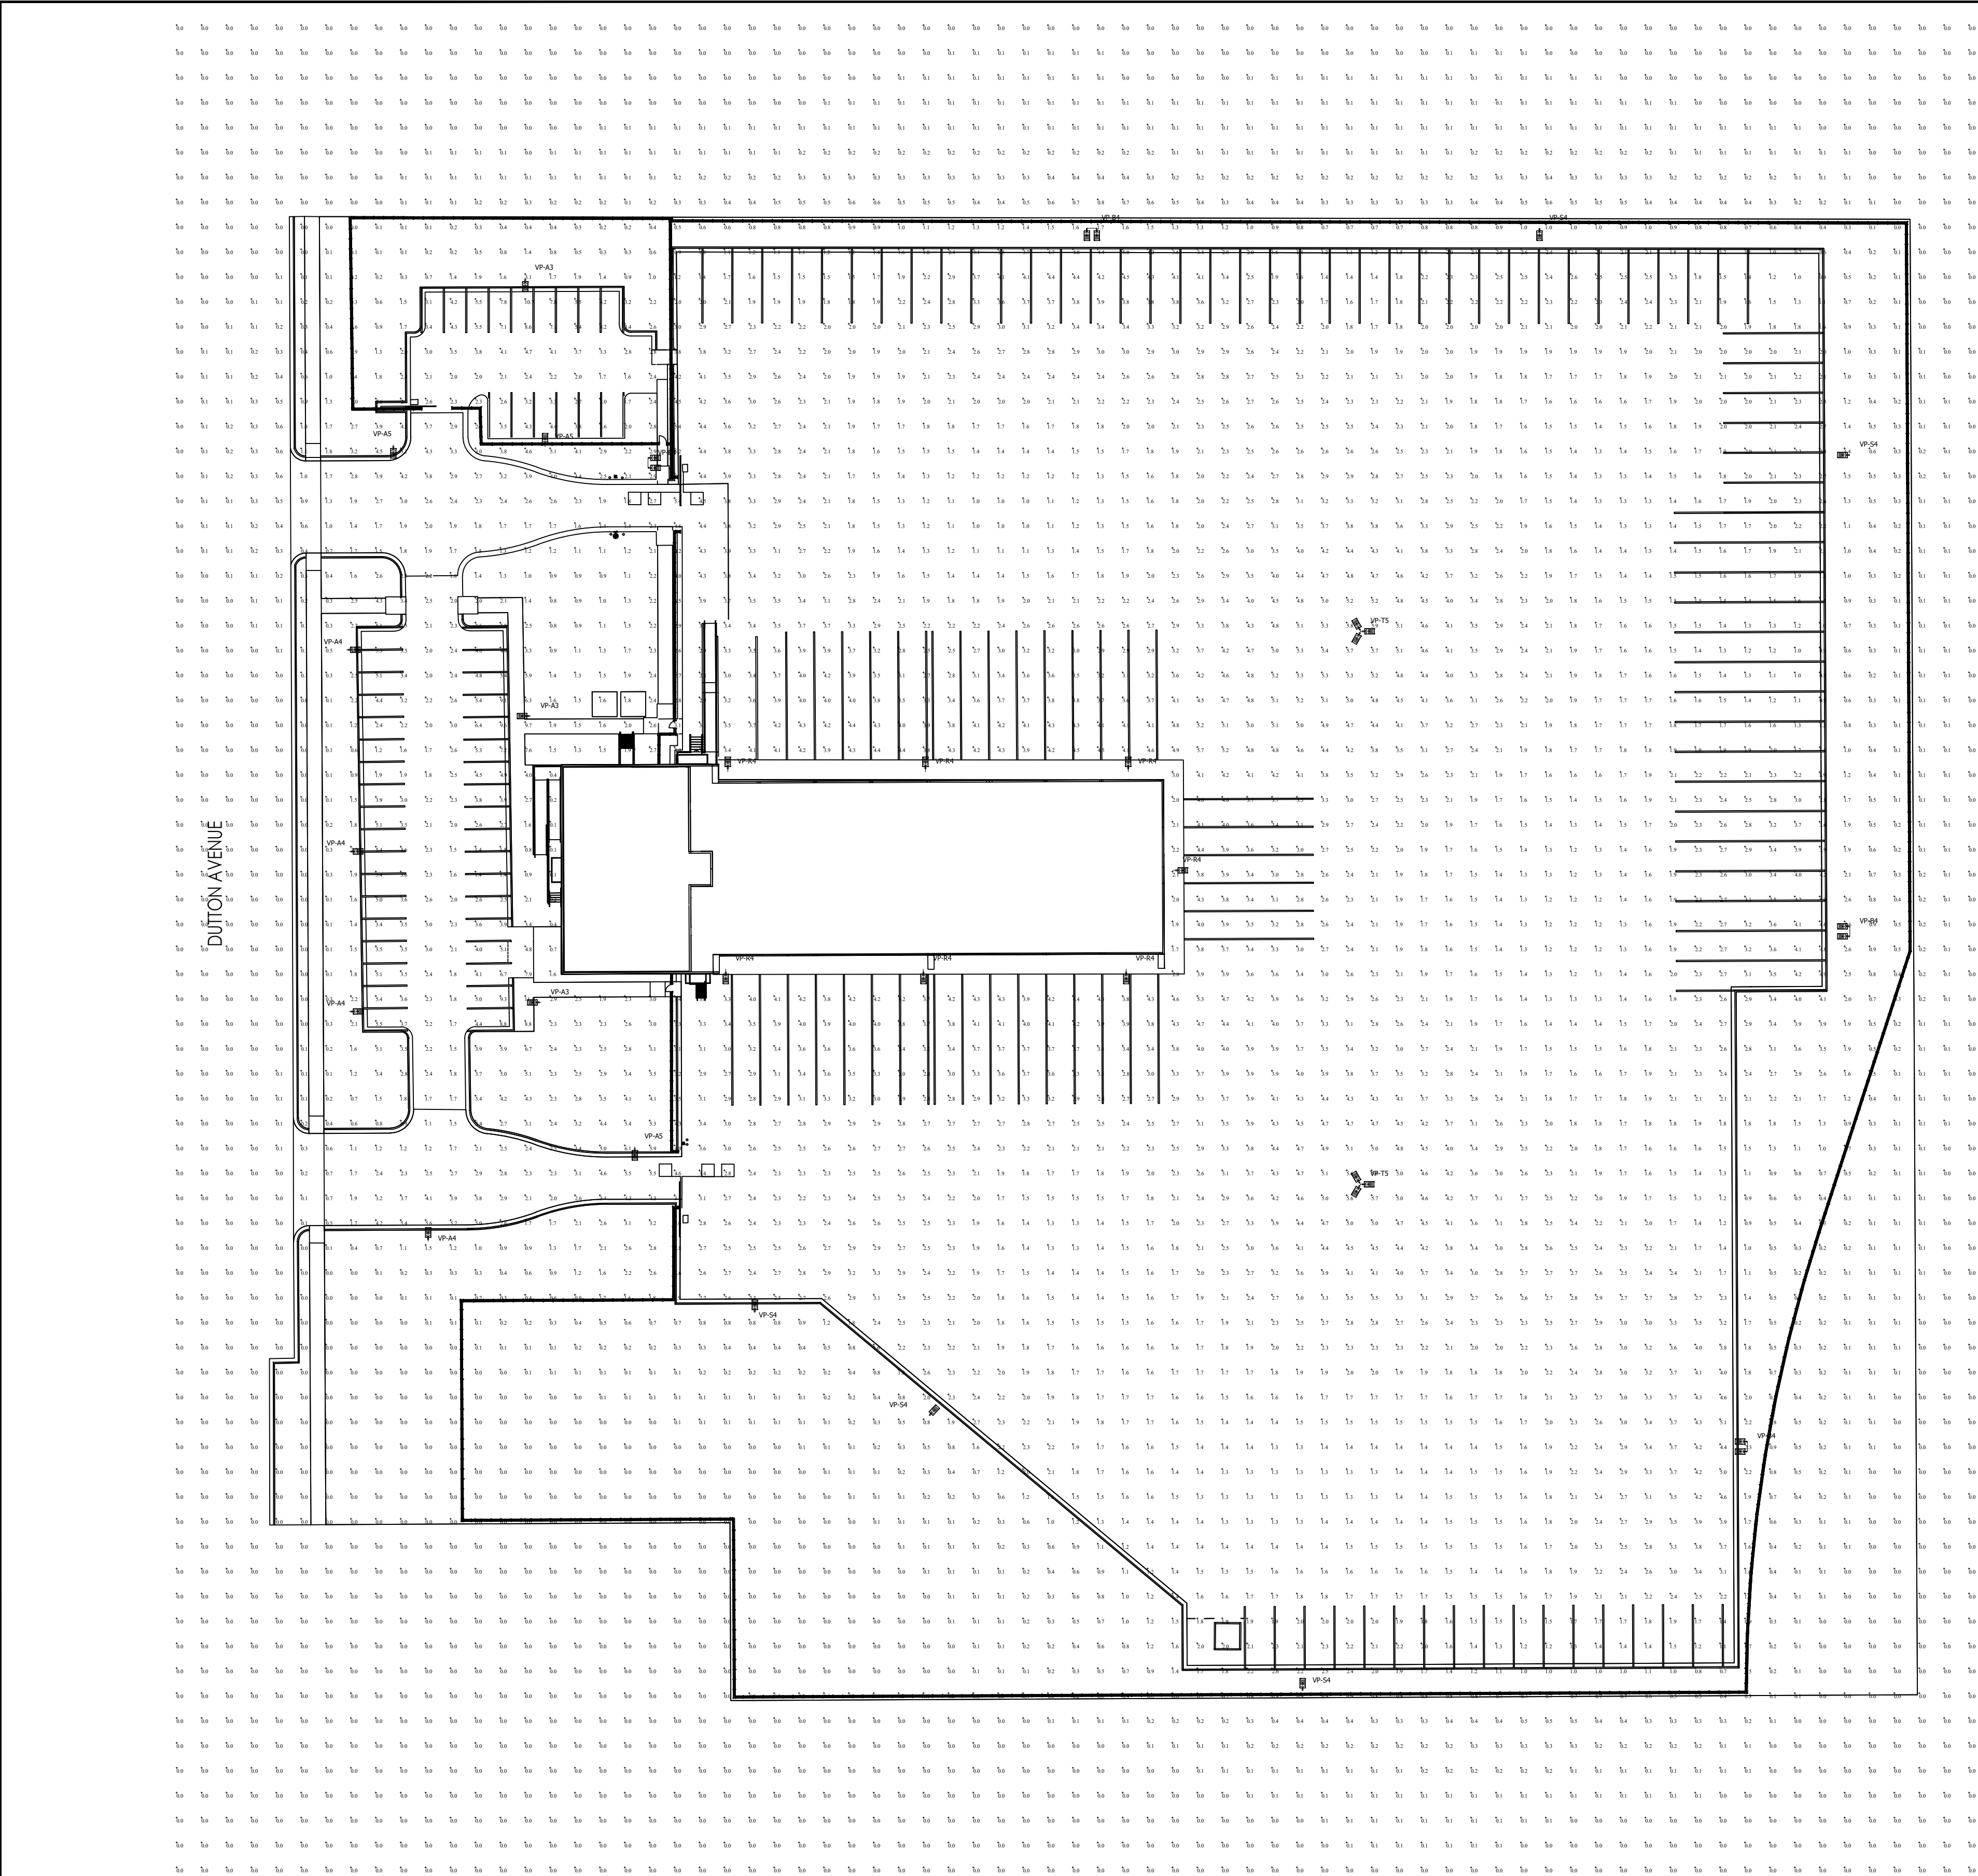

Luminaire Schedule							
Symbol	Label	Qty	Mounting Height	LLF	Watts	Lumens	Description
	VP-A3	3	16' - 0" AFG	0.900	135	17791	VP-L-64L-135-4K7-3
	VP-A4	4	16' - 0" AFG	0.900	135	10773	VP-L-64L-135-4K7-4W-BC-B
	VP-A5	3	16' - 0" AFG	0.900	135	17009	VP-L-64L-135-4K7-5W
	VP-B4	4	40' - 0" AFG	0.900	395	24737	VP-L-96L-395-4K7-4W-BC-B
	VP-R4	7	25' - 0" AFG	0.900	180	21627	VP-L-80L-180-4K7-4W
	VP-S4	5	40' - 0" AFG	0.900	395	24737	VP-L-96L-395-4K7-4W-BC-B
	VP-T5	2	40' - 0" AFG	0.900	395	39048	VP-L-96L-395-4K7-5W

Calculation Summary							
Label	CalcType	Units	Avg	Max	Min	Avg/Min	Max/Min
Employee Lot	Illuminance	Fc	3.20	10.7	1.1	2.91	9.73
Overall Area	Illuminance	Fc	1.41	11.1	0.0	N.A.	N.A.
Terminal Lot	Illuminance	Fc	2.54	5.9	1.0	2.54	5.90

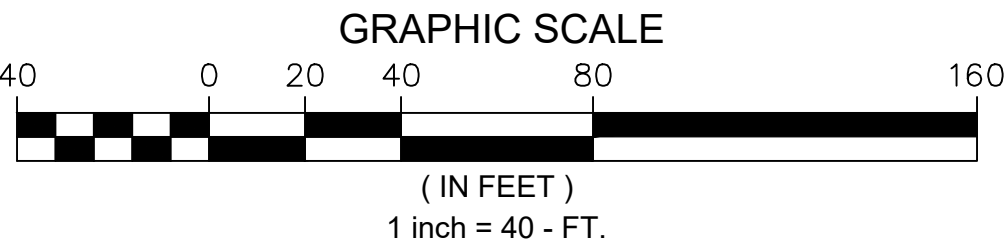

1. THIS LIGHTING DESIGN IS BASED ON LIMITED INFORMATION SUPPLIED BY OTHERS TO HUBBELL LIGHTING. SITE DETAILS PROVIDED HEREON ARE REPRODUCED ONLY AS A VISUALIZATION AID. FIELD DEVIATIONS MAY SIGNIFICANTLY AFFECT PREDICTED PERFORMANCE. PRIOR TO INSTALLATION, CRITICAL SITE INFORMATION (POLE LOCATIONS, ORIENTATION, MOUNTING HEIGHT, ETC.) SHOULD BE COORDINATED WITH THE CONTRACTOR AND/OR SPECIFIER RESPONSIBLE FOR THE PROJECT.

2. LUMINAIRE DATA IS TESTED TO INDUSTRY STANDARDS UNDER LABORATORY CONDITIONS. OPERATING VOLTAGE AND NORMAL MANUFACTURING TOLERANCES OF LAMP, BALLAST, AND LUMINAIRE MAY AFFECT FIELD RESULTS.

3. CONFORMANCE TO FACILITY CODE AND OTHER LOCAL REGULATIONS IS THE RESPONSIBILITY OF THE OWNER AND/OR THE OWNER'S REPRESENTATIVE.

TABLE:

OLD DOMINION FREIGHT LINES
SANTA ROSA, CA
SITE LIGHTING PLAN

REVISED FROM DRAWING NUMBER(S):	
R1: 06/04/18	R5: 10/04/19
R2: 01/07/19	R6: 10/07/19
R3: 09/24/19	
R4: 10/02/19	



Hubbell Lighting, Inc.
701 MILLENNIUM BLVD.
GREENVILLE, SC 29607

DN BY: DHK	DATE: 04/25/18	CHK BY: N/A
REV BY: DHK	DATE: 10/07/19	SCALE: AS NOTED
QUOTE: N/A	DRAWING / DESIGN NO.: 1821681R6	