

RECEIVED
By Andrew Trippel at 4:38 pm, Feb 19, 2020

38 DEGREES NORTH

SANTA ROSA, CA


INDEX OF SHEETS	
VICINITY MAP	
A-2	20-PLEX FLOORPLANS
A-3	20-PLEX FLOORPLANS
A-4	20-PLEX ELEVATIONS
A-5	24-PLEX FLOORPLANS
A-6	24-PLEX FLOORPLANS
A-7	24-PLEX ELEVATIONS
A-8	CLUBHOUSE FLOORPLANS
A-9	CLUBHOUSE FLOORPLANS
A-10	CLUBHOUSE ELEVATIONS
A-11	BUILDING SECTIONS
A-12	BUILDING SECTIONS
A-13	TYPICAL WALL SECTION
A-14	MATERIAL BOARD
A-15	PARTIAL SHADOW STUDY
A-16	VIEWSHED EXHIBIT
A-17	STREET VIEW MASSING EXHBIT
A-18	PERSPECTIVE: 24-PLEX FRONT & CLUBHOUSE
A-19	PERSPECTIVE: 24-PLEX FRONT
A-20	PERSPECTIVE: 24-PLEX FRONT
A-21	PERSPECTIVE: 20-PLEX FRONT
A-22	PERSPECTIVE: 20-PLEX FRONT
A-23	PERSPECTIVE: 24-PLEX BACK
A-24	PERSPECTIVE: 20-PLEX BACK
A-25	PERSPECTIVE: CLUBHOUSE
A-26	PERSPECTIVE: CLUBHOUSE
A-27	PERSPECTIVE: CLUBHOUSE
L1	LANDSCAPE PLAN
L2	PLANT LEGEND
L3	AMENITY PLAN PHASES 1 & 2
L4	SITE AMENITIES IMAGERY
L5	PLANT IMAGE BOARD
L6	PLANT IMAGE BOARD
L7	PRELIMINARY IRRIGATION PLAN
L8	PRELIMINARY IRRIGATION PLAN
C1.0	PRELIMINARY SITE PLAN
C1.1	PRELIMINARY PARKING SCHEDULE
C1.2	PRELIMINARY PEDESTRIAN ROUTE AND BIKE PLAN
C1.3	PRELIMINARY TRASH ENCLOSURE PLAN
C2.0	PRELIMINARY UTILITY PLAN
C2.1	PRELIMINARY FIRE ACCESS PLAN
C3.0	PRELIMINARY GRADING PLAN
C3.1	PRELIMINARY GRADING SECTIONS
C4.0	PRELIMINARY ROAD FRONTAGE PLAN
C4.1	PRELIMINARY ROAD PLAN YOLANDA AVENUE
C4.2	PRELIMINARY ROAD FRONTAGE SECTIONS
C5.0	PRELIMINARY NEIGHBORHOOD CONTEXT MAP
E1	LIGHTING FIXTURE SCHEDULE AND POLE DETAIL
E2.1	PARTIAL SITE LIGHTING PLAN
E2.2	PARTIAL SITE LIGHTING PLAN
E3.1	PARTIAL SITE PHOTOMETRIC PLAN
E3.2	PARTIAL SITE PHOTOMETRIC PLAN
E4.1	PROPOSED LIGHTING CUTSHEETS
E4.2	PROPOSED LIGHTING CUTSHEETS




12555 WEST JEFFERSON BLVD.,
SUITE 100
LOS ANGELES, CA 90066
310.394.2523
www.kitgy.com

ARCHITECTURAL CONCEPT PACKAGE

JANUARY 28, 2020
#181100

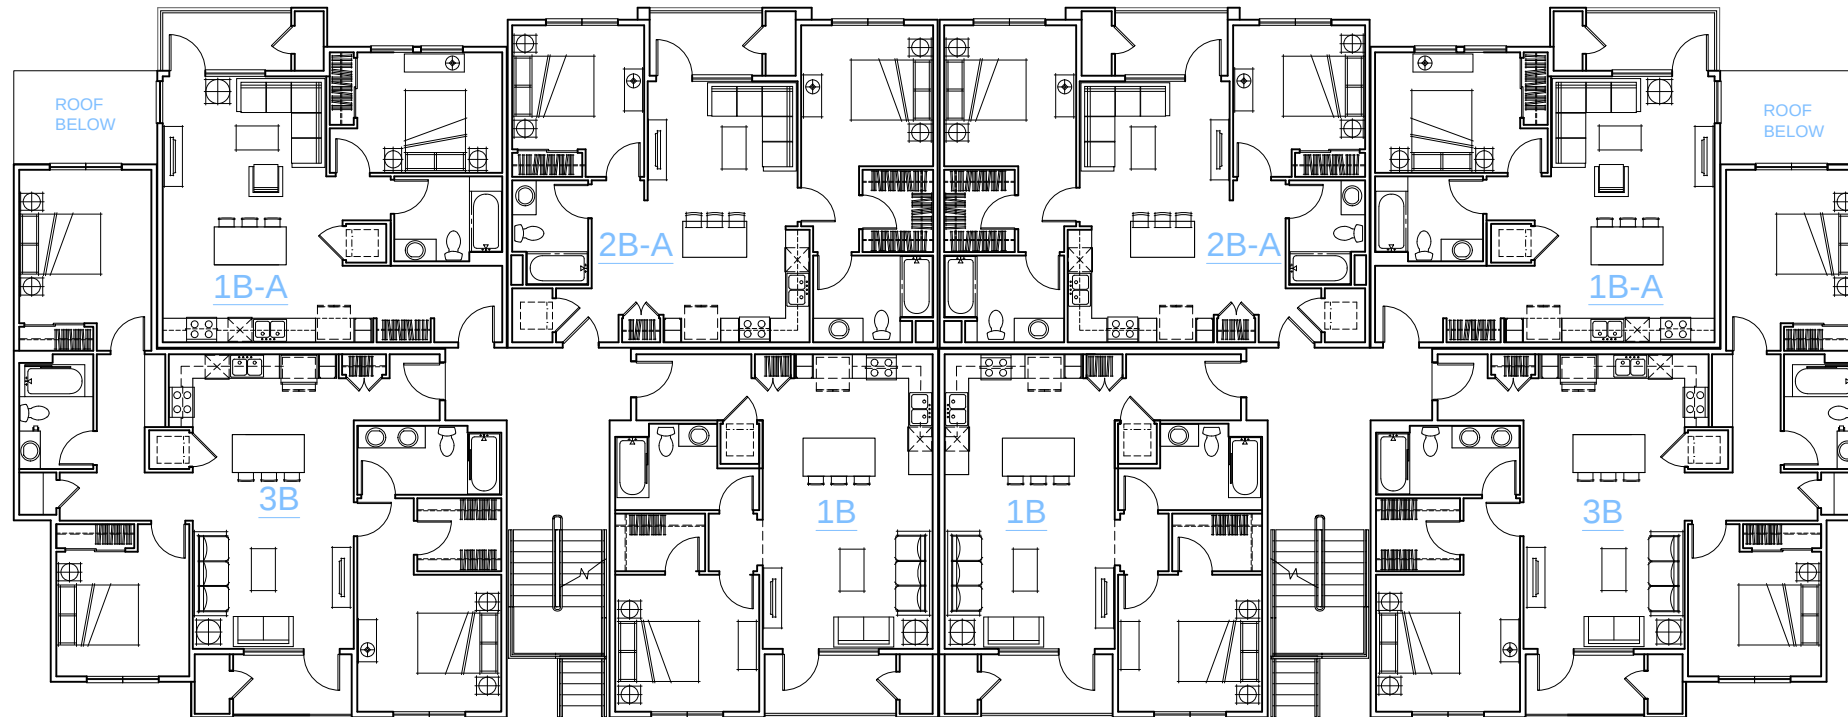

2ND FLOOR
SCALE : 1/8" = 1'-0"

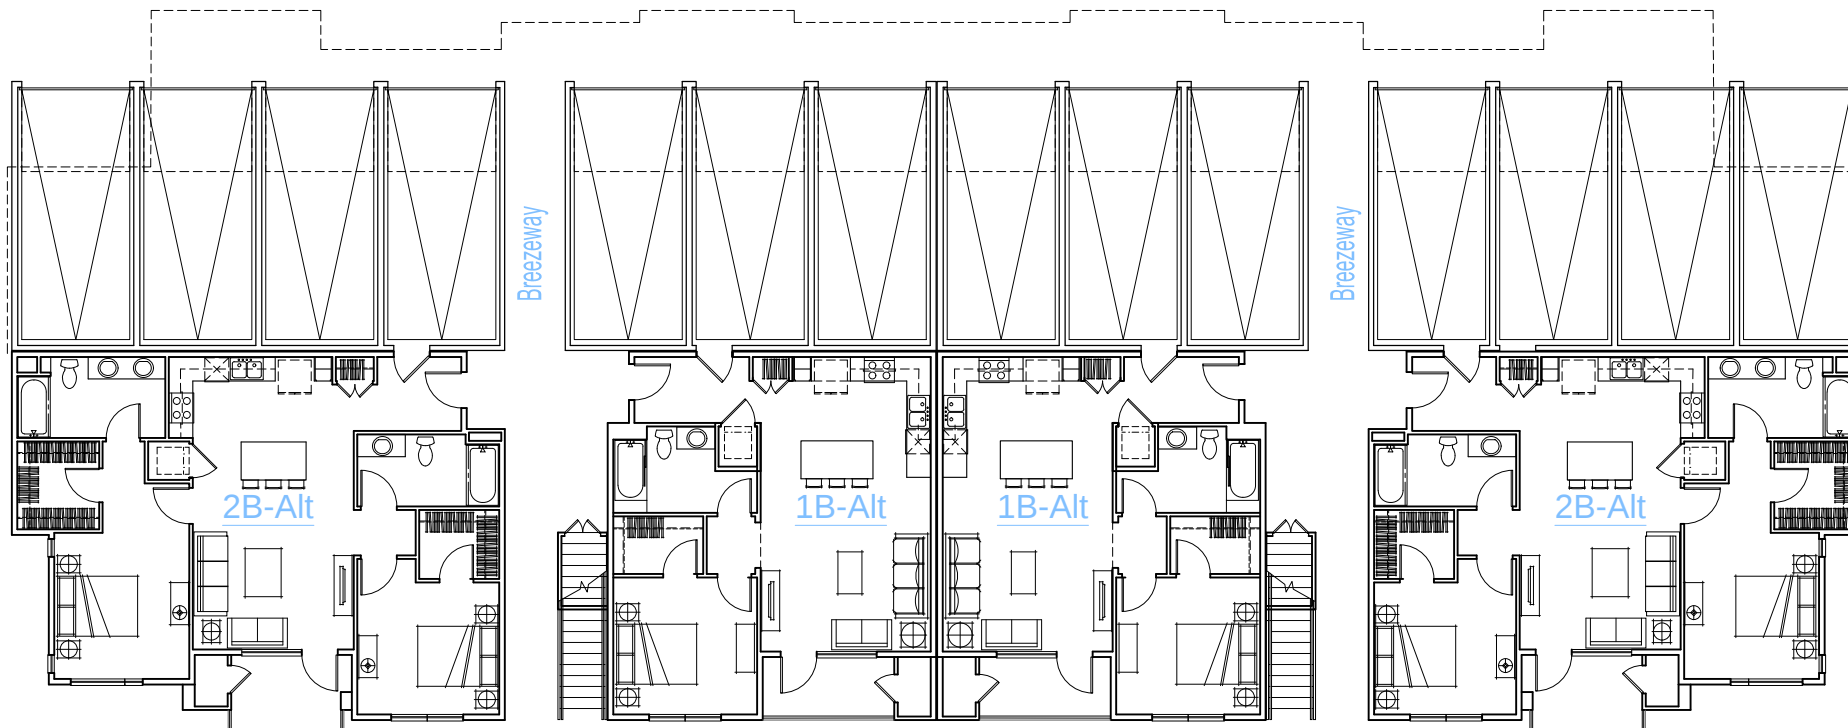

GROUND FLOOR
SCALE : 1/8" = 1'-0"

20 PLEX

MIX BY UNIT TYPE

1Bedrooms	10
2Bedrooms	8
3Bedrooms	2

1B/1B_Alt	754 SF	(Balcony 76 SF)
1B-A/1B-A_Alt	702 SF	(Balcony 73 SF)
2B-A/2B-A_Alt	930 SF	(Balcony 65 SF)
2B-A	1073 SF	(Balcony 70 SF)
3B	1259 SF	(Balcony 70 SF)

PROVIDED PARKING: 14 stalls



Architecture + Planning
888.456.5849
ktgy.com

KENNEDY WILSON
151 S. El Camino Dr.
Beverly Hills, CA 90212


38 DEGREES NORTH

Santa Rosa, CA KTGY# 2018-1100


ARCH CONCEPT PACKAGE

JANUARY 28, 2020

20-PLEX FLOORPLANS

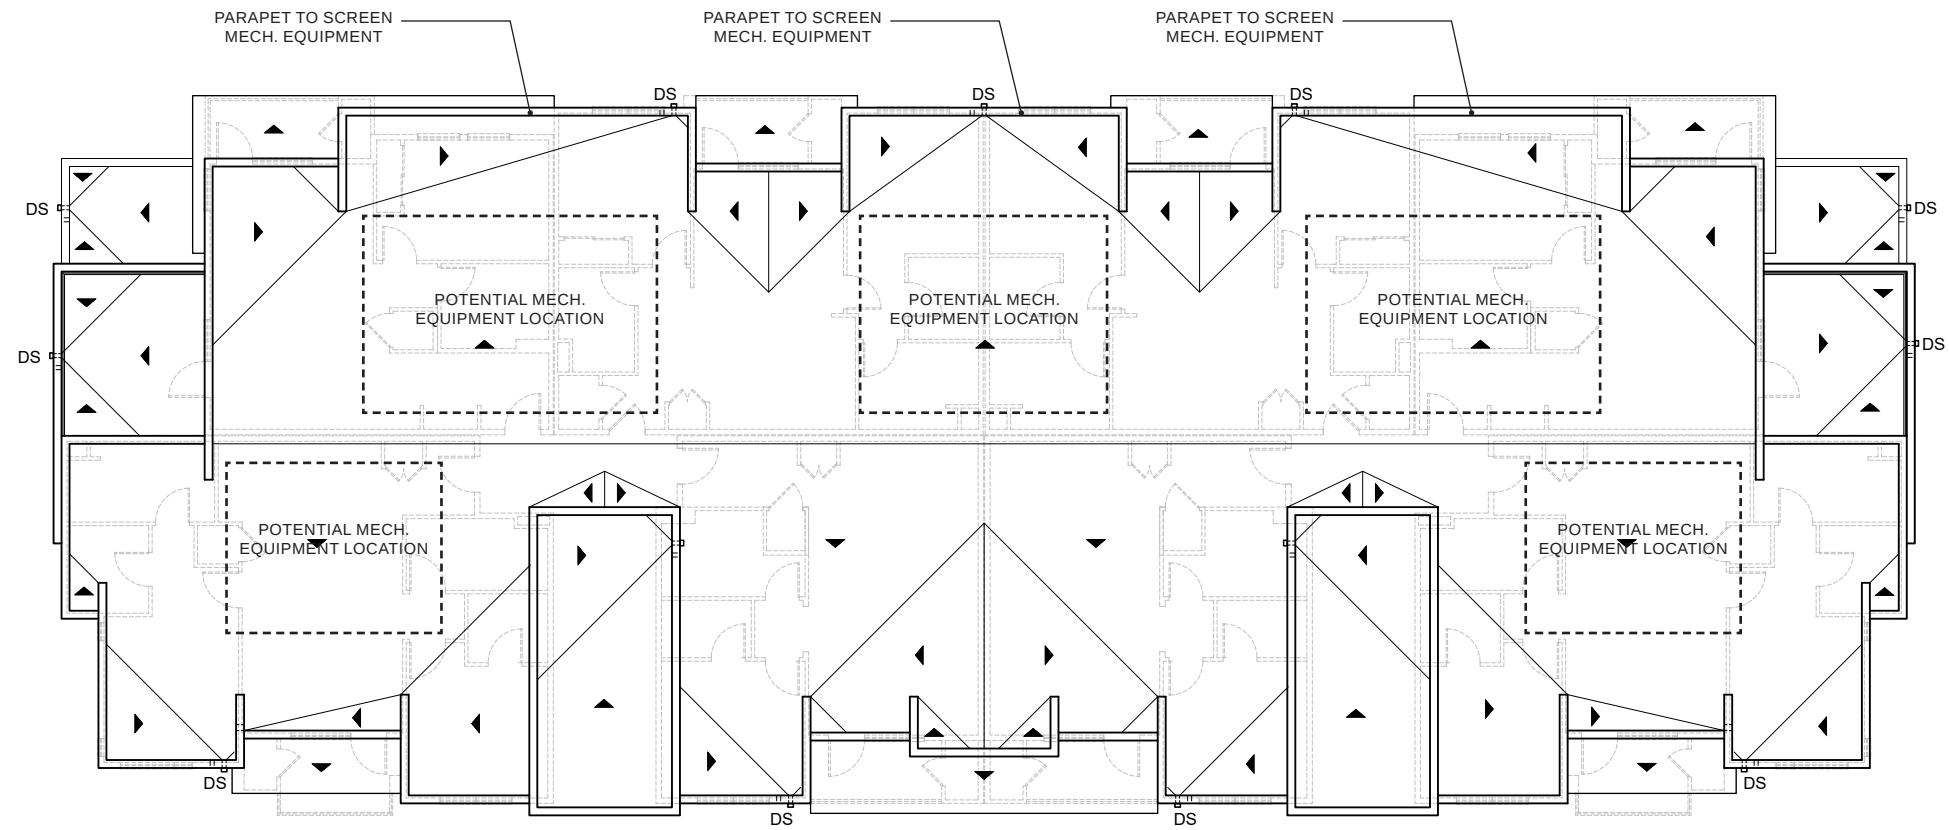

ROOF PLAN
SCALE : 1/8" = 1'-0"

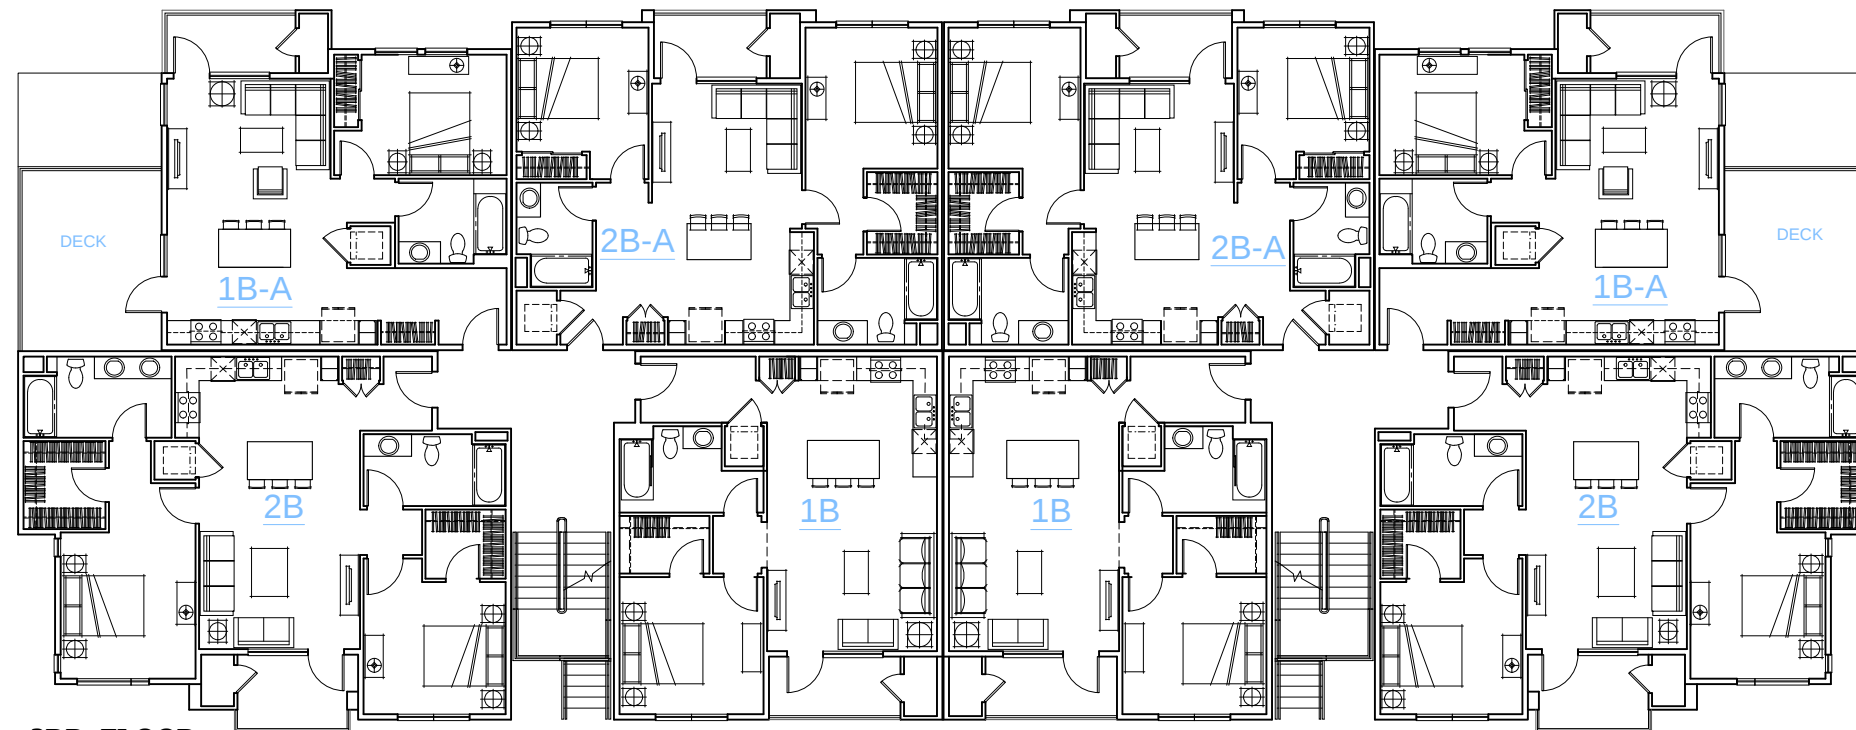

3RD FLOOR
SCALE : 1/8" = 1'-0"



FRONT



RIGHT

 


REAR



LEFT

20-PLEX




Architecture + Planning
888.456.5849
ktgy.com


KENNEDY WILSON
151 S. El Camino Dr.
Beverly Hills, CA 90212

38 DEGREES NORTH
Santa Rosa, CA KTGY# 2018-1100

ARCH CONCEPT PACKAGE
JANUARY 28, 2020

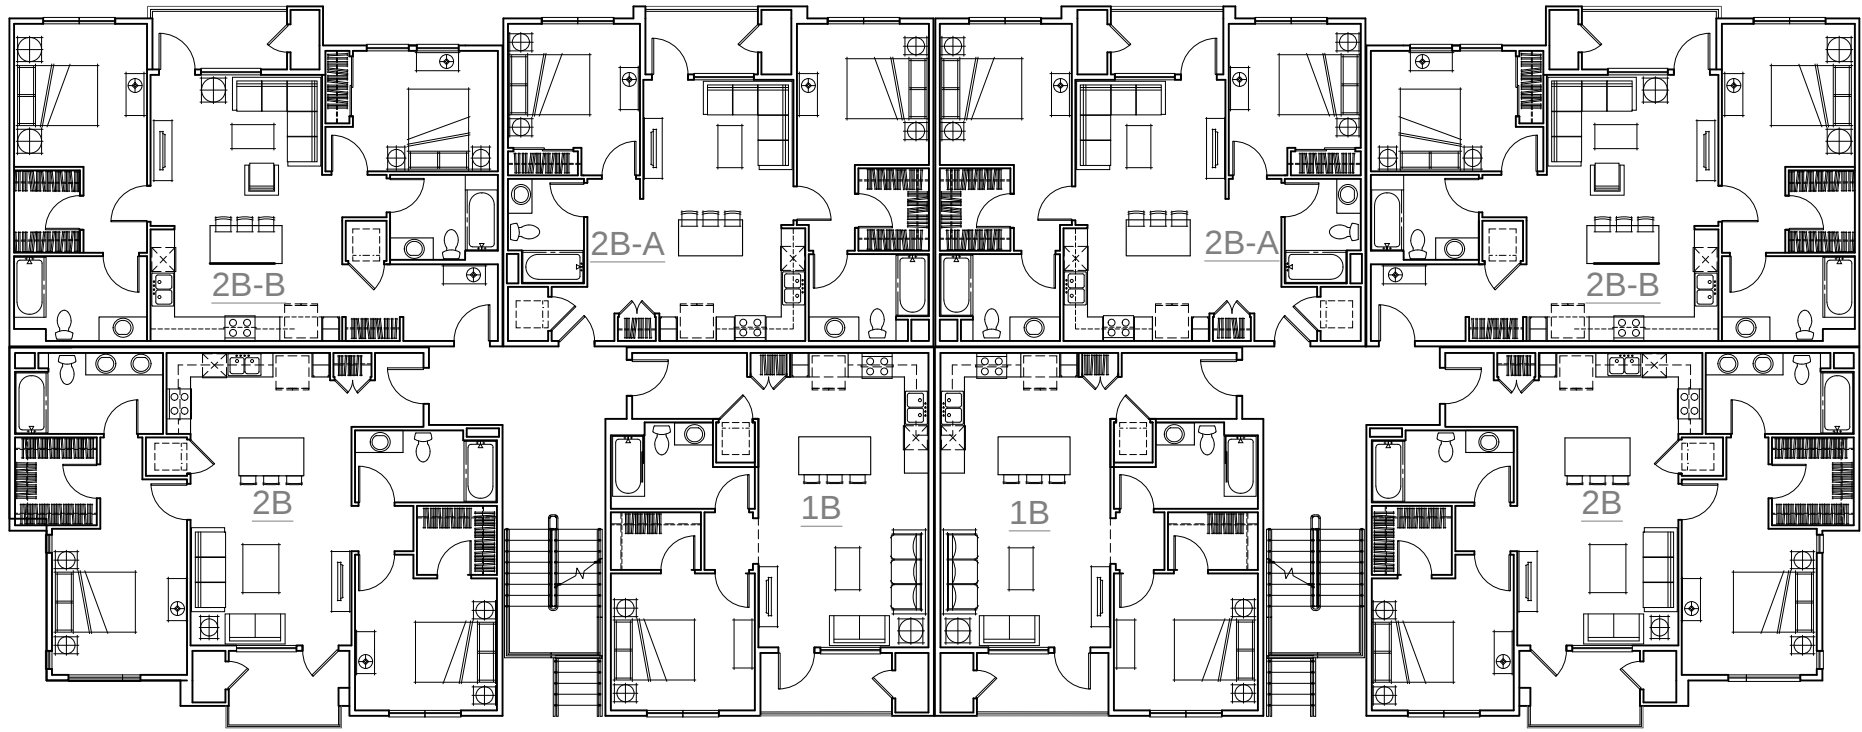

2ND FLOOR
 SCALE : 1/8" = 1'-0"

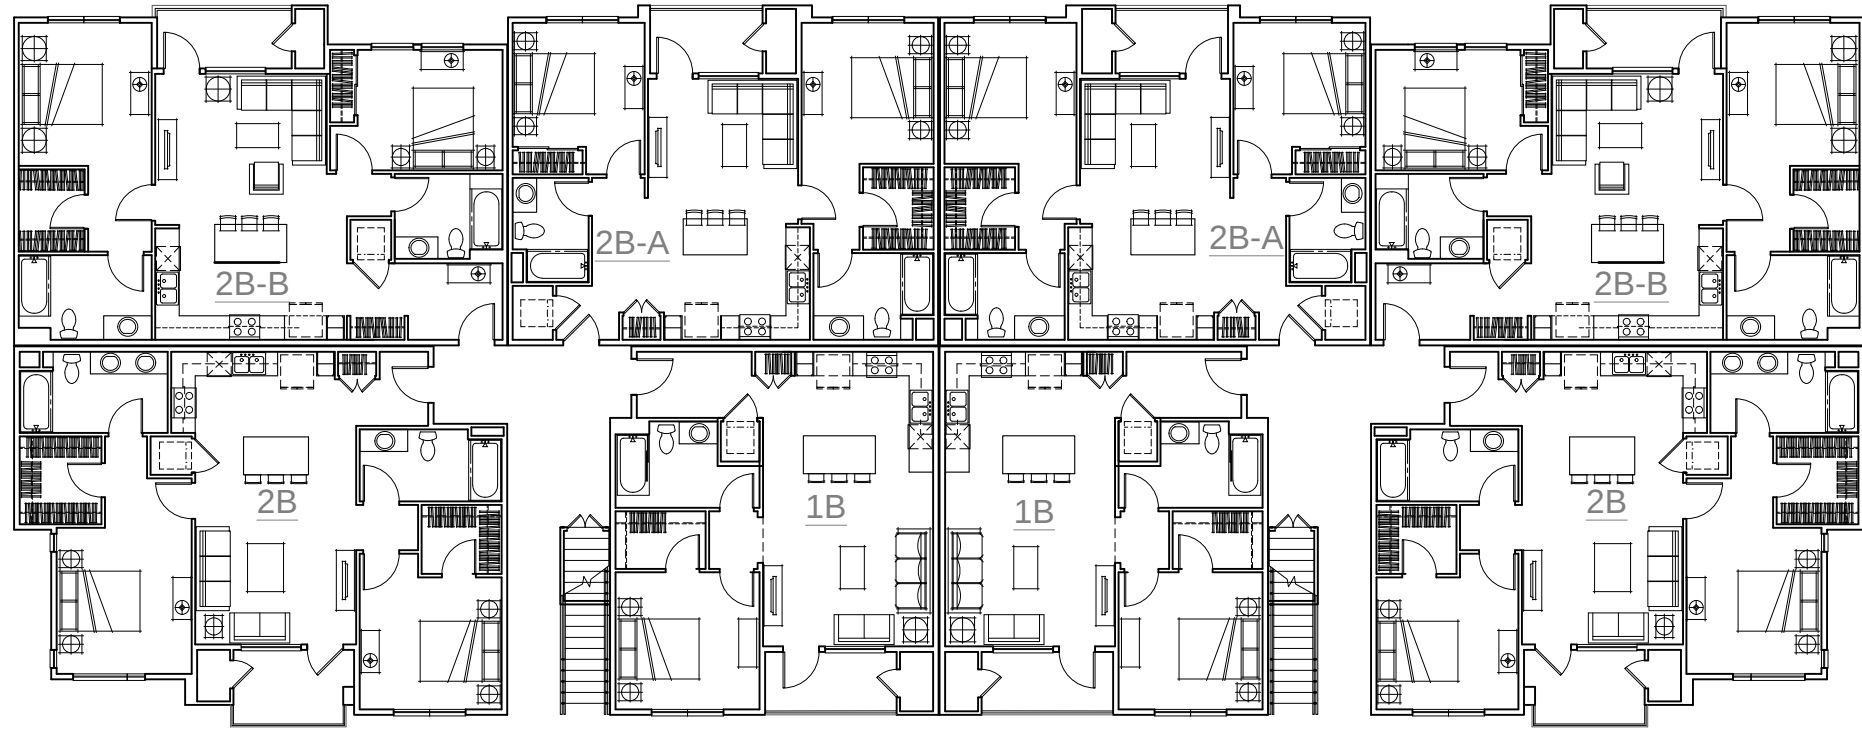


GROUND FLOOR
 SCALE : 1/8" = 1'-0"


24 PLEX MIX BY UNIT TYPE

1Bedrooms 10
 2Bedrooms 14

1B/1B_Alt	754 SF	(Balcony 76 SF)
1B-A/1B-A_Alt	702 SF	(Balcony 73 SF)
2B-A/2B-A_Alt	930 SF	(Balcony 65 SF)
2B	1073 SF	(Balcony 70 SF)
2B-B	1029 SF	(Balcony 73 SF)

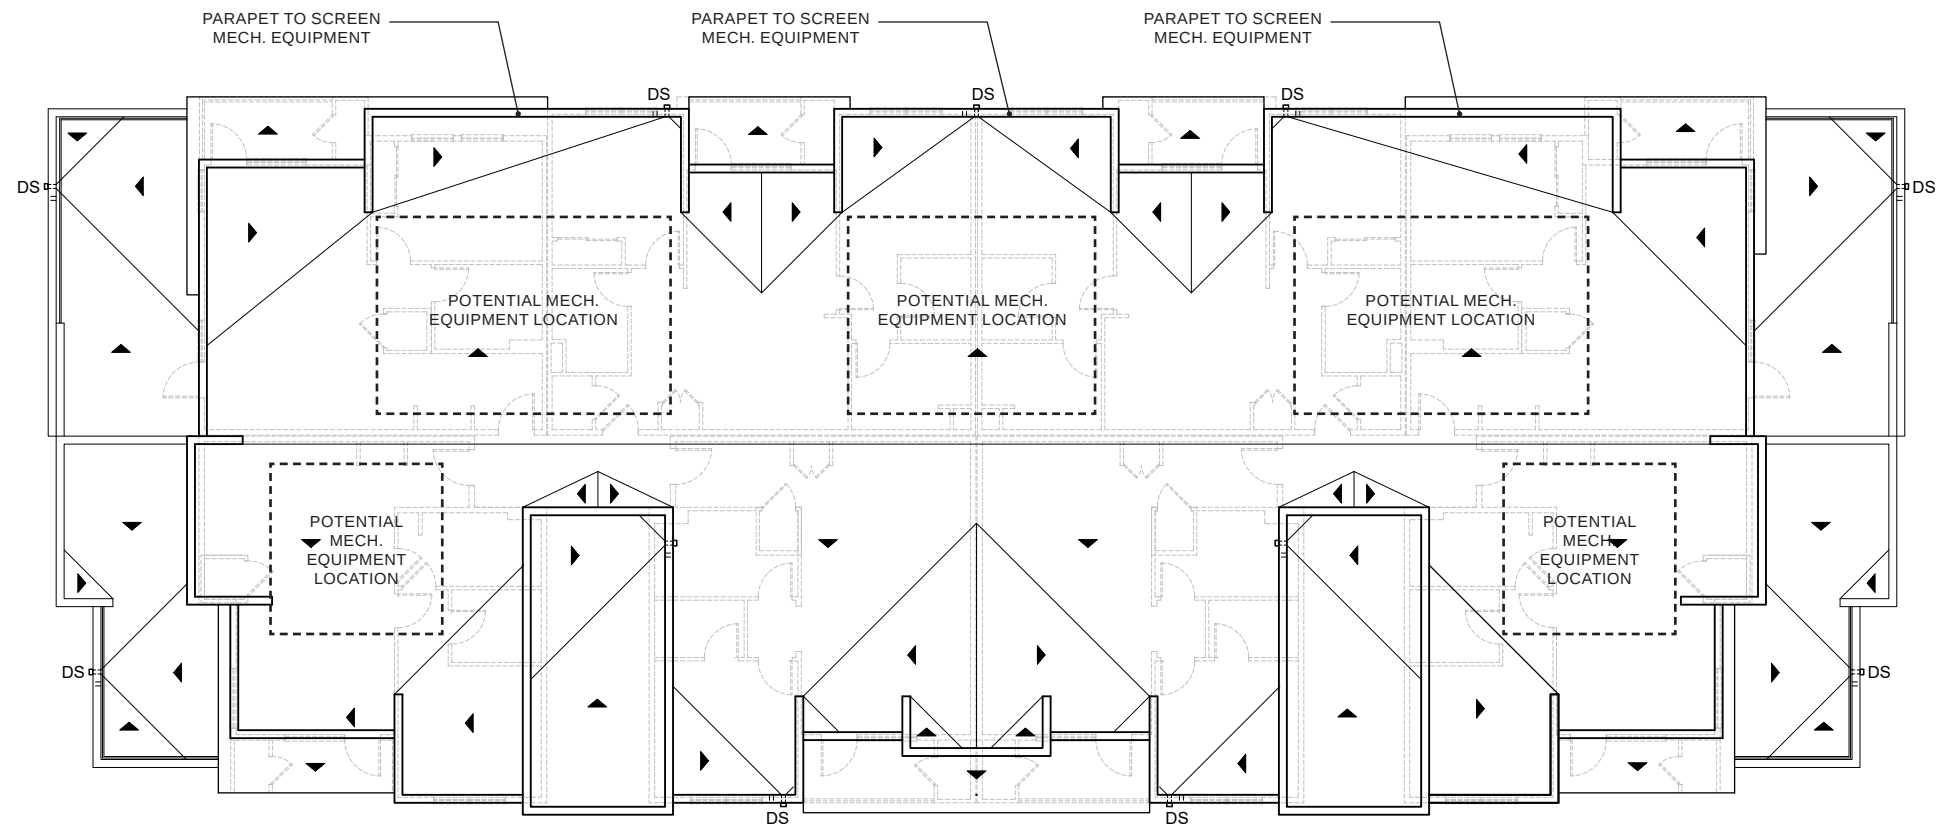

ROOF PLAN
SCALE : 1/8" = 1'-0"

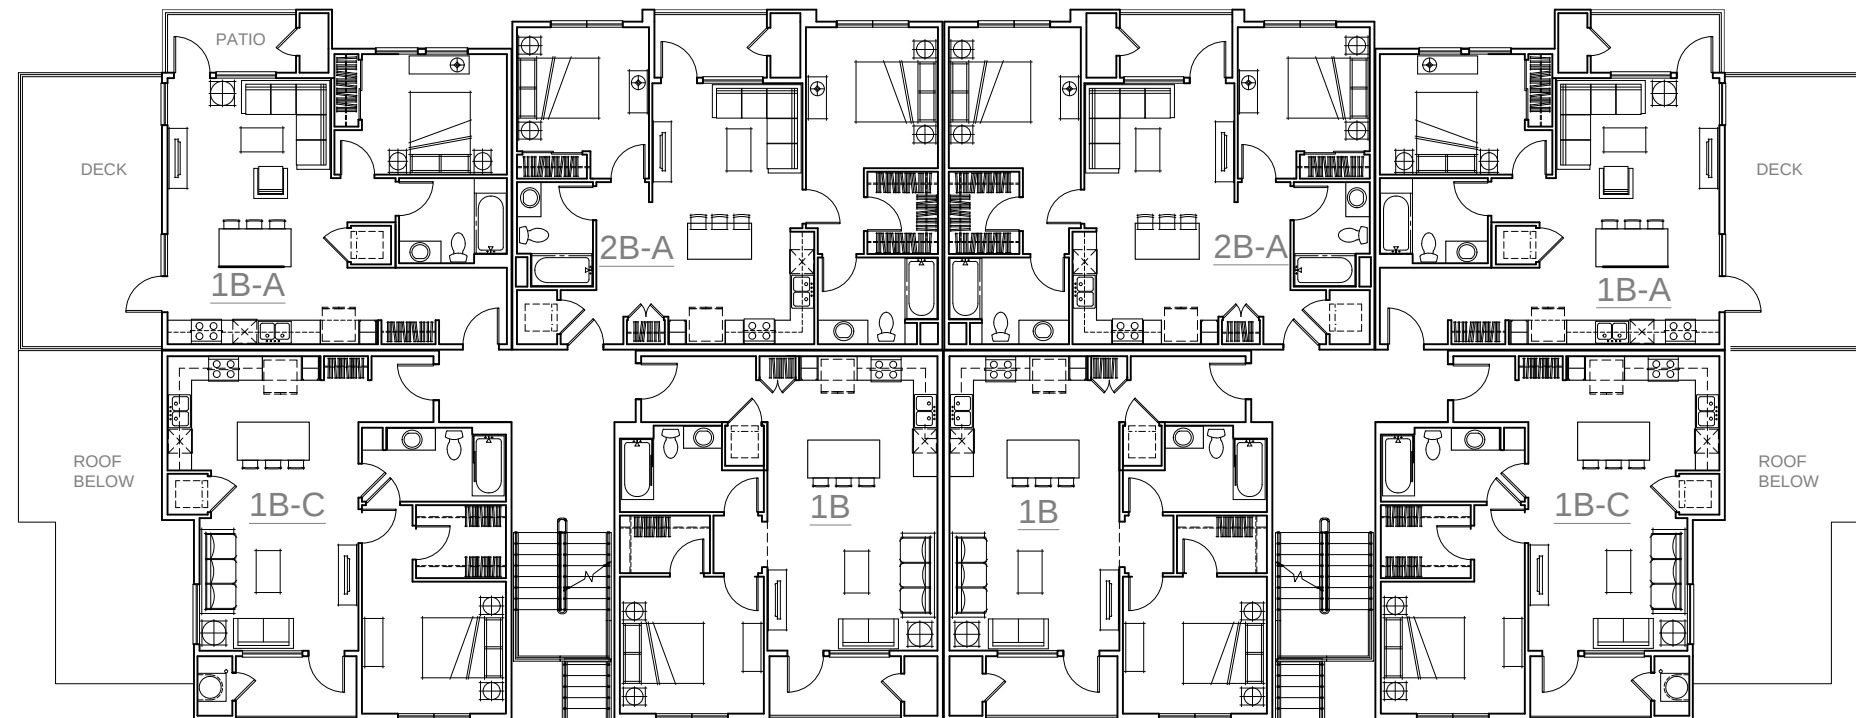

3RD FLOOR
SCALE : 1/8" = 1'-0"



FRONT



RIGHT



REAR



LEFT

24-PLEX



Architecture + Planning
888.456.5849
ktgy.com


KENNEDY WILSON
151 S. El Camino Dr.
Beverly Hills, CA 90212

38 DEGREES NORTH
Santa Rosa, CA KTGY# 2018-1100

ARCH CONCEPT PACKAGE
JANUARY 28, 2020


24-PLEX ELEVATIONS

A - 7

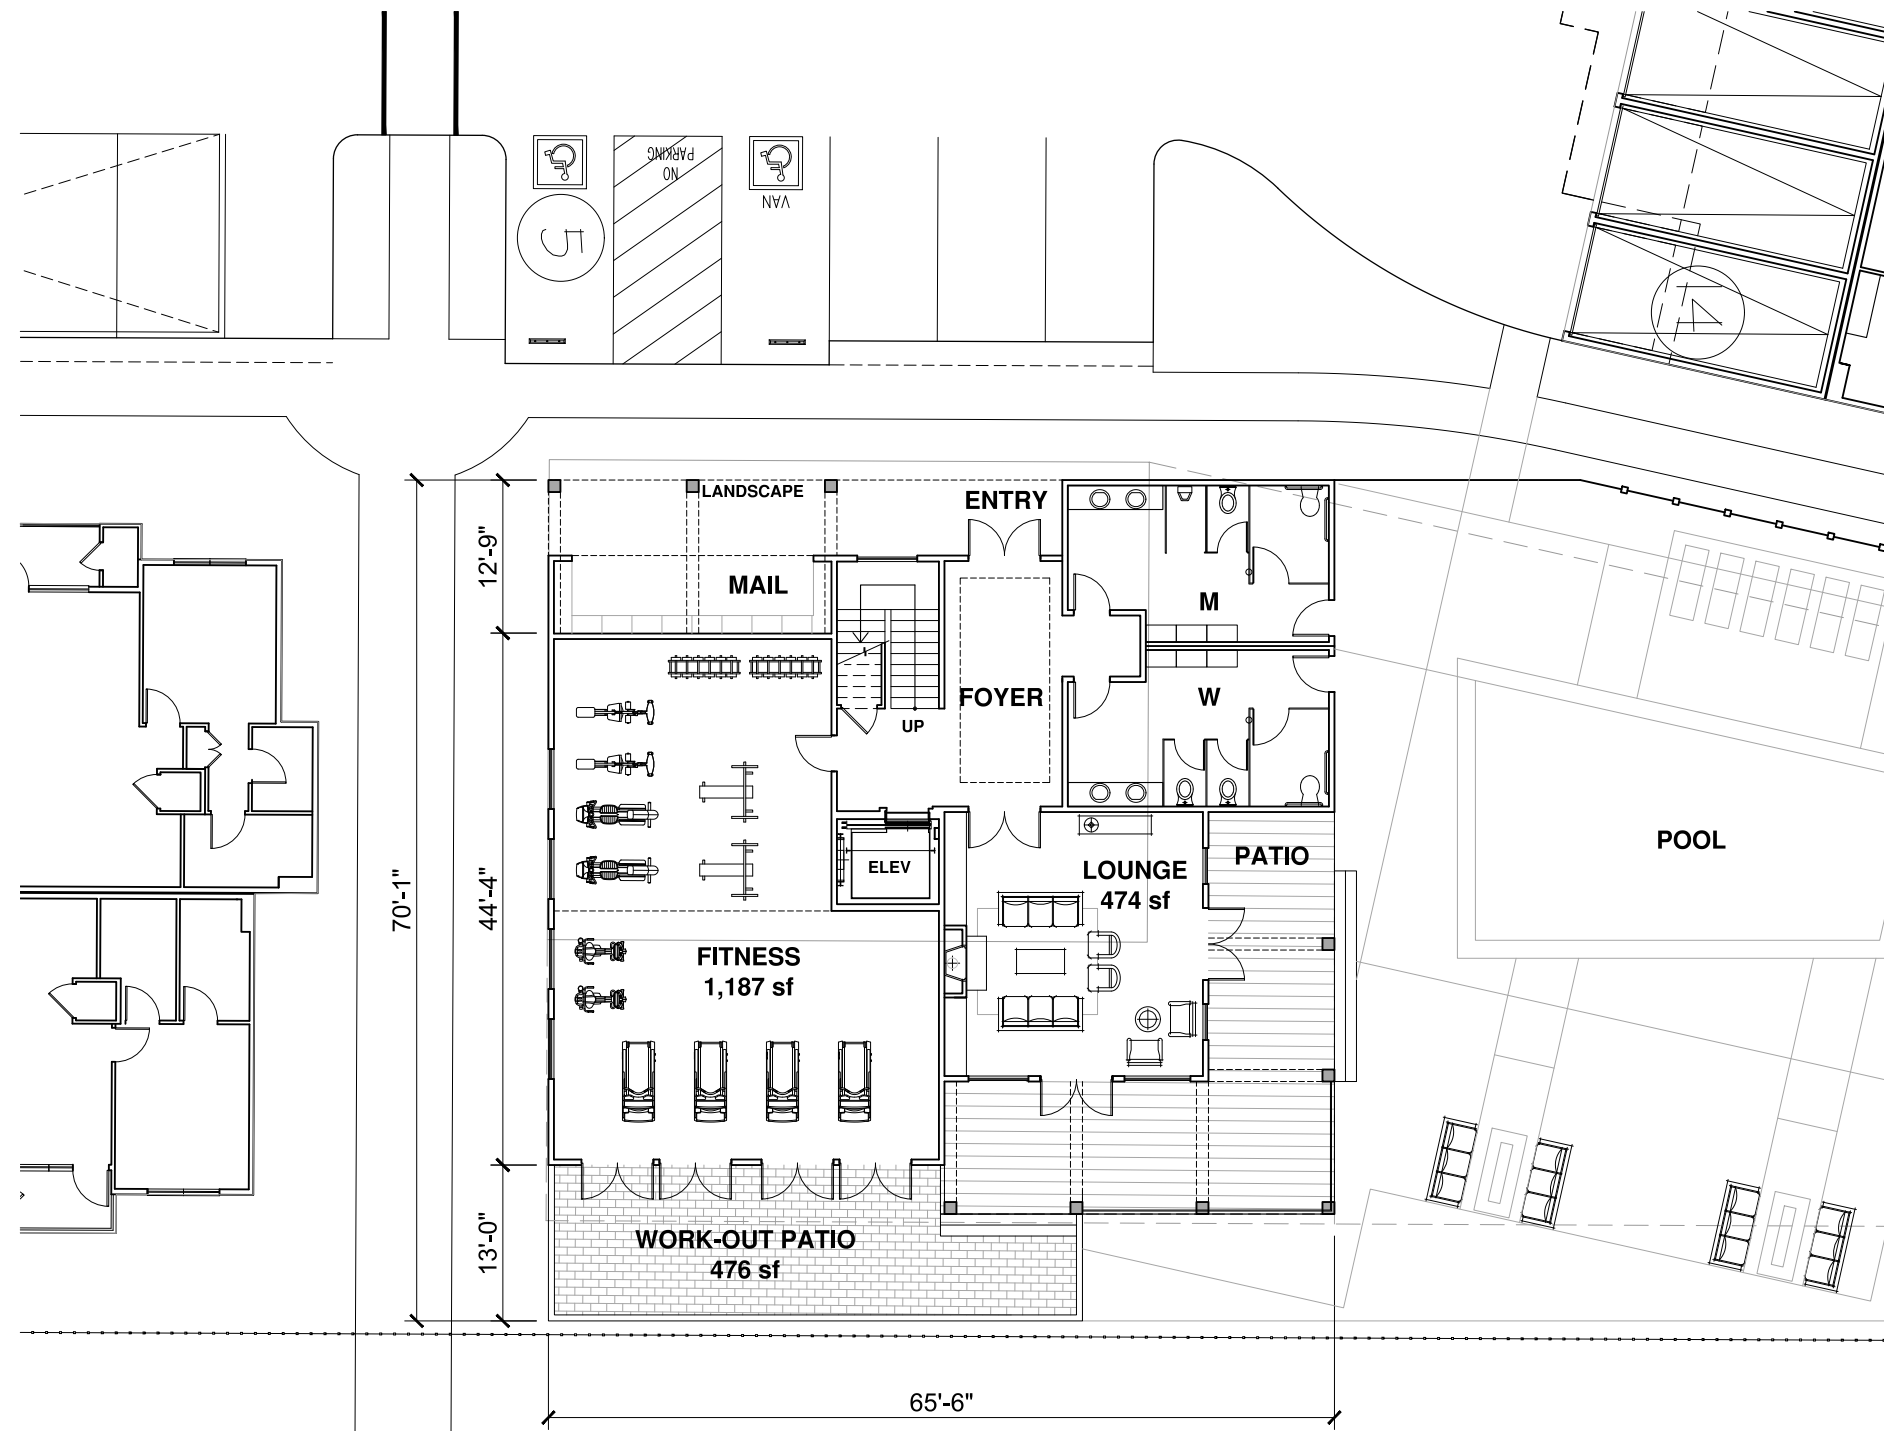


**CLUBHOUSE
LEVEL 1
2,654 sf**

**OPEN SPACE
PRESERVE**

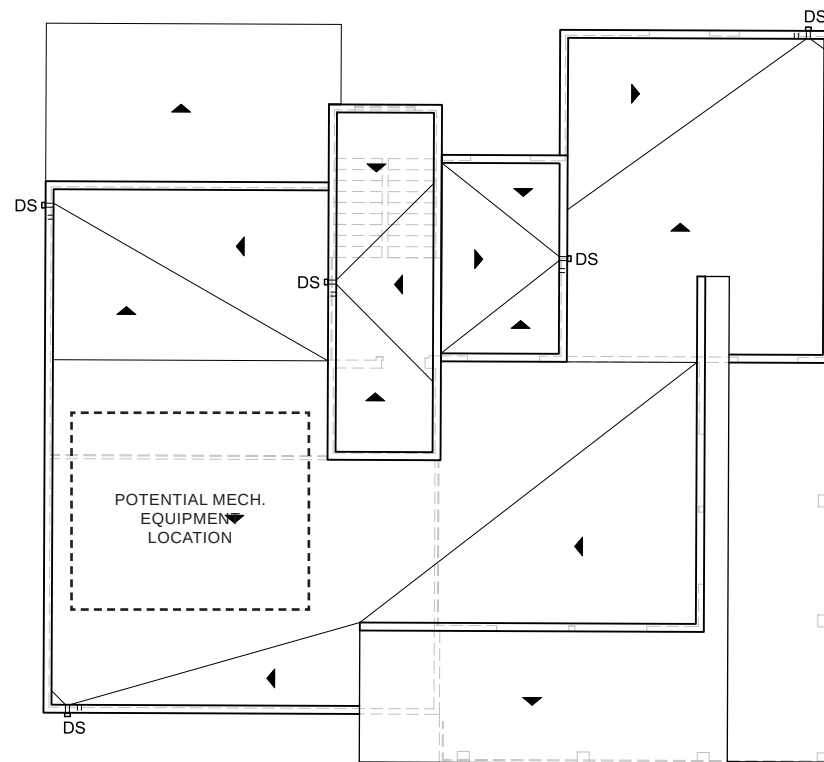

**CLUBHOUSE
ROOF PLAN**

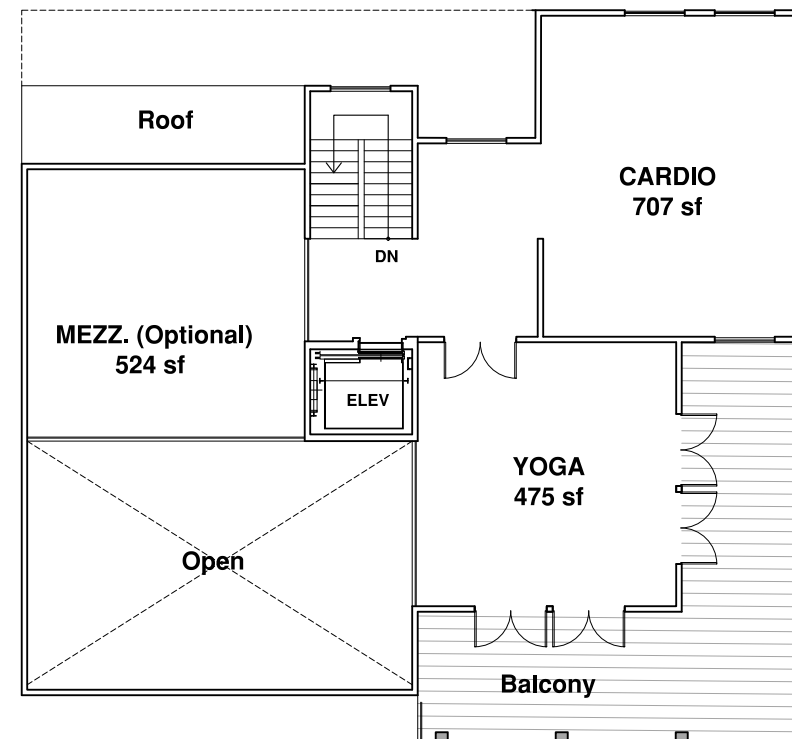


**CLUBHOUSE
LEVEL 2
1,500 sf**



FRONT




RIGHT

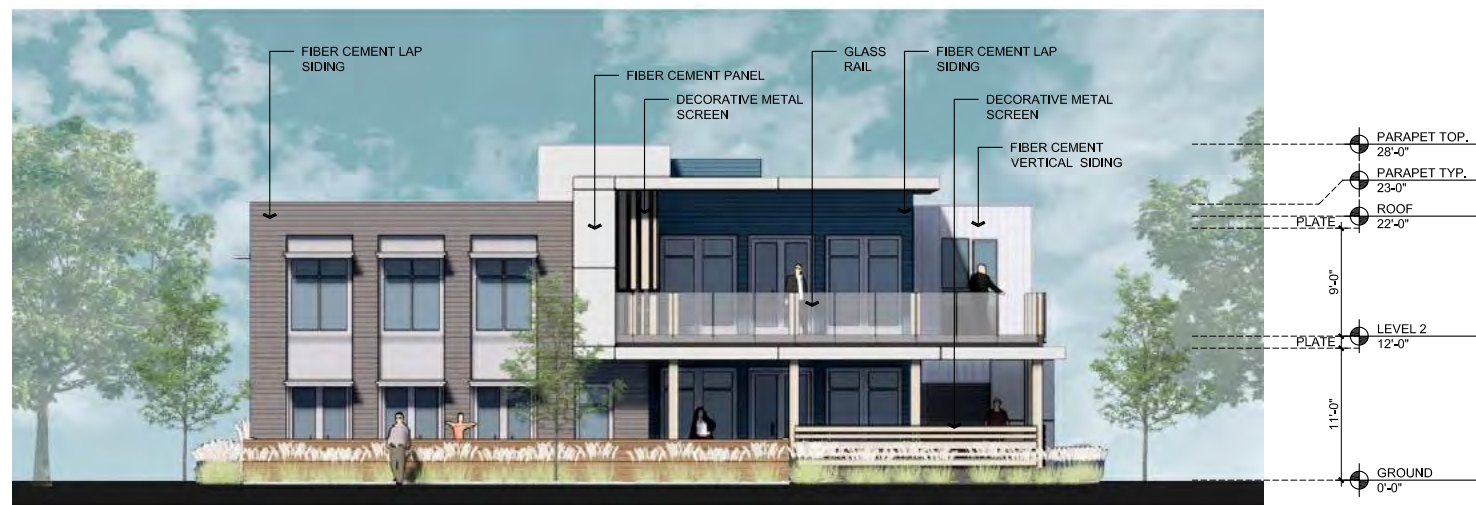

REAR



 LEFT



CLUBHOUSE



Architecture + Planning
888.456.5849
ktgy.com

KENNEDY WILSON
151 S. El Camino Dr.
Beverly Hills, CA 90212

38 DEGREES NORTH


Santa Rosa, CA KTGY# 2018-1100

ARCH CONCEPT PACKAGE


JANUARY 28, 2020

CLUBHOUSE ELEVATIONS


A - 10

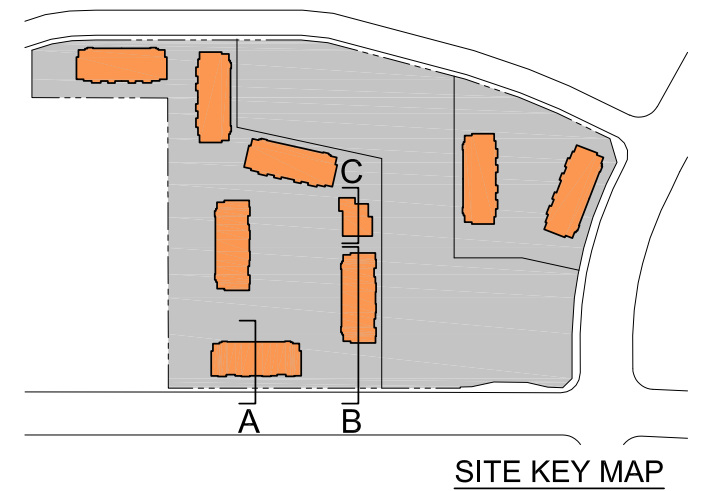


SITE KEY MAP

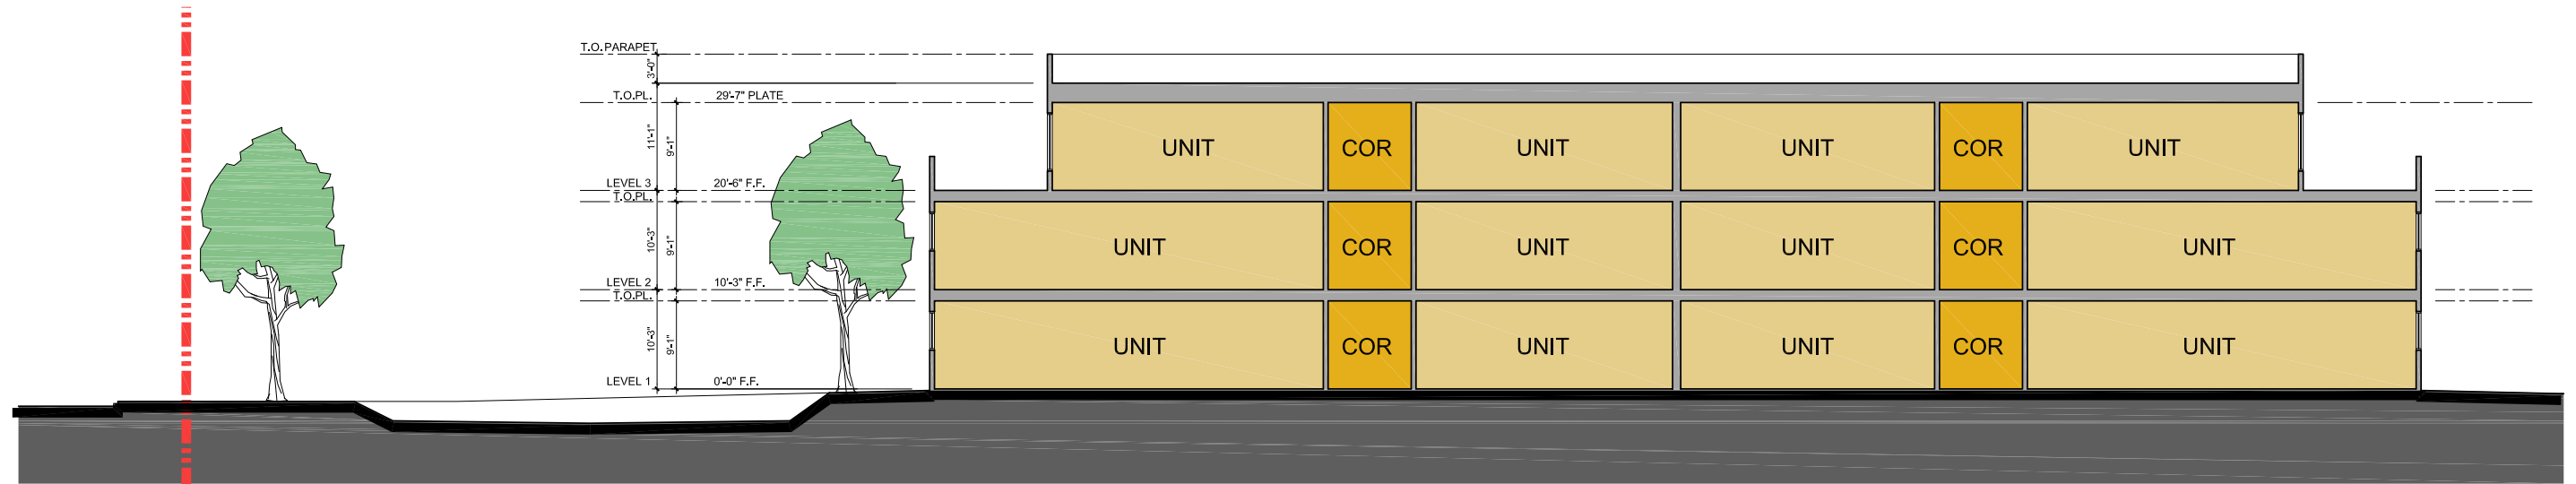



24 PLEX - BUILDING SECTION B

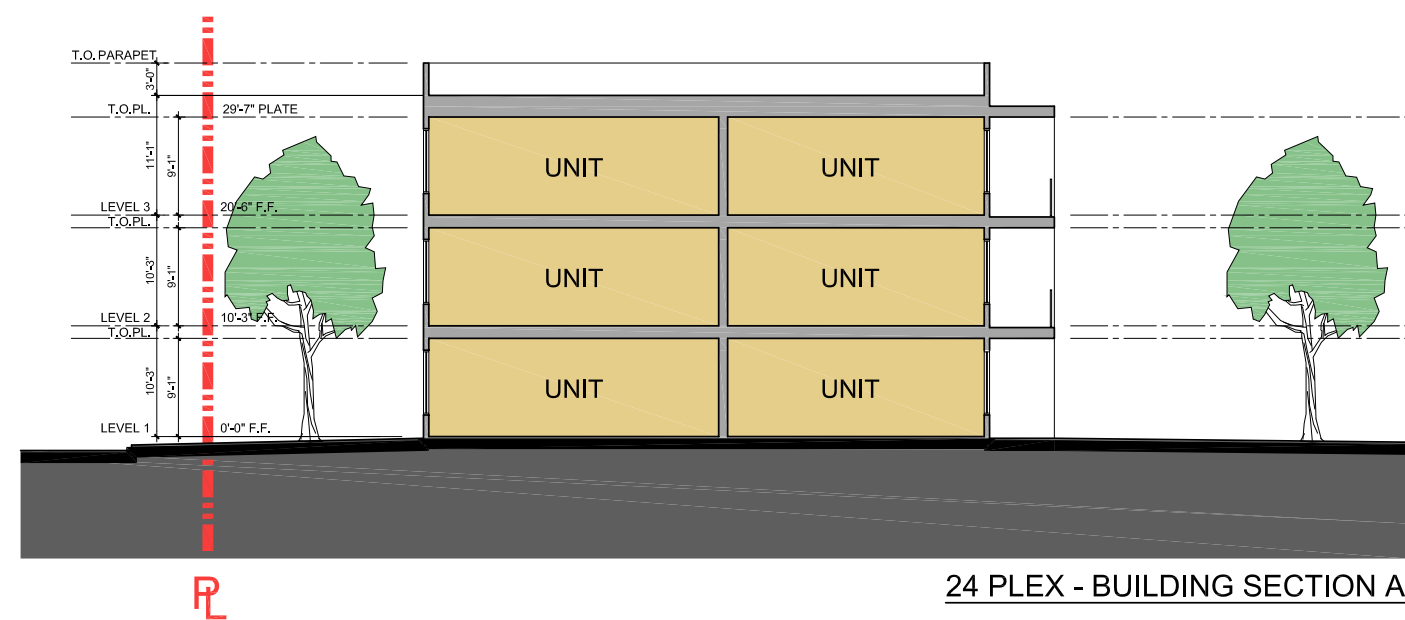


24 PLEX - BUILDING SECTION A

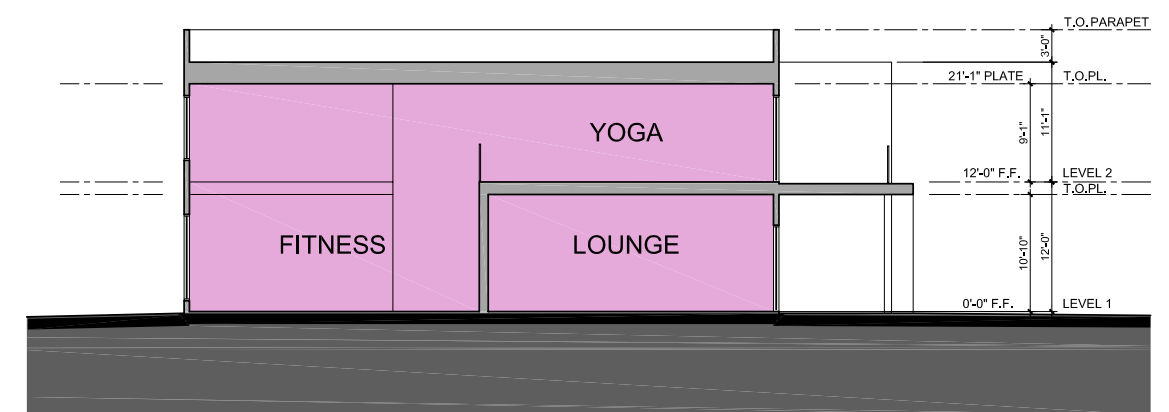


CLUBHOUSE - BUILDING SECTION C

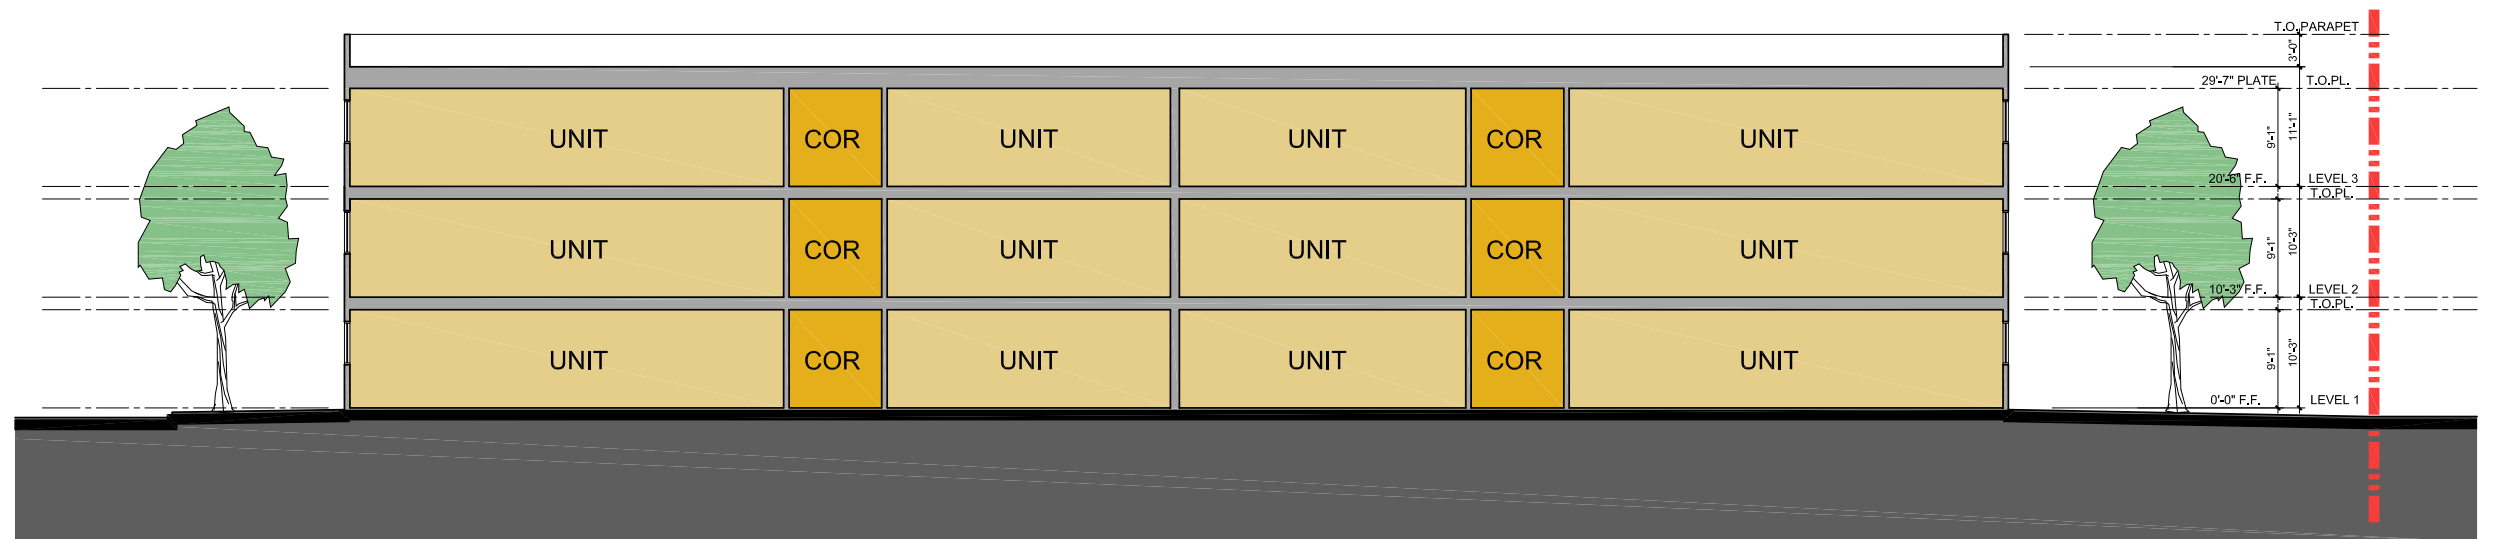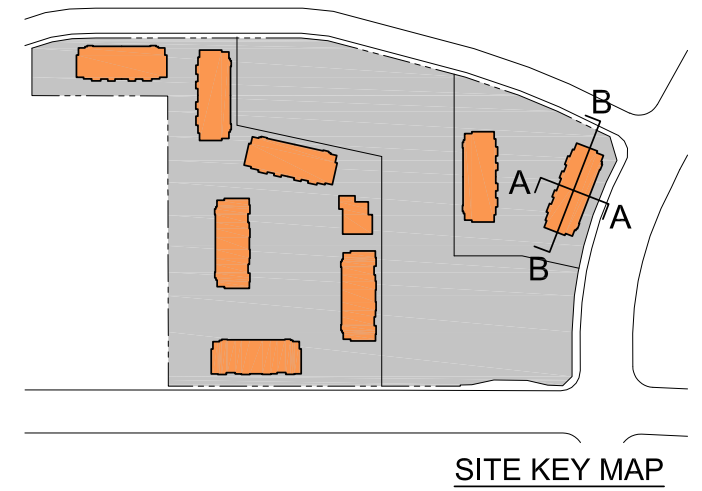

20 PLEX - BUILDING SECTION B

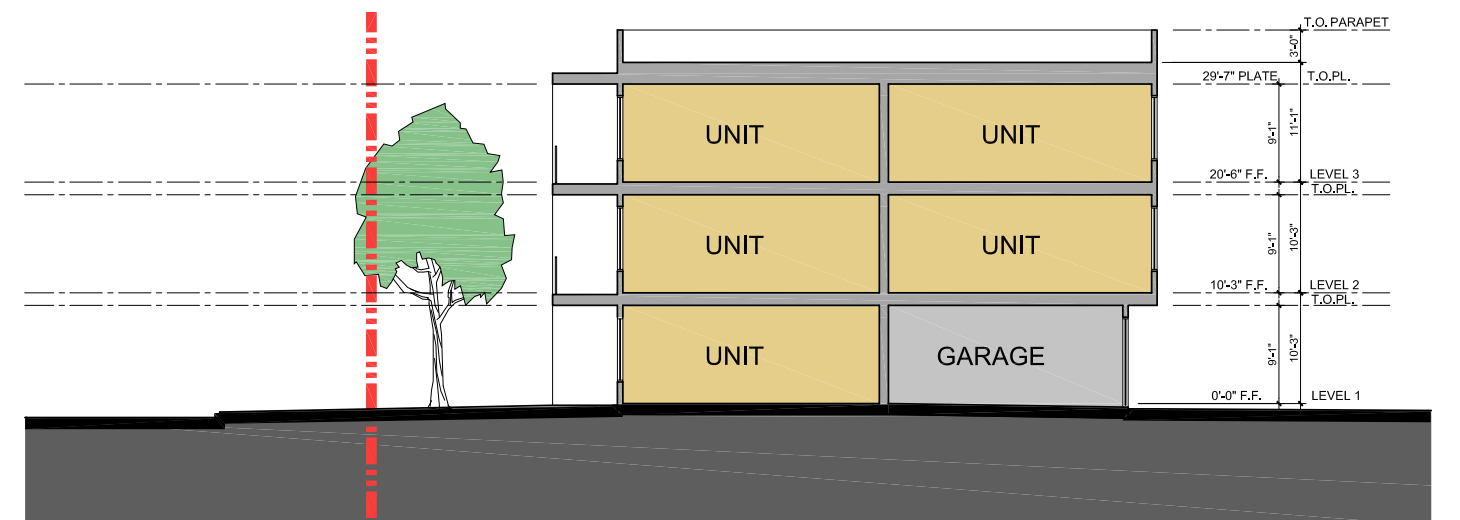


20 PLEX - BUILDING SECTION A

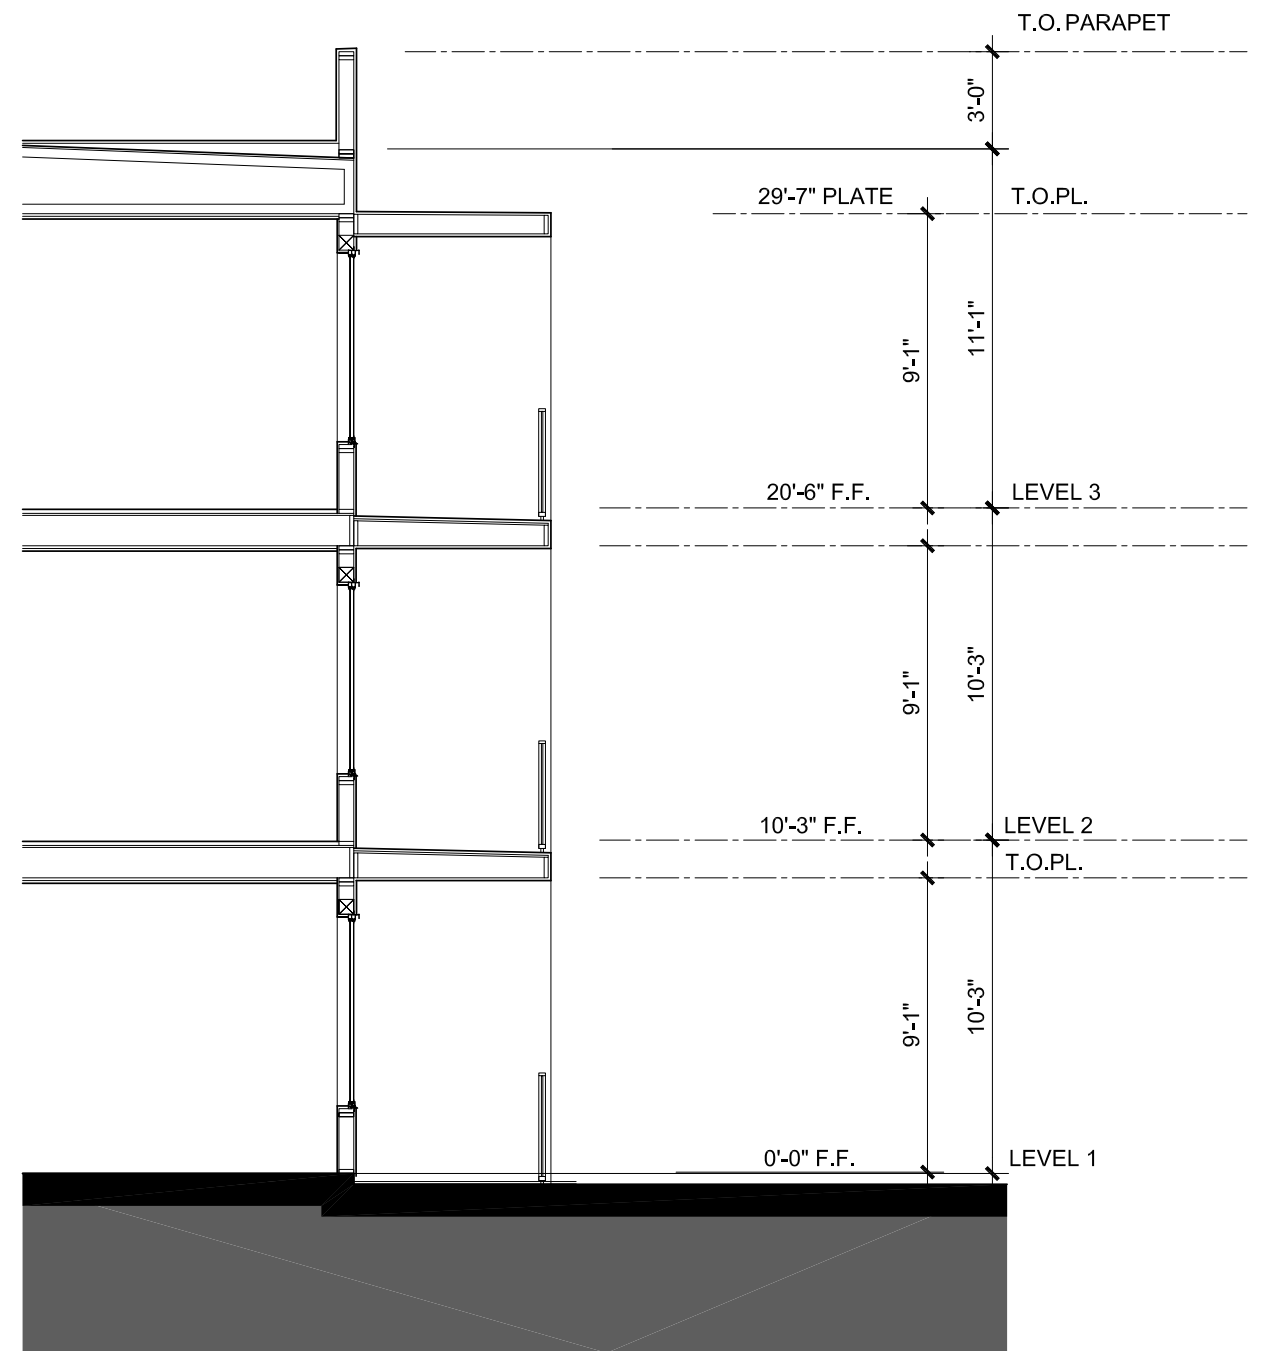

TYPICAL WALL SECTION AT BALCONY



 5 SECTIONAL GARAGE DOOR
PAINT: CITYSCAPE #SW-7067



4 FIBER CEMENT - SMOOTH
PAINT: PEARLY WHITE #SW-7009



3 FIBER CEMENT LAP SIDING
PAINT: DOWN POUR #SW-6516



2 FIBER CEMENT LAP SIDING
PAINT: GRAY MATTERS #SW-7066



1 FIBER CEMENT LAP SIDING
STAIN: ALLURA "MAPLE"

6 METAL GUARD RAILING
PAINT: CITYSCAPE #SW-7067

7 BOARD TRIM - SMOOTH
PAINT: PEARLY WHITE #SW-7009



REFERENCED RENDERING



Architecture + Planning
888.456.5849
ktgy.com

KENNEDY WILSON
151 S. El Camino Dr.
Beverly Hills, CA 90212

38 DEGREES NORTH
Santa Rosa, CA KTGY# 2018-1100

ARCH CONCEPT PACKAGE
JANUARY 28, 2020

MATERIAL BOARD







Architecture + Planning
888.456.5849
ktgy.com

KENNEDY WILSON
151 S. El Camino Dr.
Beverly Hills, CA 90212

38 DEGREES NORTH

Santa Rosa, CA KTGY# 2018-1100

ARCH CONCEPT PACKAGE
JANUARY 28, 2020

STREET VIEW
MASSING EXHBIT

A - 17



Architecture + Planning
888.456.5849
ktgy.com

KENNEDY WILSON
151 S. El Camino Dr.
Beverly Hills, CA 90212

38 DEGREES NORTH

Santa Rosa, CA KTGY# 2018-1100

ARCH CONCEPT PACKAGE
JANUARY 28, 2020

PERSPECTIVE :
24-PLEX FRONT & CLUBHOUSE

A - 18



Architecture + Planning
888.456.5849
ktgy.com

KENNEDY WILSON
151 S. El Camino Dr.
Beverly Hills, CA 90212

38 DEGREES NORTH

Santa Rosa, CA KTGY# 2018-1100

ARCH CONCEPT PACKAGE
JANUARY 28, 2020

PERSPECTIVE :
24-PLEX FRONT

A - 19



Architecture + Planning
888.456.5849
ktgy.com

KENNEDY WILSON
151 S. El Camino Dr.
Beverly Hills, CA 90212

38 DEGREES NORTH

Santa Rosa, CA KTG# 2018-1100

ARCH CONCEPT PACKAGE

JANUARY 28, 2020

PERSPECTIVE :
24-PLEX FRONT

A - 20



Architecture + Planning
888.456.5849
ktgy.com

KENNEDY WILSON
151 S. El Camino Dr.
Beverly Hills, CA 90212

38 DEGREES NORTH

Santa Rosa, CA KTG# 2018-1100

ARCH CONCEPT PACKAGE

JANUARY 28, 2020

PERSPECTIVE :
20-PLEX FRONT

A - 21



Architecture + Planning
888.456.5849
ktgy.com

KENNEDY WILSON
151 S. El Camino Dr.
Beverly Hills, CA 90212

38 DEGREES NORTH

Santa Rosa, CA KTGY# 2018-1100

ARCH CONCEPT PACKAGE
JANUARY 28, 2020

PERSPECTIVE :
20-PLEX FRONT

A - 22



Architecture + Planning
888.456.5849
ktgy.com

KENNEDY WILSON
151 S. El Camino Dr.
Beverly Hills, CA 90212

38 DEGREES NORTH

Santa Rosa, CA KTGY# 2018-1100

ARCH CONCEPT PACKAGE
JANUARY 28, 2020

PERSPECTIVE :
24-PLEX BACK

A - 23



Architecture + Planning
888.456.5849
ktgy.com

KENNEDY WILSON
151 S. El Camino Dr.
Beverly Hills, CA 90212

38 DEGREES NORTH

Santa Rosa, CA KTGY# 2018-1100

ARCH CONCEPT PACKAGE
JANUARY 28, 2020

PERSPECTIVE :
20-PLEX BACK

A - 24



Architecture + Planning
888.456.5849
ktgy.com

KENNEDY WILSON
151 S. El Camino Dr.
Beverly Hills, CA 90212

38 DEGREES NORTH

Santa Rosa, CA KTGY# 2018-1100

ARCH CONCEPT PACKAGE
JANUARY 28, 2020

PERSPECTIVE :
CLUBHOUSE

A - 25



Architecture + Planning
888.456.5849
ktgy.com

KENNEDY WILSON
151 S. El Camino Dr.
Beverly Hills, CA 90212

38 DEGREES NORTH

Santa Rosa, CA KTGY# 2018-1100

ARCH CONCEPT PACKAGE
JANUARY 28, 2020

PERSPECTIVE :
CLUBHOUSE

A - 26



Architecture + Planning
888.456.5849
ktgy.com

KENNEDY WILSON
151 S. El Camino Dr.
Beverly Hills, CA 90212

38 DEGREES NORTH

Santa Rosa, CA KTGY# 2018-1100

ARCH CONCEPT PACKAGE
JANUARY 28, 2020

PERSPECTIVE :
CLUBHOUSE

A - 27