

EXTERIOR MATERIAL KEY

- PREFINISHED ALUMINUM BATTENS
MFR: LUMARULT
STYLE: MOSAIC 1x6 BATTENS
COLOR: HAZELNUT BROWN
- STONE VENEER
MFR: EL DORADO STONE
STYLE: VANTAGE 30 (6"H x 30"L x 1"D)
COLOR: WHITE ELM w/ MATCHING MORTAR JOINT
- EIFS
TEXTURE: SAND
COLOR: PT-6 (MORNING FOG)
- EIFS
TEXTURE: SAND
COLOR: PT-3 (WALL STREET)
- EIFS
TEXTURE: SAND
COLOR: PT-9 (IN THE NAVY)
- SINGLE WYTHE CMU
TEXTURE: SMOOTH FACE
INTEGRAL COLOR TO MATCH PT-6 (MORNING FOG)
- SINGLE WYTHE CMU
TEXTURE: SPLIT FACE
INTEGRAL COLOR TO MATCH PT-3 (WALLSTREET)
- PRECAST STONE SILL
COLOR TO MATCH STONE VENEER
- PREFINISHED ALUMINUM WALL PANEL
MFR: CTMPS (OR EQUAL)
COLOR: PT-9 (IN THE NAVY)
STYLE: R PANEL
- PREFINISHED STANDING SEAM METAL ROOF PANEL
MFR: CTMPS (OR EQUAL)
STYLE: LARGE BATTEN 24 GA
COLOR: PT-9 (IN THE NAVY)
- PREFINISHED METAL TRIM AND ACCESSORIES
MFR: CTMPS (OR EQUAL)
COLOR: PT-9 (IN THE NAVY)
- ALUMINUM STOREFRONT SYSTEM
GLAZING: CLEAR
FRAME: CLEAR ANODIZED
- CONCRETE STEM WALL
TEXTURE: HAND RUB
COLOR TO MATCH PT-10
- TREX DECK BOARD
COLOR TO MATCH PT-3

GENERAL NOTES

- ALL SIGNAGE SHOWN FOR INFORMATIONAL PURPOSES ONLY. ALL ADVERTISING SIGNAGE SUBJECT TO SEPARATE SIGN PERMIT SUBMITTAL AND APPROVAL.
- EXTERIOR LIGHTING LOCATIONS SHOWN. SEE ELECTRICAL PLANS FOR EXTERIOR LIGHTING SPECIFICATIONS AND REQUIREMENTS. COORDINATE J-BOX LOCATIONS W/ FUTURE OWNER LIGHTING.
- APPLY CLEAR WATERPROOF SEALER TO ALL EXPOSED STONE VENEER AND CMU.
- METAL ROOF COLOR IS A CUSTOM COLOR. NO ALTERNATE WILL BE ACCEPTED.

PROJECT INFORMATION

PROPOSED CAR WASH FOR:
MISTER CAR WASH - CA 2637 SANTA ROSA
2700 SANTA ROSA AVE • SANTA ROSA, CA 95407

(130L-N - V1.2 - ZONE 4)

PROFESSIONAL SEAL

PRELIMINARY DATES

AUG. 8, 2025

JOB NUMBER

205209400

SHEET NUMBER


PRE-3

PRELIMINARY ATTENDANT SHELTER




RIGHT ELEVATION

SCALE: 3/4" = 1'-0"

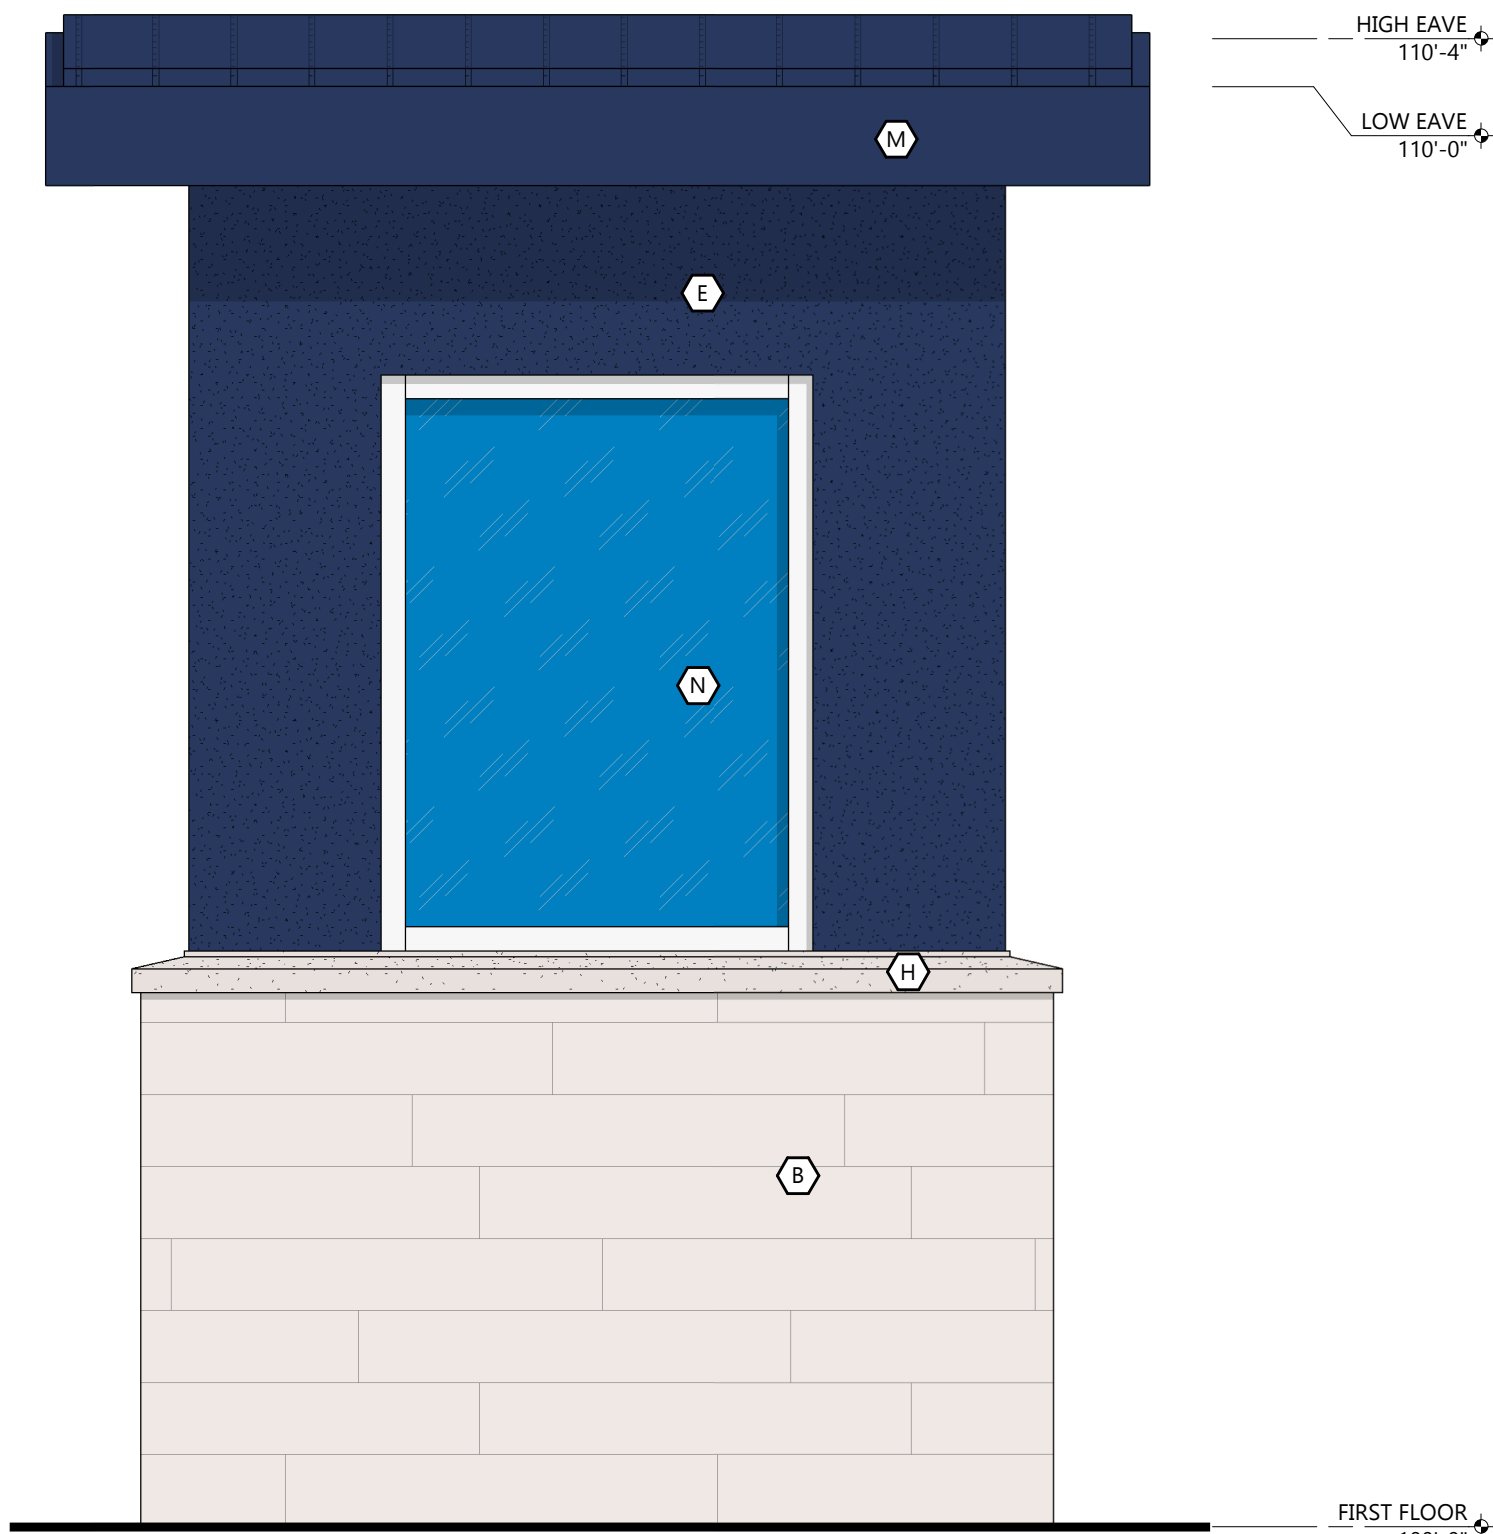

REAR ELEVATION

SCALE: 3/4" = 1'-0"

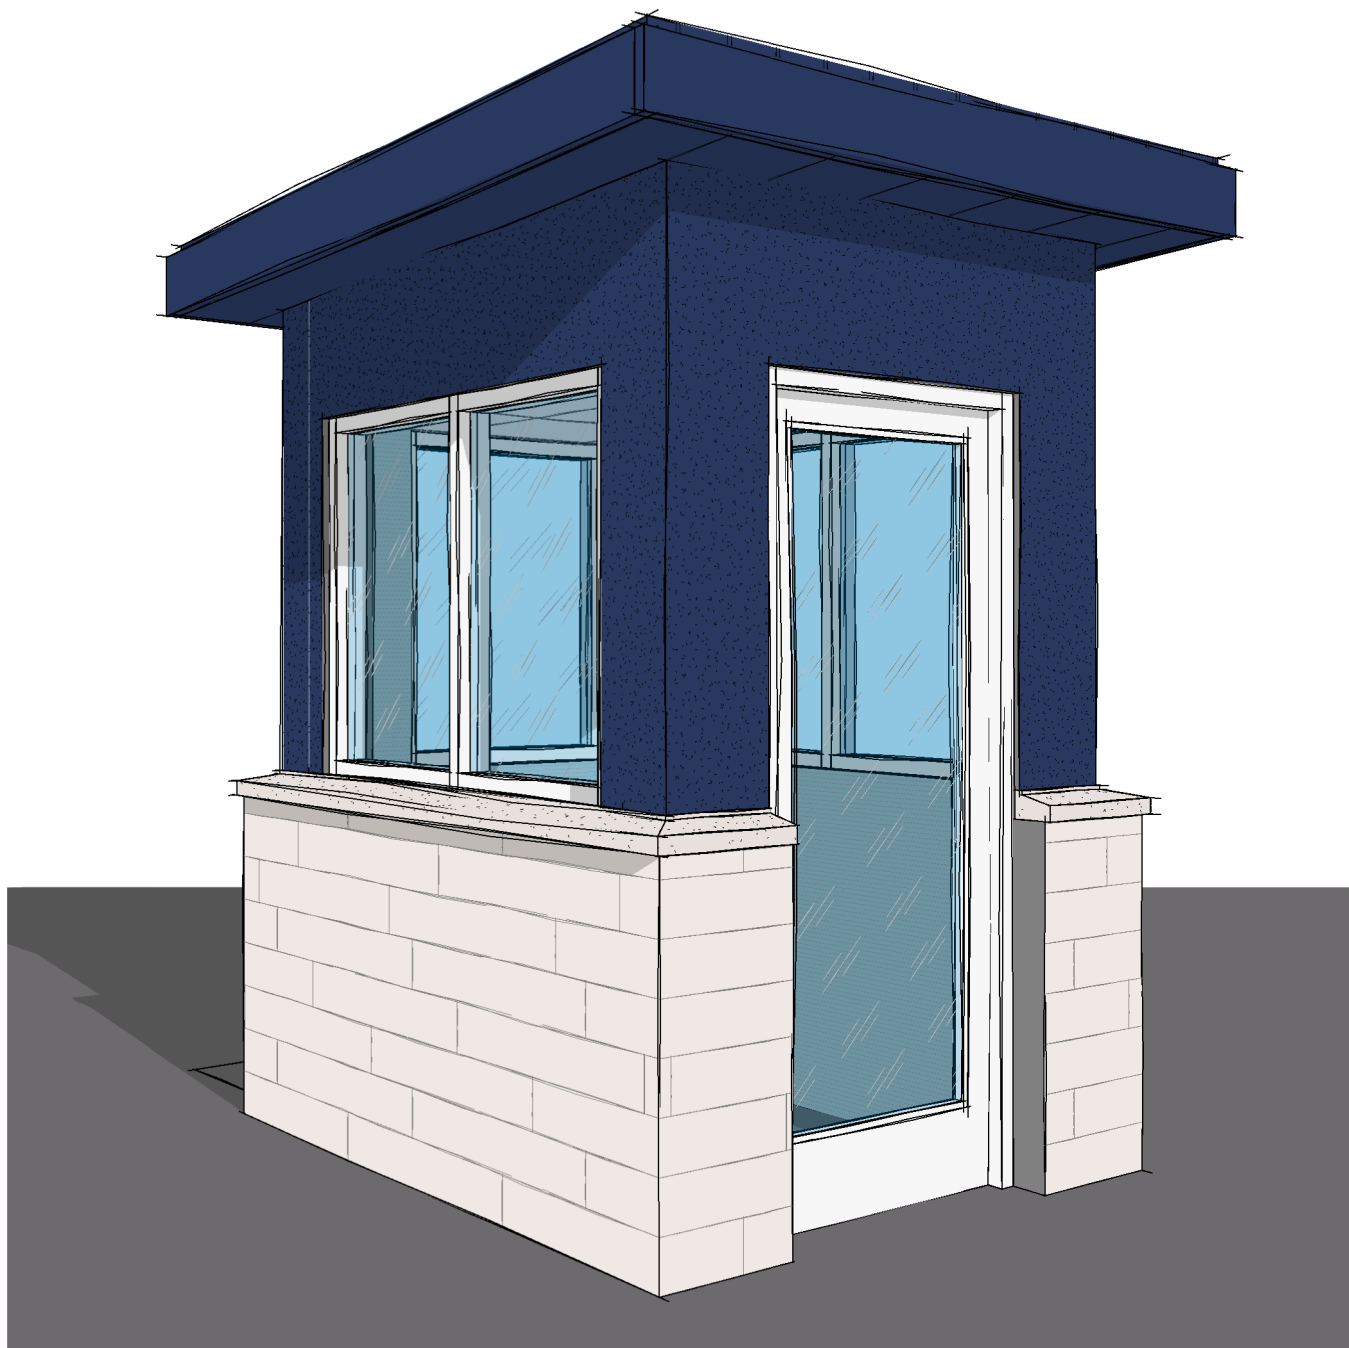


LEFT ELEVATION

SCALE: 3/4" = 1'-0"



FRONT ELEVATION


SCALE: 3/4" = 1'-0"

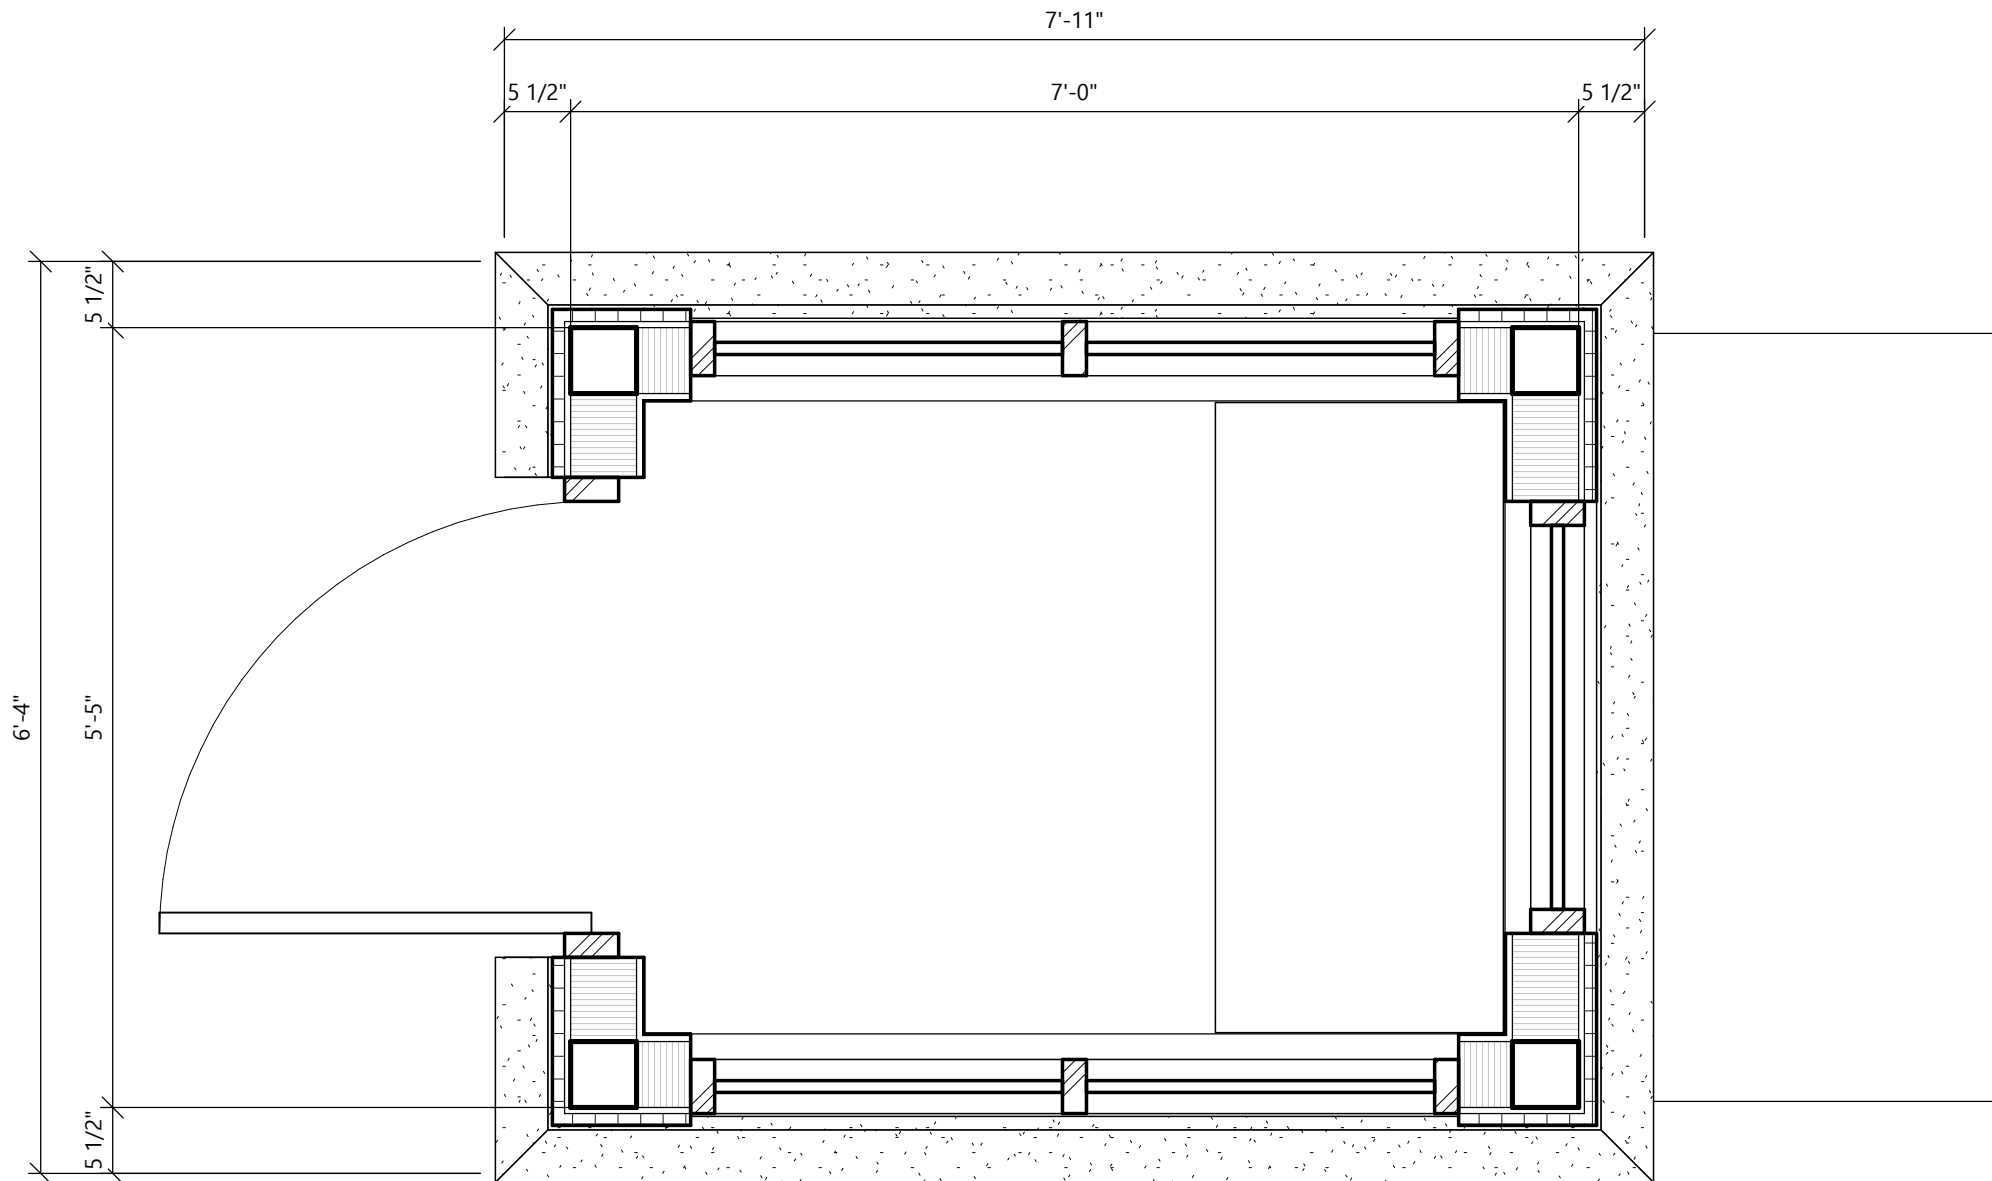

SHELTER PLAN

SCALE: 3/4" = 1'-0"

NOT FOR CONSTRUCTION

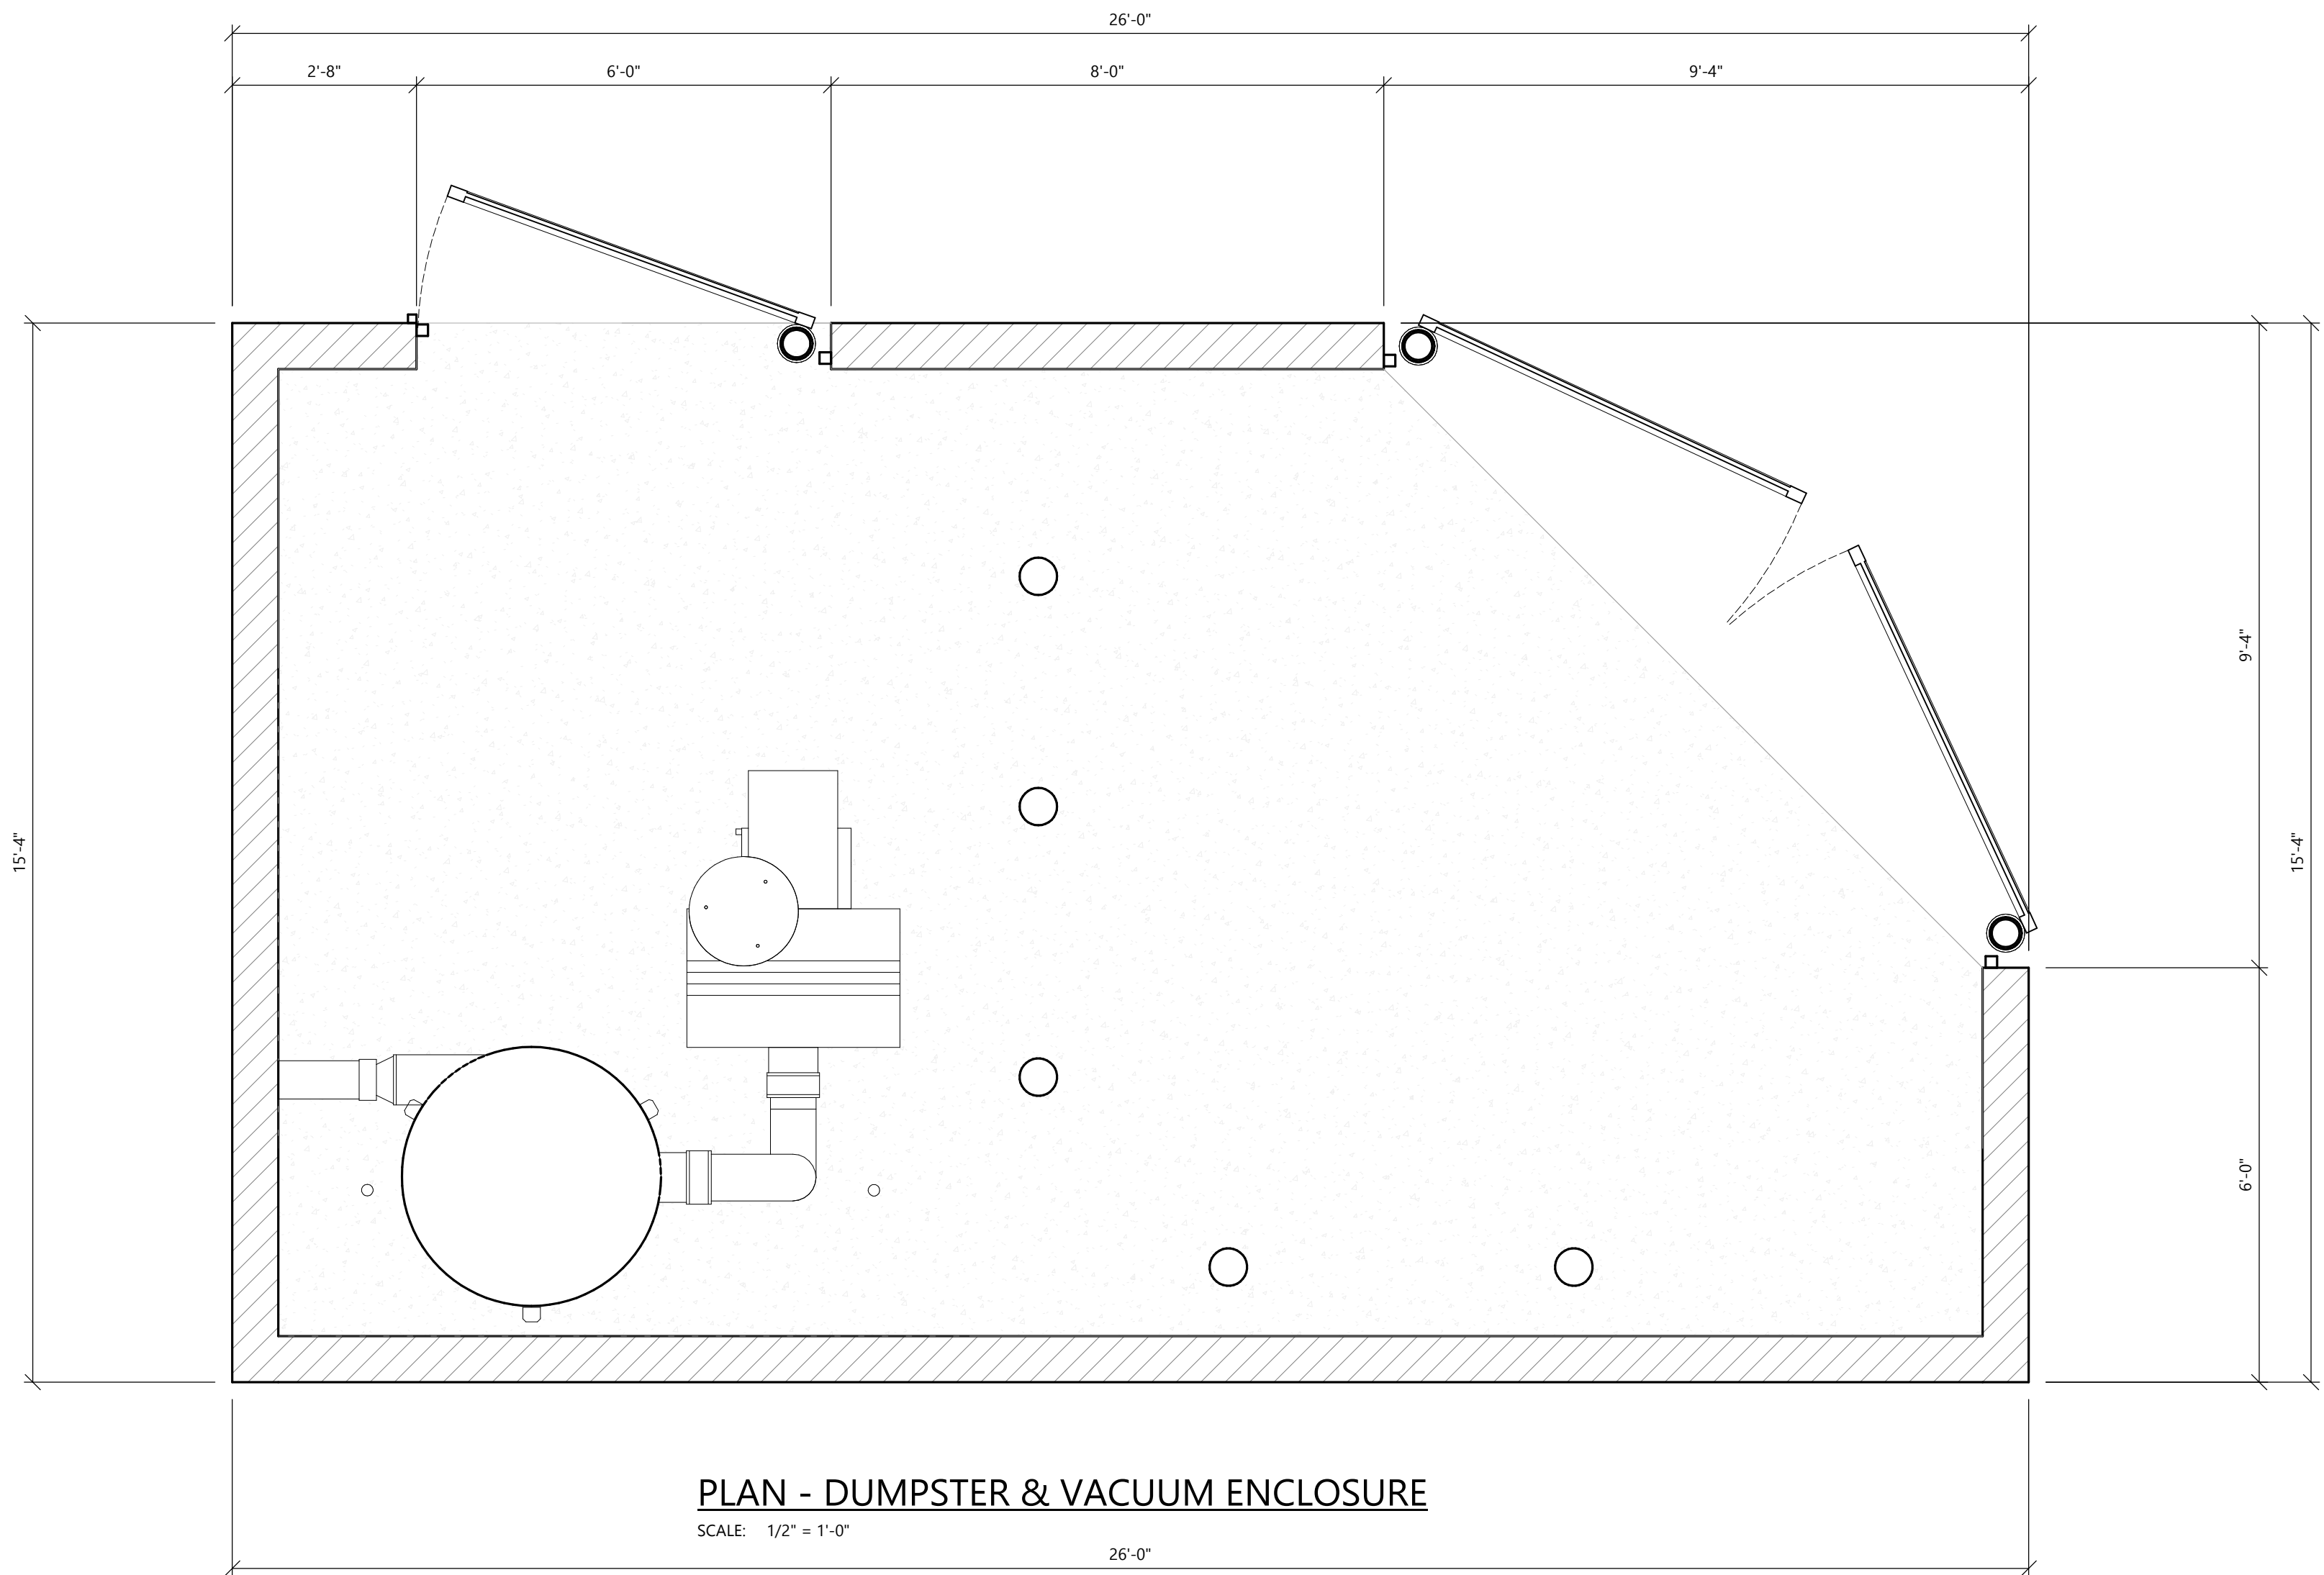

PLAN - DUMPSTER & VACUUM ENCLOSURE


SCALE: 1/2" = 1'-0"

EXTERIOR MATERIAL KEY

- A** PREFINISHED ALUMINUM BATTENS
MFR: LUMABUILT
STYLE: MOSAIC 1x6 BATTENS
COLOR: HAZELNUT BROWN
- B** STONE VENEER
MFR: EL DORADO STONE
STYLE: VANTAGE 30 (6"H x 30"L x 1"D)
COLOR: WHITE ELM w/ MATCHING MORTAR JOINT
- C** EIFS
TEXTURE: SAND
COLOR: PT-6 (MORNING FOG)
- D** EIFS
TEXTURE: SAND
COLOR: PT-3 (WALL STREET)
- E** EIFS
TEXTURE: SAND
COLOR: PT-9 (IN THE NAVY)
- F** SINGLE WYTHE CMU
TEXTURE: SPLIT FACE
INTEGRAL COLOR TO MATCH PT-6 (MORNING FOG)
- G** SINGLE WYTHE CMU
TEXTURE: SMOOTH FACE
INTEGRAL COLOR TO MATCH PT-3 (WALLSTREET)
- H** PRECAST STONE SILL
COLOR TO MATCH STONE VENEER
- I** PREFINISHED ALUMINUM WALL PANEL
MFR: CTRMS (OR EQUAL)
COLOR: PT-9 (IN THE NAVY)
STYLE: R PANEL
- J** PREFINISHED STANDING SEAM METAL ROOF PANEL
MFR: CTRMS (OR EQUAL)
STYLE: LARGE BATTEN 24 GA
COLOR: PT-9 (IN THE NAVY)
- M** PREFINISHED METAL TRIM AND ACCESSORIES
MFR: CTRMS (OR EQUAL)
COLOR: PT-9 (IN THE NAVY)
- N** ALUMINUM STOREFRONT SYSTEM
GLAZING: CLEAR
FRAME: CLEAR ANODIZED
- P** CONCRETE STEM WALL
TEXTURE: HAND RUB
COLOR TO MATCH PT-10
- Q** TREX DECK BOARD
COLOR TO MATCH PT-3


GENERAL NOTES

- ALL SIGNAGE SHOWN FOR INFORMATIONAL PURPOSES ONLY. ALL ADVERTISING SIGNAGE SUBJECT TO SEPARATE SIGN PERMIT SUBMITTAL AND APPROVAL.
- EXTERIOR LIGHTING LOCATIONS SHOWN. SEE ELECTRICAL PLANS FOR EXTERIOR LIGHTING SPECIFICATIONS AND REQUIREMENTS. COORDINATE J-BOX LOCATIONS W/ FUTURE OWNER LIGHTING.
- APPLY CLEAR WATERPROOF SEALER TO ALL EXPOSED STONE VENEER AND CMU.
- METAL ROOF COLOR IS A CUSTOM COLOR. NO ALTERNATE WILL BE ACCEPTED.

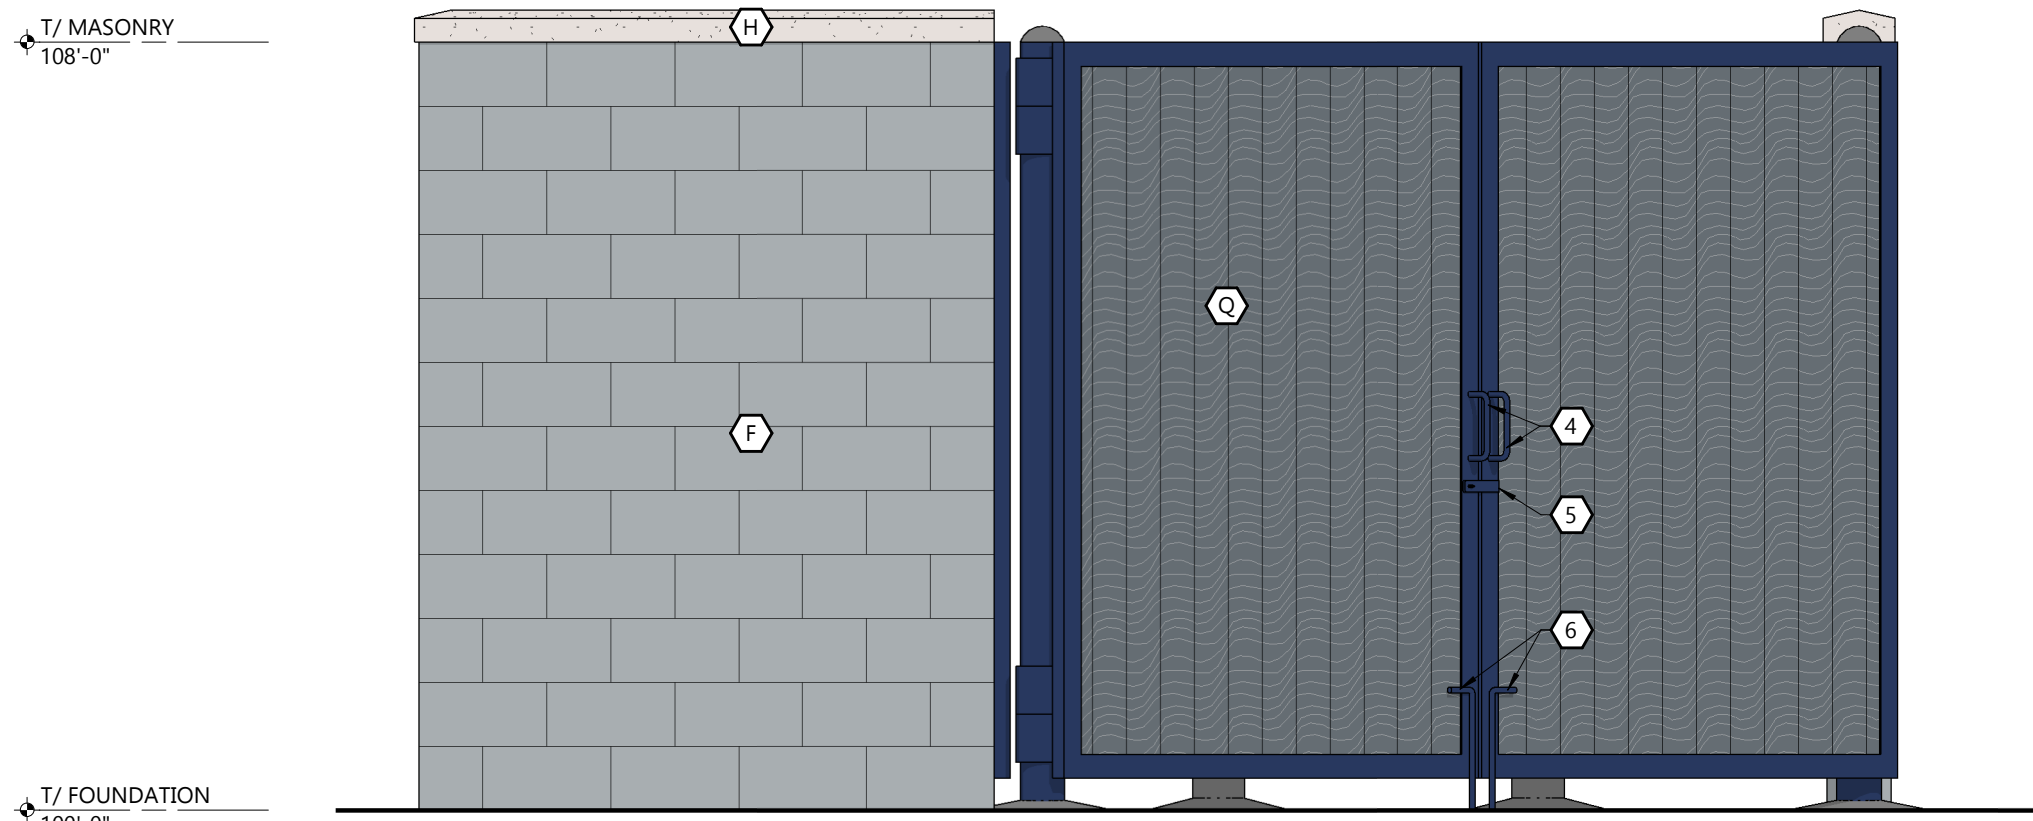


ELEVATION - LEFT

SCALE: 1/2" = 1'-0"

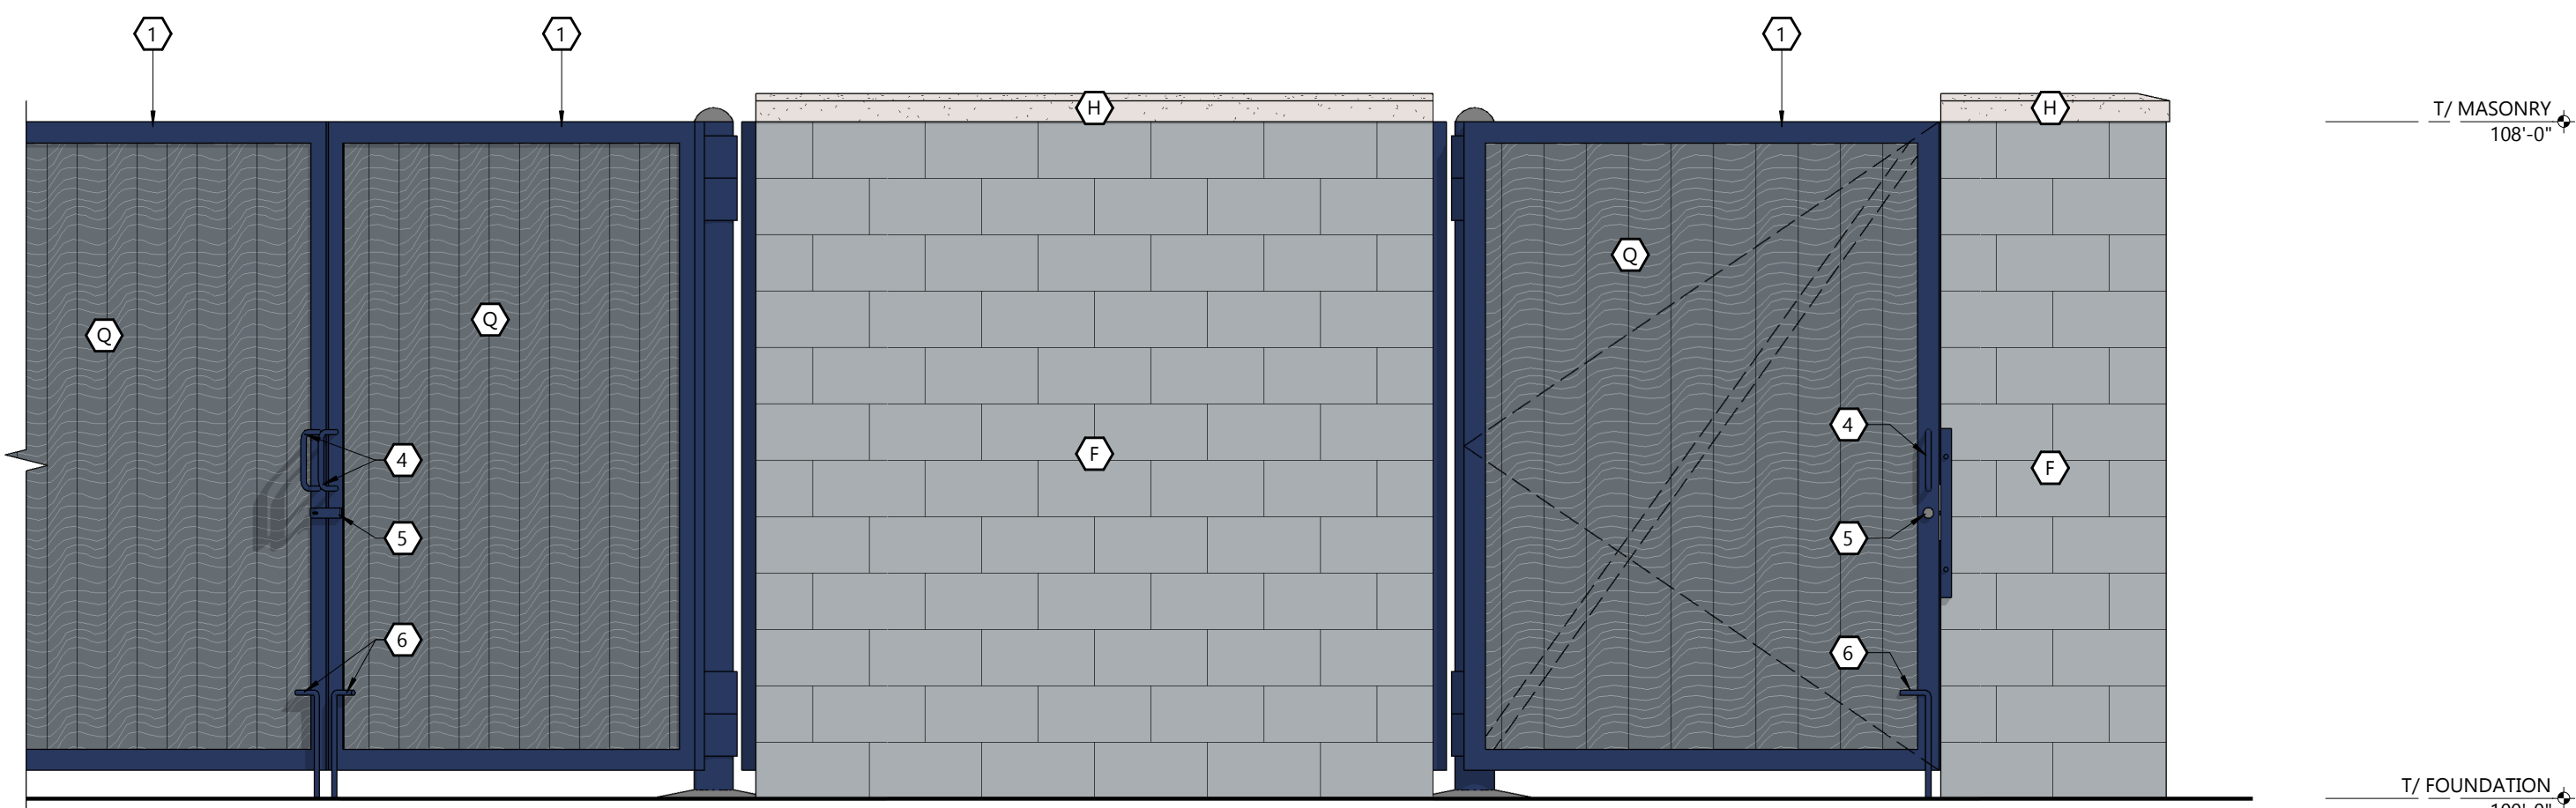


ELEVATION - FRONT

SCALE: 1/2" = 1'-0"

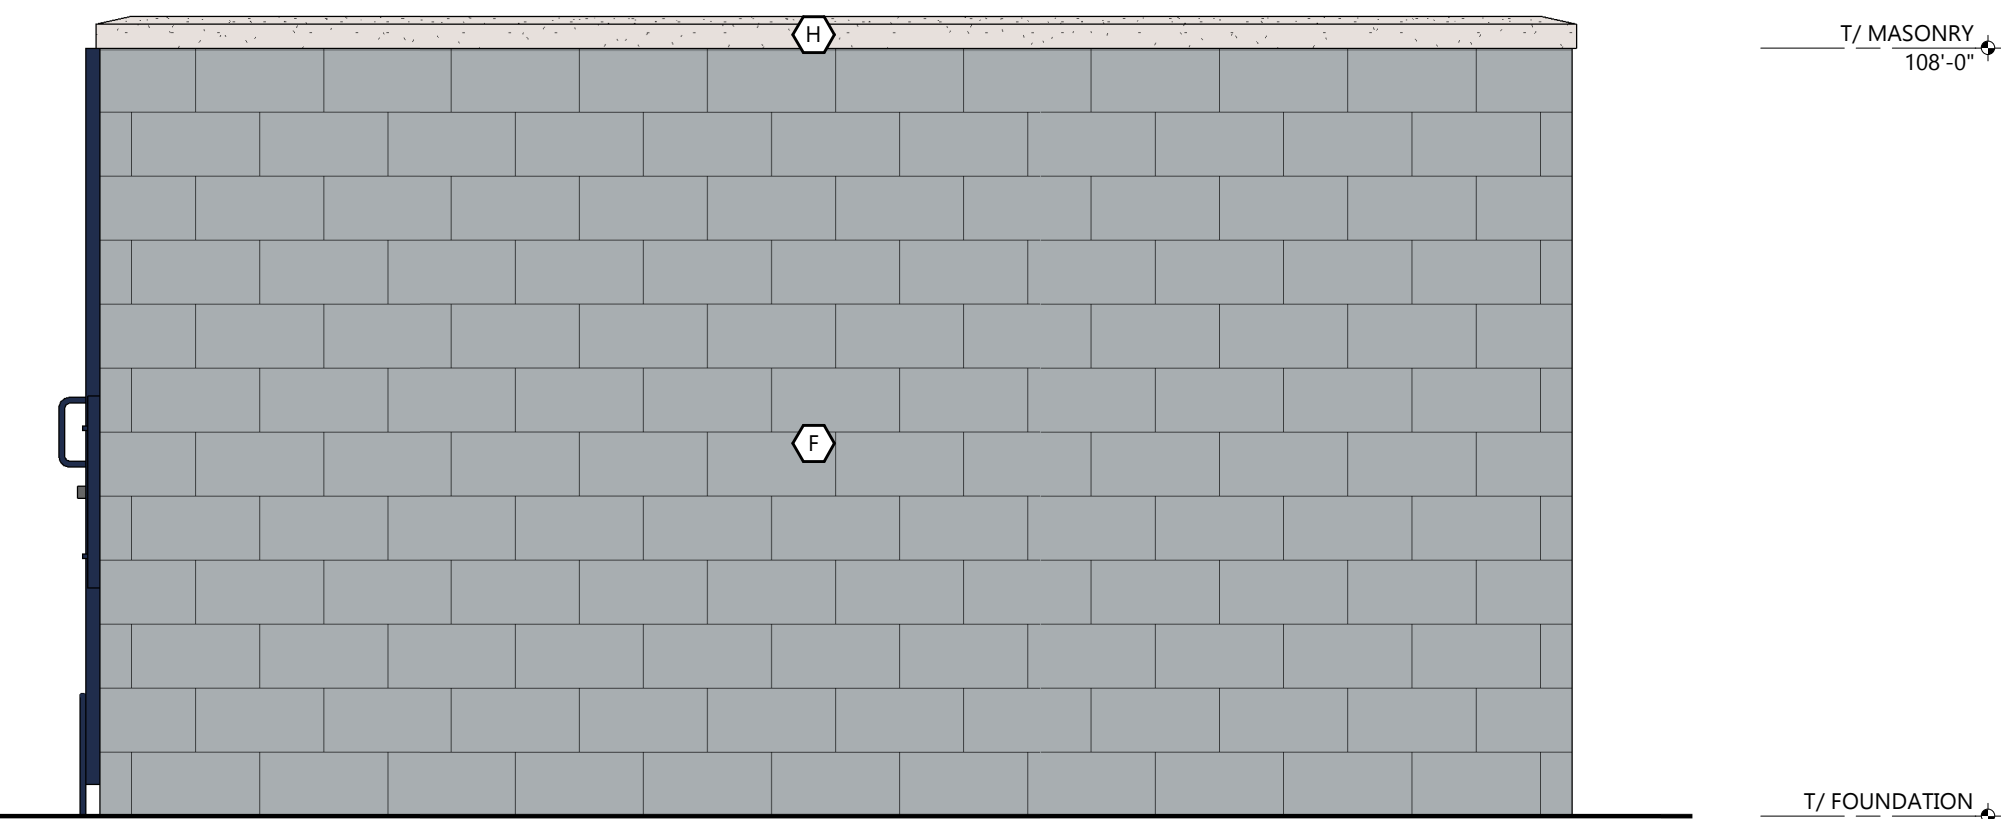

ELEVATION - RIGHT

SCALE: 1/2" = 1'-0"

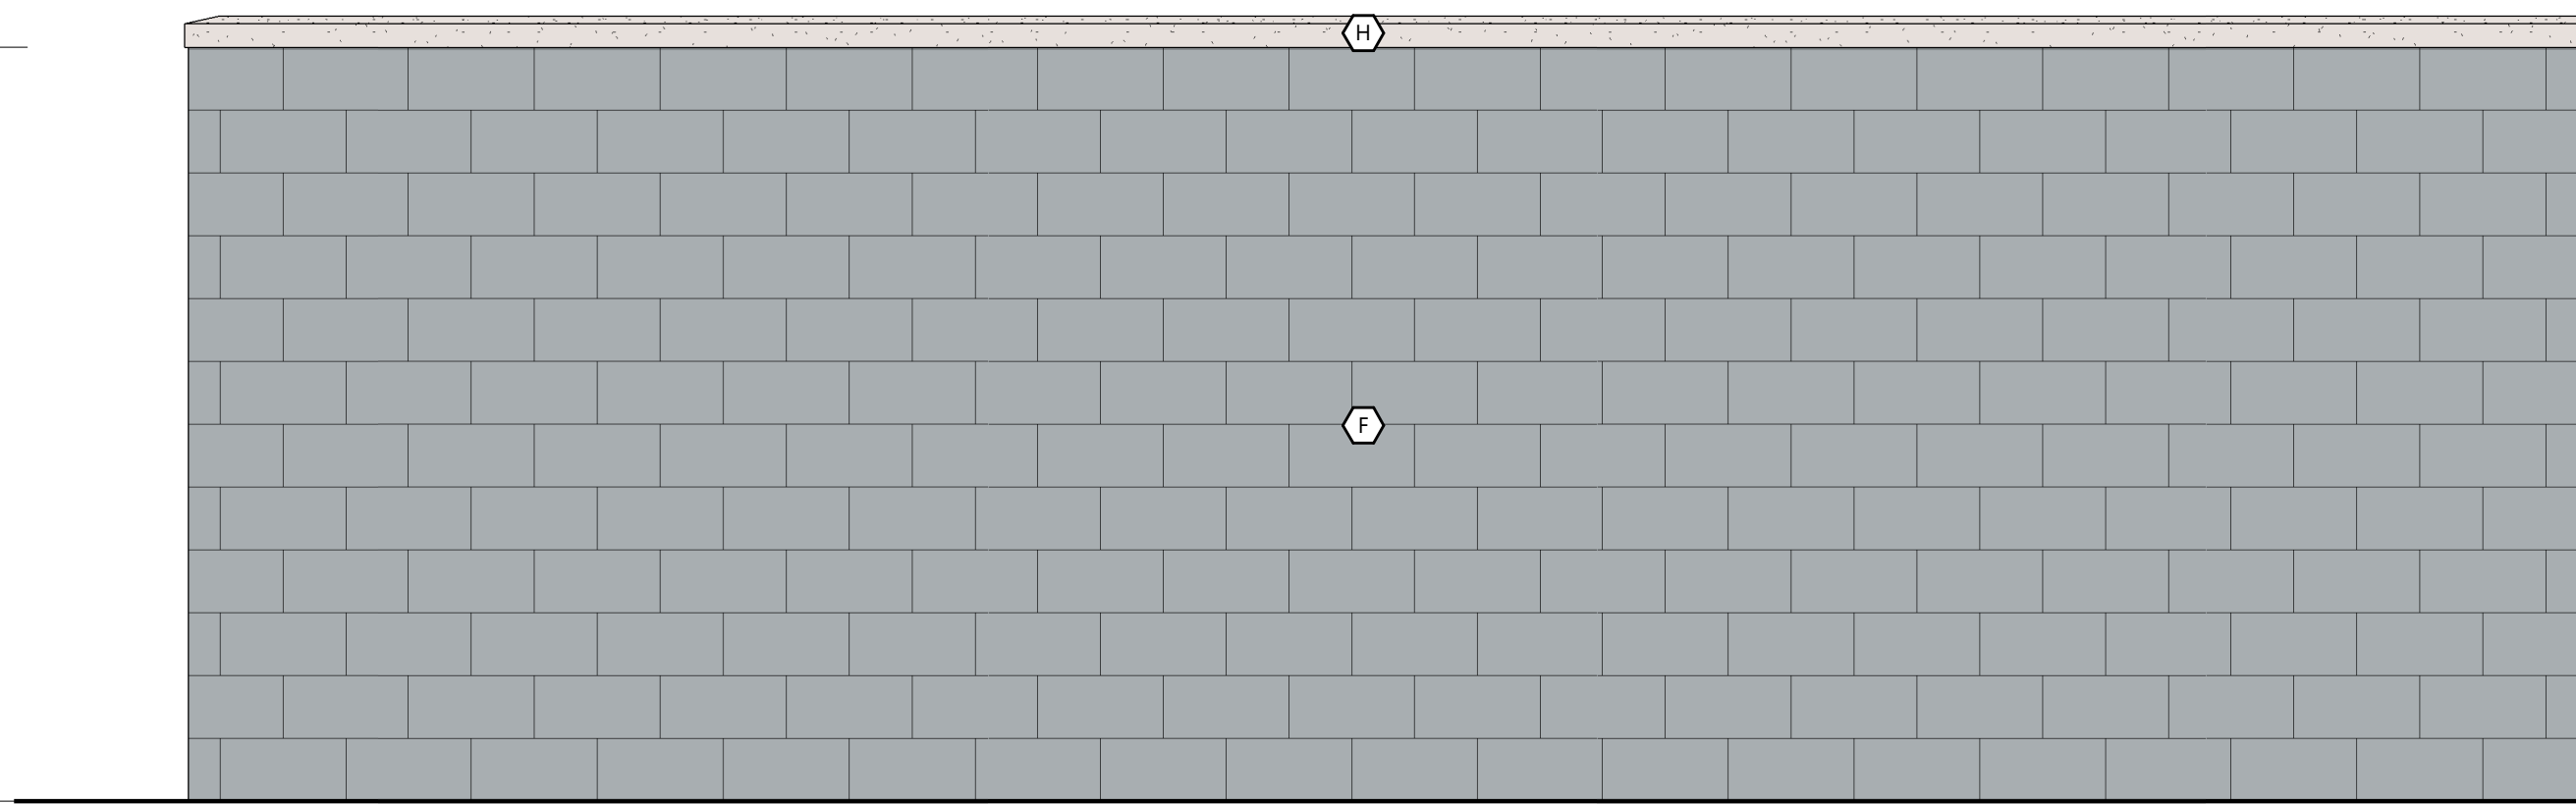

ELEVATION - REAR

SCALE: 1/2" = 1'-0"

PROJECT INFORMATION

PROPOSED CAR WASH FOR:
MISTER CAR WASH - CA 2637 SANTA ROSA
2700 SANTA ROSA AVE • SANTA ROSA, CA 95407

(130L-N - V1.2 - ZONE 4)

PROFESSIONAL SEAL

PRELIMINARY DATES

AUG. 8, 2025

JOB NUMBER

205209400


SHEET NUMBER

PRE-4


PRELIMINARY DUMPSTER ENCLOSURE

NOT FOR CONSTRUCTION

C:\Users\jacob\OneDrive\AutoCAD\Projects\2025\205209400\205209400.dwg
8/6/2025 11:05:21 AM

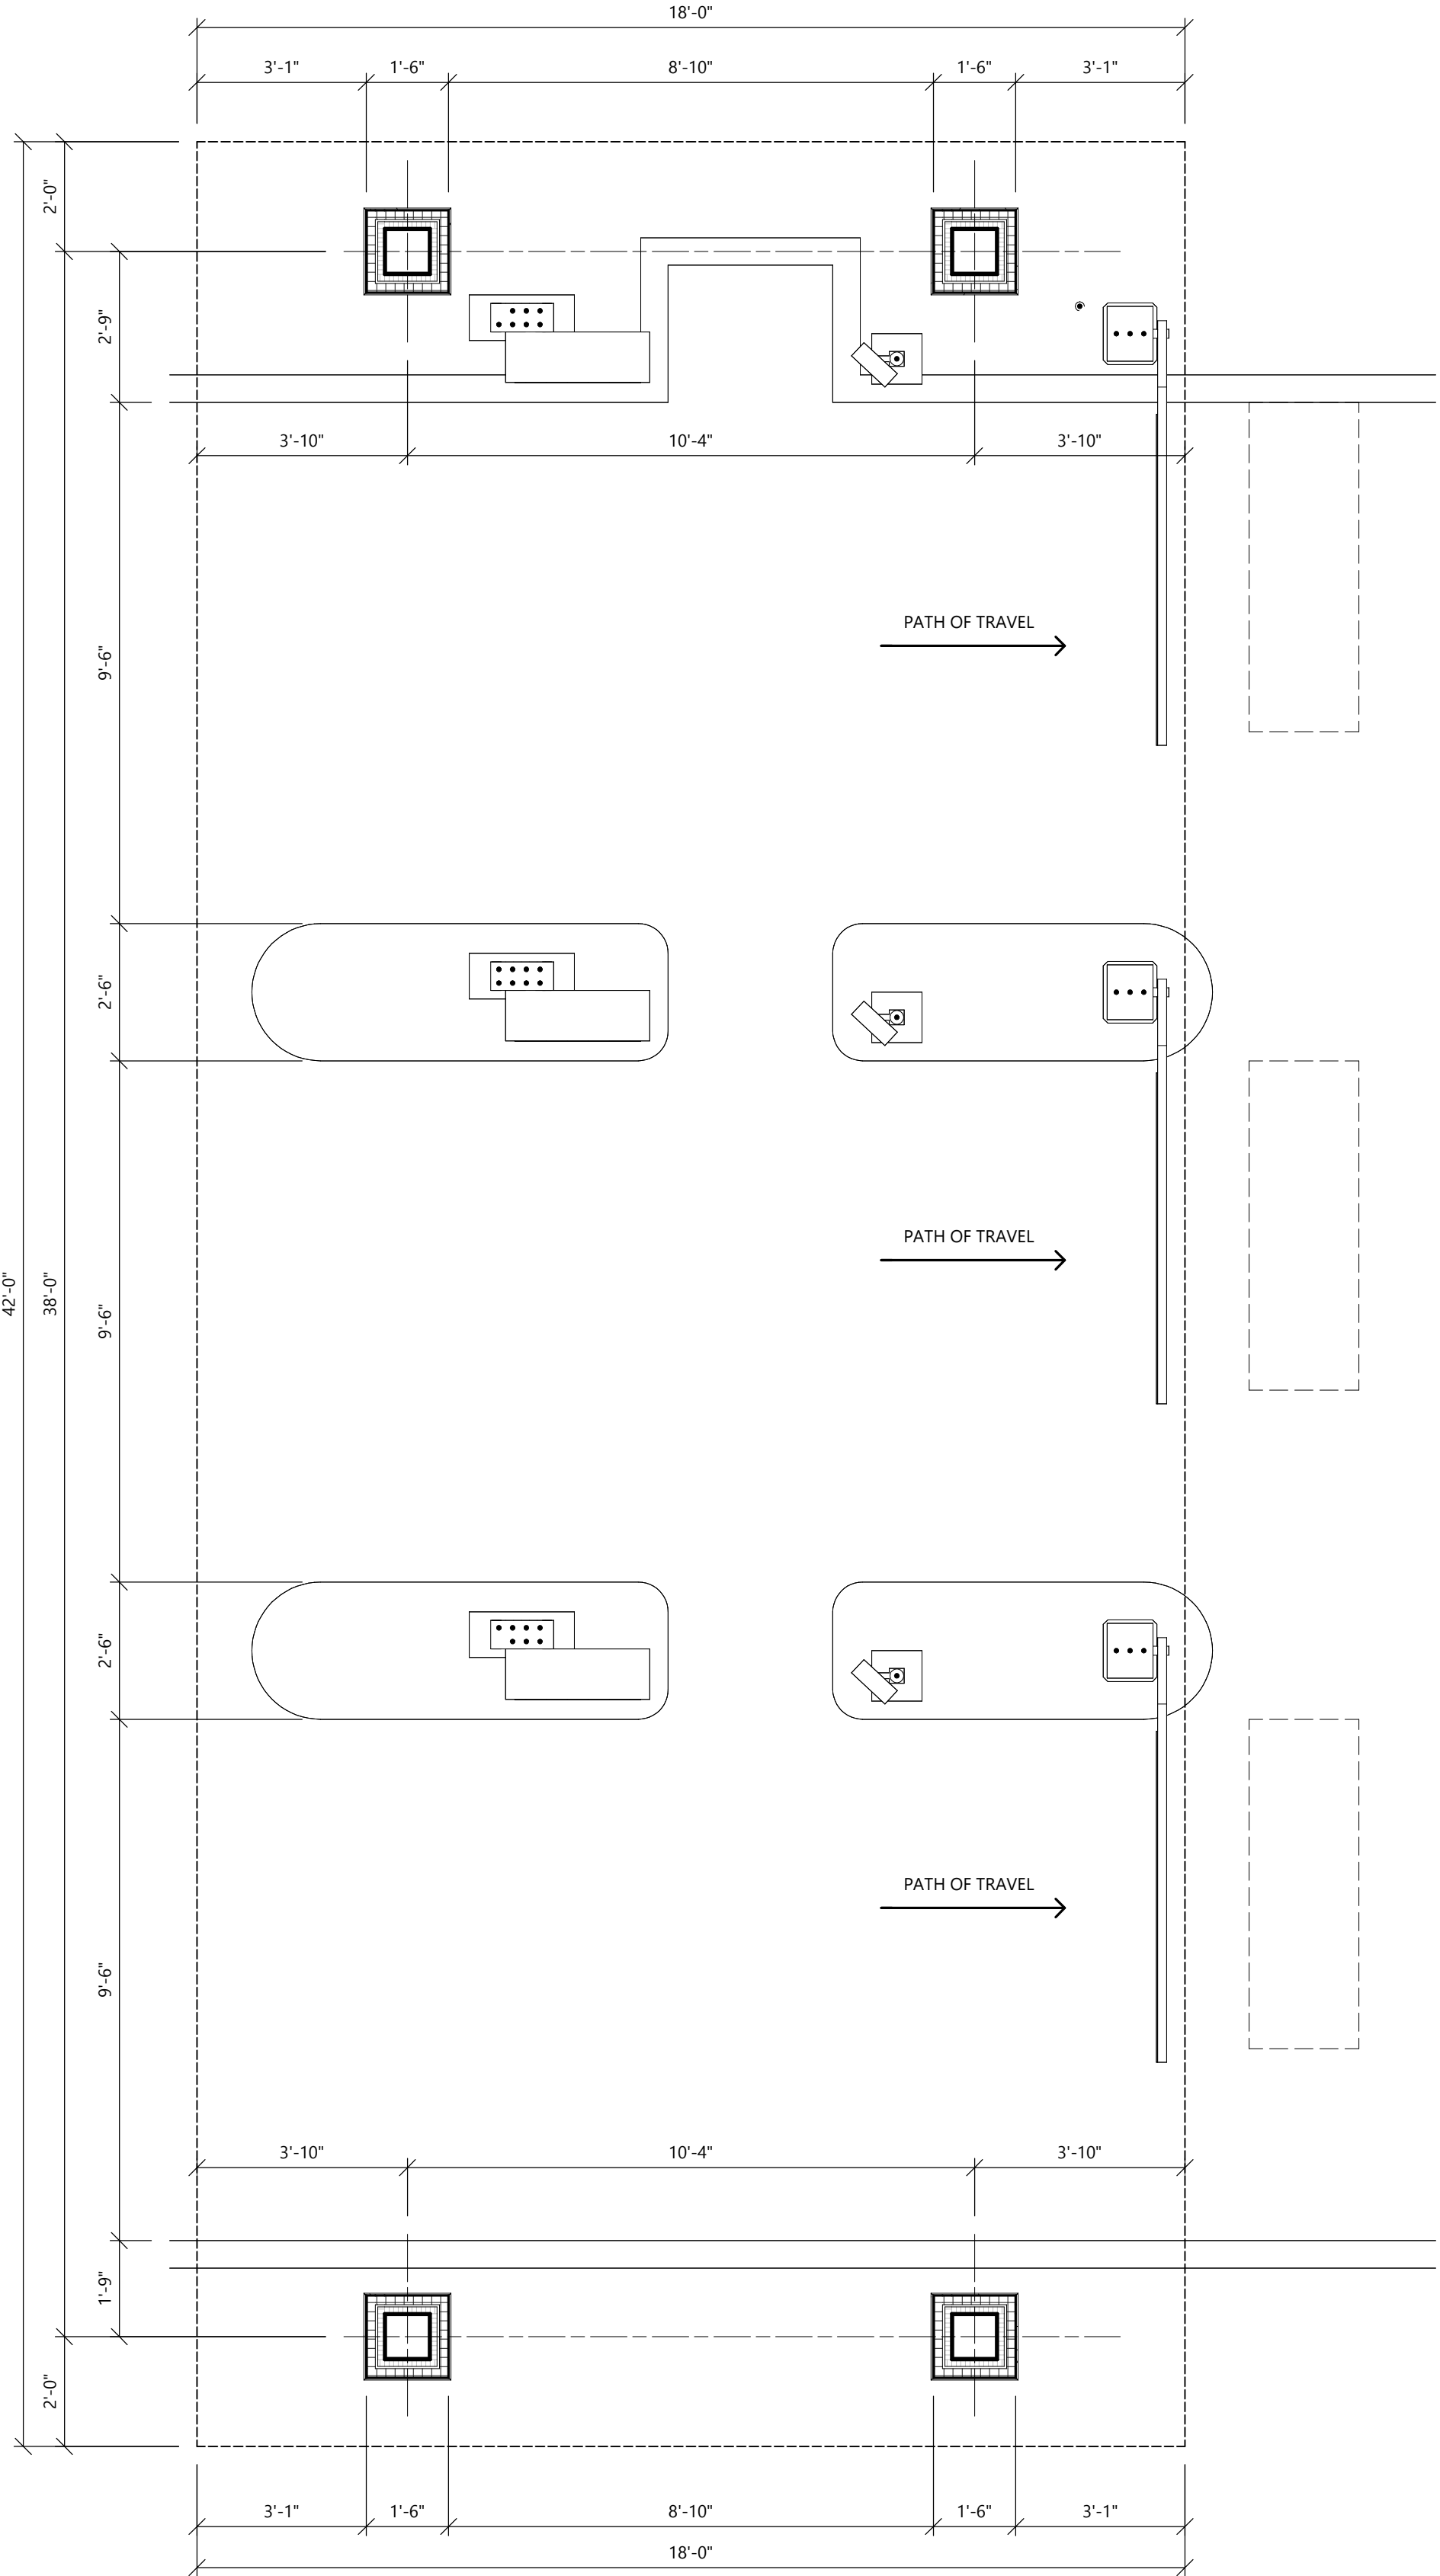

POS CANOPY PLAN
SCALE: 3/8" = 1'-0"

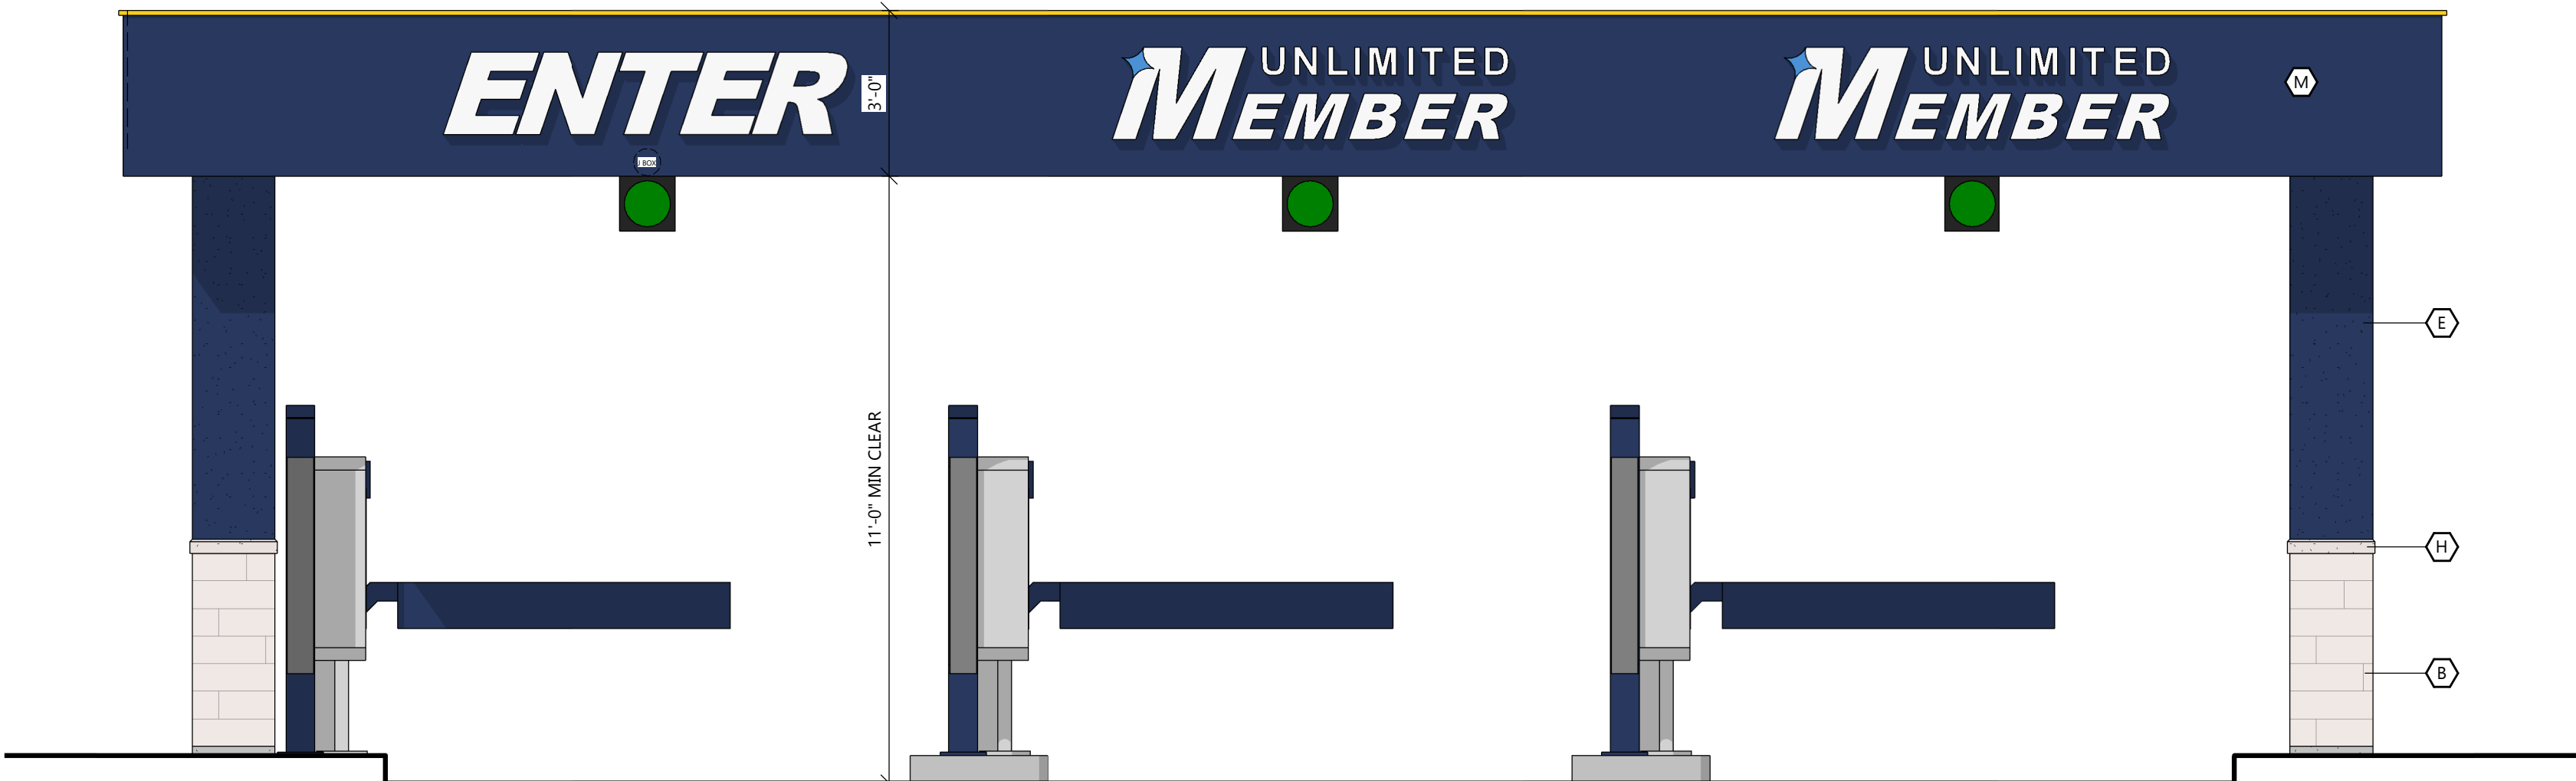

POS CANOPY ELEVATION
SCALE: 3/8" = 1'-0"

EXTERIOR MATERIAL KEY

	PREFINISHED ALUMINUM BATTENS MFR: LUMAQUILT STYLE: MOSAIC 1x6 BATTENS COLOR: HAZELNUT BROWN
	STONE VENEER MFR: EL DORADO STONE STYLE: VANTAGE 30 (6"H x 30"L x -1"D) COLOR: WHITE ELM w/ MATCHING MORTAR JOINT
	EPS TEXTURE: SAND COLOR: PT-6 (MORNING FOG)
	EPS TEXTURE: SAND COLOR: PT-3 (WALL STREET)
	EPS TEXTURE: SAND COLOR: PT-9 (IN THE NAVY)
	SINGLE WYTHE CMU TEXTURE: SMOOTH FACE INTEGRAL COLOR TO MATCH PT-6 (MORNING FOG)
	SINGLE WYTHE CMU TEXTURE: SPLIT FACE INTEGRAL COLOR TO MATCH PT-3 (WALLSTREET)
	PRECAST STONE SILL COLOR TO MATCH STONE VENEER
	PREFINISHED ALUMINUM WALL PANEL MFR: CTMS (OR EQUAL) COLOR: PT-9 (IN THE NAVY) STYLE: R PANEL
	PREFINISHED STANDING SEAM METAL ROOF PANEL MFR: CTMS (OR EQUAL) STYLE: LARGE BATTEN 24 GA COLOR: PT-9 (IN THE NAVY)
	PREFINISHED METAL TRIM AND ACCESSORIES MFR: CTMS (OR EQUAL) COLOR: PT-9 (IN THE NAVY)
	ALUMINUM STOREFRONT SYSTEM GLAZING: CLEAR FRAME: CLEAR ANODIZED
	CONCRETE STEM WALL TEXTURE: HAND RUB COLOR TO MATCH PT-10
	TREX DECK BOARD COLOR TO MATCH PT-3

GENERAL NOTES

- ALL SIGNAGE SHOWN FOR INFORMATIONAL PURPOSES ONLY. ALL ADVERTISING SIGNAGE SUBJECT TO SEPARATE SIGN PERMIT SUBMITTAL AND APPROVAL.
- EXTERIOR LIGHTING LOCATIONS SHOWN. SEE ELECTRICAL PLANS FOR EXTERIOR LIGHTING SPECIFICATIONS AND REQUIREMENTS. COORDINATE J-BOX LOCATIONS W/ FUTURE OWNER LIGHTING.
- APPLY CLEAR WATERPROOF SEALER TO ALL EXPOSED STONE VENEER AND CMU.
- METAL ROOF COLOR IS A CUSTOM COLOR. NO ALTERNATE WILL BE ACCEPTED.

PROJECT INFORMATION

PROPOSED CAR WASH FOR:
MISTER CAR WASH - CA 2637 SANTA ROSA
2700 SANTA ROSA AVE • SANTA ROSA, CA 95407

(130L-N - V1.2 - ZONE 4)

PROFESSIONAL SEAL

PRELIMINARY DATES
AUG. 8, 2025

NOT FOR CONSTRUCTION

JOB NUMBER
205209400

SHEET NUMBER

PRE-6

PRELIMINARY POS CANOPY